

INFORMATION AVAILABLE TO PREPARE DRAWINGS

ARCHITECTURAL DRAWINGS DATED 02/06/2019

NOTE TO ARCHITECT

MEMO DATED 12/13/19 NOTED G3 TYPE DOOR FOR DOOR # 117A, PLEASE CONFIRM IF THIS WILL BE A GLASS BARN DOOR

Door to be swing style as indicated on HKS drawings.

12" BACK TO BACK OFFSET PULLS CALLED OUT FOR GLASS SWING DOOR AND SLIDING DOORS, PLEASE CONFIRM.

GENERAL NOTES

1.) LIMITATIONS: THESE DRAWINGS REPRESENT AN INTERPRETATION OF ARCHITECTURAL INFORMATION MADE AVAILABLE TO KS DRAFTING & DESIGN, LLC. KS DRAFTING & DESIGN, LLC. MAKES NO REPRESENTATION OR WARRANTY TO THE PERFORMANCE OR COMPLETENESS OF THE ARCHITECTURAL DETAILS OF THE SURROUNDING AREAS.

2.) CONFIRMATION: ANY LISTED TOLERANCES, DIMENSIONS, DEFLECTION, ANCHORAGE, REFERENCES, AND FUNCTIONAL PERFORMANCE REQUIREMENTS SHALL BE CONFIRMED WITH THE ARCHITECT, AND VALIDATED BY FIELD MEASUREMENTS TO ENSURE SIZING, PERFORMANCE COMPLIANCE, AND ARCHITECTURAL INTENT.

4.) USE: KS DRAFTING & DESIGN, LLC. ASSUMES NO RESPONSIBILITY FOR THE USE OF THESE DRAWINGS BY OTHER TRADES.

5.) COMPLIANCE: ARCHITECT, ENGINEER, GENERAL CONTRACTOR, AND MISC. TRADES ARE RESPONSIBLE FOR THE SELECTION, INSTALLATION, AND ADJUSTMENT OF SYSTEMS TO ENSURE COMPLIANCE WITH ALL APPLICABLE DESIGN, ENERGY, RATING, BUILDING, AND/ OR SAFETY CODES.

6.) QUALITY OF CONSTRUCTION: ROUGH OPENINGS MAY NOT BE PLUMB, SQUARE, OR LEVEL. CONTRACTOR TO VERIFY EXISTING OPENINGS.

7.) RELEASE OF LIABILITY: THESE DRAWINGS HAVE BEEN PREPARED BY KS DRAFTING & DESIGN, LLC. FOR USE BY THE CUSTOMER. THE CUSTOMER AGREES TO ASSUME ALL LIABILITY AND ANY CLAIMS THAT MAY ARISE FROM THE USE OF, OR INFORMATION CONTAINED IN THESE DRAWINGS.

DOOR SCHEDULE

DOOR #	DOOR WIDTH	DOOR HEIGHT	ACTIVE LEAF	TYPE
100A	3'-0"	8'-3"	OUTSWING	SINGLE
100B	3'-0"	8'-3"	OUTSWING	SINGLE
103A	3'-0"	8'-0"	SLIDING	SINGLE
104A	3'-0"	8'-0"	SLIDING	SINGLE
108A	3'-0"	8'-0"	OUTSWING	SINGLE
108B	3'-0"	8'-0"	OUTSWING	SINGLE
111A	3'-0"	8'-0"	SLIDING	SINGLE
117A	3'-0"	8'-0"	INSWING	SINGLE
117B	3'-0"	8'-0"	INSWING	SINGLE
130A	3'-0"	8'-0"	SLIDING	SINGLE
131A	3'-0"	8'-0"	INSWING	SINGLE
159A	3'-0"	8'-0"	SLIDING	SINGLE
160A	3'-0"	8'-0"	SLIDING	SINGLE
163A	3'-0"	8'-0"	OUTSWING	SINGLE
164A	3'-0"	8'-0"	OUTSWING	SINGLE
173A	3'-0"	8'-0"	SLIDING	SINGLE
175A	3'-0"	8'-0"	INSWING	SINGLE
175B	3'-0"	8'-0"	INSWING	SINGLE
179A	3'-0"	8'-0"	SLIDING	SINGLE
180A	3'-0"	8'-0"	SLIDING	SINGLE
186A	3'-0"	8'-0"	SWING	SINGLE
186B	3'-0"	8'-0"	SWING	SINGLE
191A	3'-0"	8'-0"	SLIDING	SINGLE
193A	3'-0"	8'-0"	SLIDING	SINGLE
194A	3'-0"	8'-0"	SLIDING	SINGLE
195A	3'-0"	8'-0"	SLIDING	SINGLE
199A	3'-0"	8'-0"	SLIDING	SINGLE
200A	3'-0"	8'-0"	INSWING	SINGLE
201A	3'-0"	8'-0"	SLIDING	SINGLE
202A	3'-0"	8'-0"	SLIDING	SINGLE
203A	3'-0"	8'-0"	SLIDING	SINGLE
204A	3'-0"	8'-0"	SLIDING	SINGLE
211A	3'-0"	8'-0"	SLIDING	SINGLE
213A	3'-0"	7'-9"	INSWING	SINGLE
214A	3'-0"	8'-0"	SLIDING	SINGLE
216A	3'-0"	8'-0"	SLIDING	SINGLE
217A	3'-0"	8'-0"	SLIDING	SINGLE

218A	3'-0"	8'-0"	SLIDING	SINGLE
219A	3'-0"	8'-0"	SLIDING	SINGLE
220A	3'-0"	8'-0"	INSWING	SINGLE
221A	3'-0"	8'-0"	SLIDING	SINGLE
222A	3'-0"	8'-0"	SLIDING	SINGLE
223A	3'-0"	8'-0"	SLIDING	SINGLE
224A	3'-0"	8'-0"	SLIDING	SINGLE
225A	3'-0"	8'-0"	INSWING	SINGLE

SWINGING DOOR HARDWARE:

PIVOTS

12" BACK TO BACK PULL OFFSET HANDLES

CONCEALED OVERHEAD CLOSERS

1-3/4" X 4-1/2" HEADER TUBE

4" TOP + BOTTOM DOOR RAILS

SLIDING DOOR HARDWARE:

12" BACK TO BACK OFFSET PULL HANDLES

CRL 70 SLIDING DOOR

TOP TRACK + BOTTOM GUIDE

STANLEY DURAGLIDE AUTO SLIDING DOOR UNIT FOR DOORS 100A AND 100B - STANDARD LOCKING JAMB AT LATCH SIDE - STANDARD SURFACE HEADER MOUNTED TO FACE OF CURTAINWALL FRAMING

GLASS SCHEDULE

MARK	GLAZING DESCRIPTION AND MAKEUP	NOTES
GL-1	DESCRIPTION 1/2" CLEAR, TEMPERED	
GL-2	DESCRIPTION 1/4" CLEAR, TEMPERED	
GL-3	DESCRIPTION 1" CLEAR NON LOW E INSULATED GLASS UNIT	

FIRE-RATED FRAMES TO BE SUBMITTED UNDER SEPARATE SUBMITTAL

AUTO SLIDING DOOR UNITS TO BE SUBMITTED UNDER SEPARATE SUBMITTAL

FILM @ PANEL SCHEDULE

MARK	GLAZING DESCRIPTION AND MAKEUP	NOTES
PNL	DESCRIPTION 3M VARIA GLAZED IN PANEL	
FILM-1	DESCRIPTION SECURITY FILM	
FILM-2	DESCRIPTION TRANSLUCENT FILM	

MATERIAL SCHEDULE

PRODUCT TYPE	MANUFACTURER	SYSTEM	PROFILE DIMENSIONS	DESCRIPTION	FINISH
INTERIOR STOREFRONT	TUBELITE	E14000	2" X 4-1/2"	NON-THERMAL, CENTER SET, OUTSIDE GLAZED, SCREW SPLINE	DARK BRONZE ANODIZED
SLIDING DOORS + FIXED SIDELITES	CRL	701C	4-3/8" X 2-7/8"	BOTTOM CHANNEL DIMENSIONS: 1" X 1"	DARK BRONZE ANODIZED
INTERIOR CURTAIN WALL	TUBELITE	400TU	2-1/2 X 10"	HIGH PERFORMANCE THERMAL CURTAIN WALL	DARK BRONZE ANODIZED
CRL EZ GLAZE BUTT JOINT FILLER					

SHEET LIST

SHEET	DESCRIPTION
100	COVER SHEET
201	PARTIAL FLOOR PLAN - SECTOR 1
202	PARTIAL FLOOR PLAN - SECTOR 2
203	FRAME ELEVATIONS
204	FRAME ELEVATIONS
205	FRAME ELEVATIONS
206	FRAME ELEVATIONS
207	FRAME ELEVATIONS
208	FRAME ELEVATIONS
209	FRAME ELEVATIONS
210	FRAME ELEVATIONS
400	DETAILS
401	DETAILS
402	DETAILS
403	DETAILS
404	DETAILS

NO.	REVISION/ISSUED	DATE
1	1ST SUBMITTAL	12/23/19
2	PER COMMENTS	2/18/20

PROJECT NAME & LOCATION:	FDA	10749 WEST 84TH TERRACE LENEXA, KANSAS 66214	SHEET TITLE: COVER SHEET
--------------------------	-----	---	-----------------------------

DRAFTSMAN:

KS DRAFTING & DESIGN, LLC.
KYLE SCHNECK
HARRISBURG, PA 17111
KYLE@KSDRAFTINGDESIGNLLC.COM
717-228-7114
KSDRAFTINGDESIGNLLC.COM

ARCHITECT:

GLAZING CONTRACTOR:


DRAWN BY: KEVIN VERGARA

CHECKED BY: KYLE SCHNECK

DATE: 2/18/2020

SHEET:

100

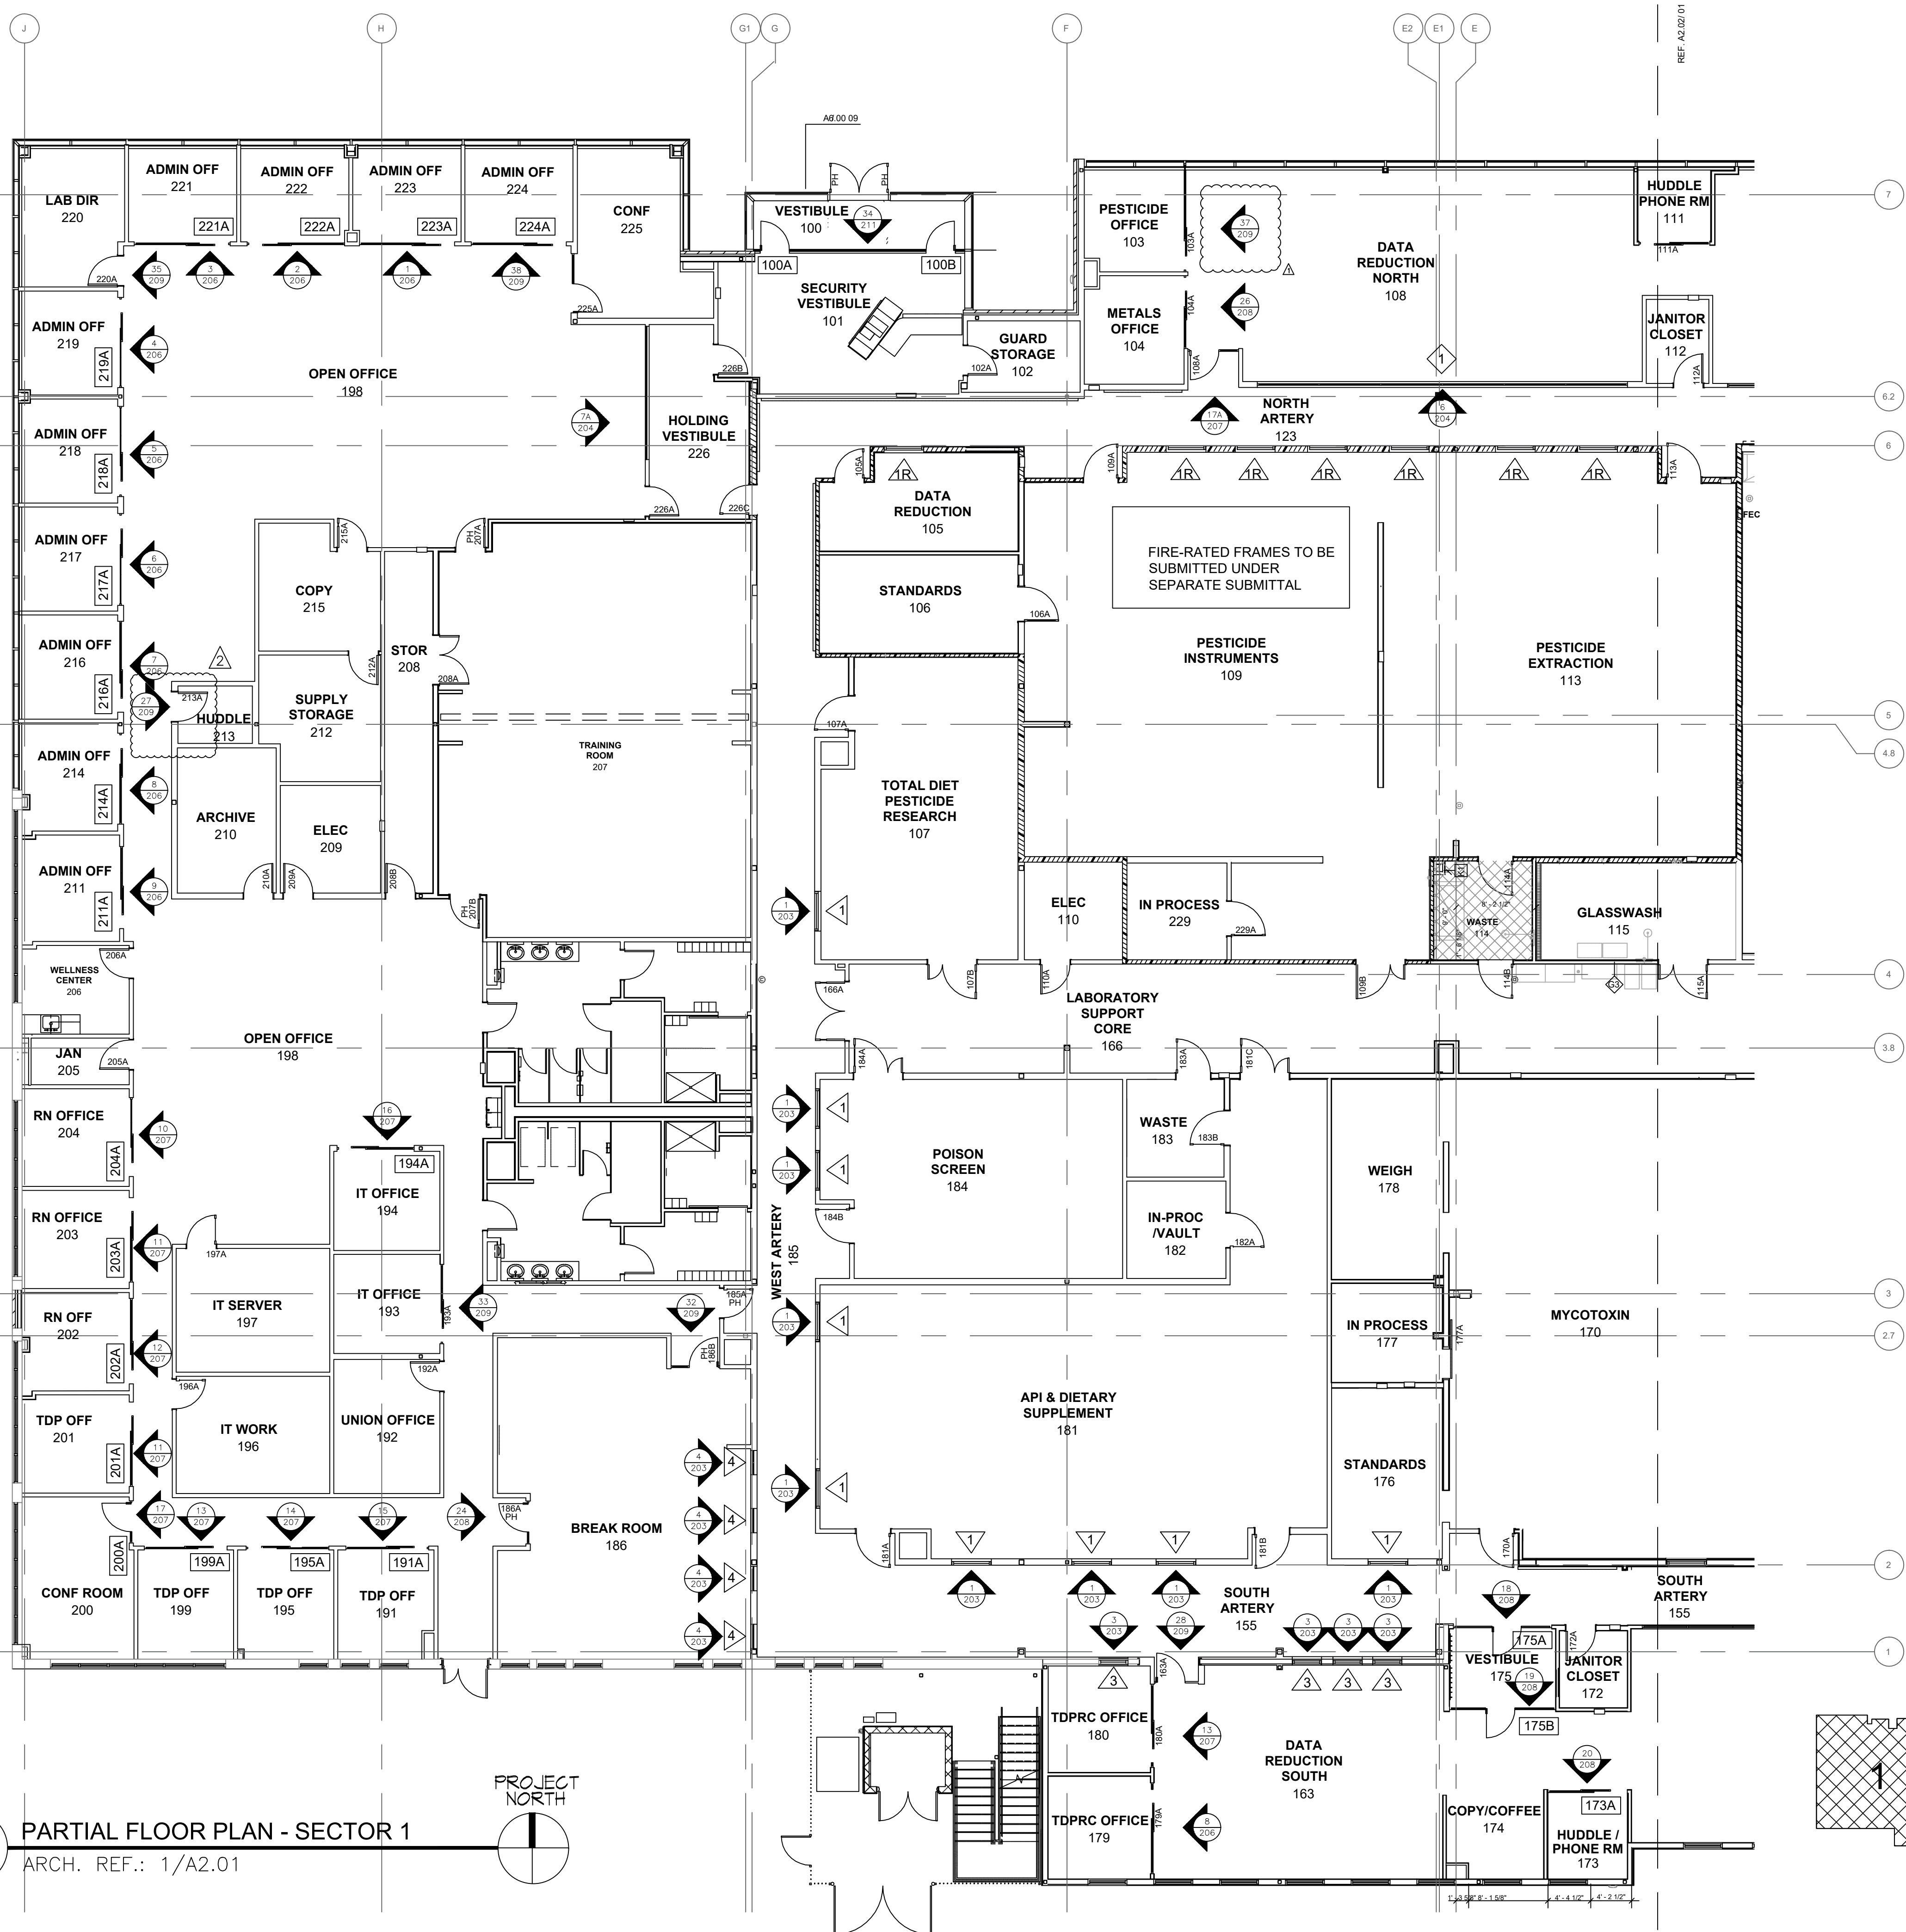

AUTO SLIDING DOOR UNITS
TO BE SUBMITTED UNDER
SEPARATE SUBMITTAL

FIRE-RATED FRAMES TO BE
SUBMITTED UNDER
SEPARATE SUBMITTAL

1 PARTIAL FLOOR PLAN - SECTOR 1
ARCH. REF.: 1/A2.01



NO.	REVISION/ISSUED	DATE
1	1ST SUBMITTAL	12/23/19
2	PER COMMENTS	2/18/20

PROJECT NAME & LOCATION:
FDA

10749 WEST 84TH TERRACE
LENEXA, KANSAS 66214

SHEET TITLE:

PARTIAL FLOOR PLAN - SECTOR 1

DRAFTSMAN:

KS DRAFTING & DESIGN, LLC.
KYLE SCHNECK
HARRISBURG, PA 17111
KYLE@KSDRAFTINGDESIGNLLC.COM
717-228-7114
KSDRAFTINGDESIGNLLC.COM

ARCHITECT:

GLAZING CONTRACTOR:


DRAWN BY: KEVIN VERGARA


CHECKED BY: KYLE SCHNECK

DATE: 12/23/19

SHEET:

201

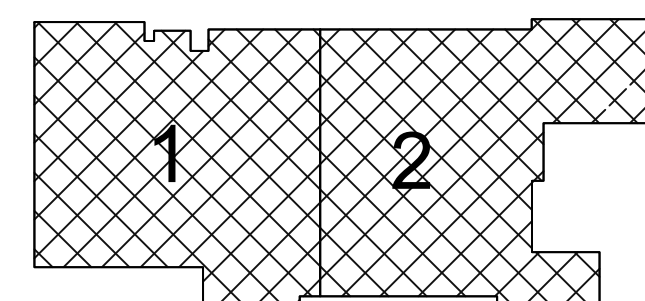

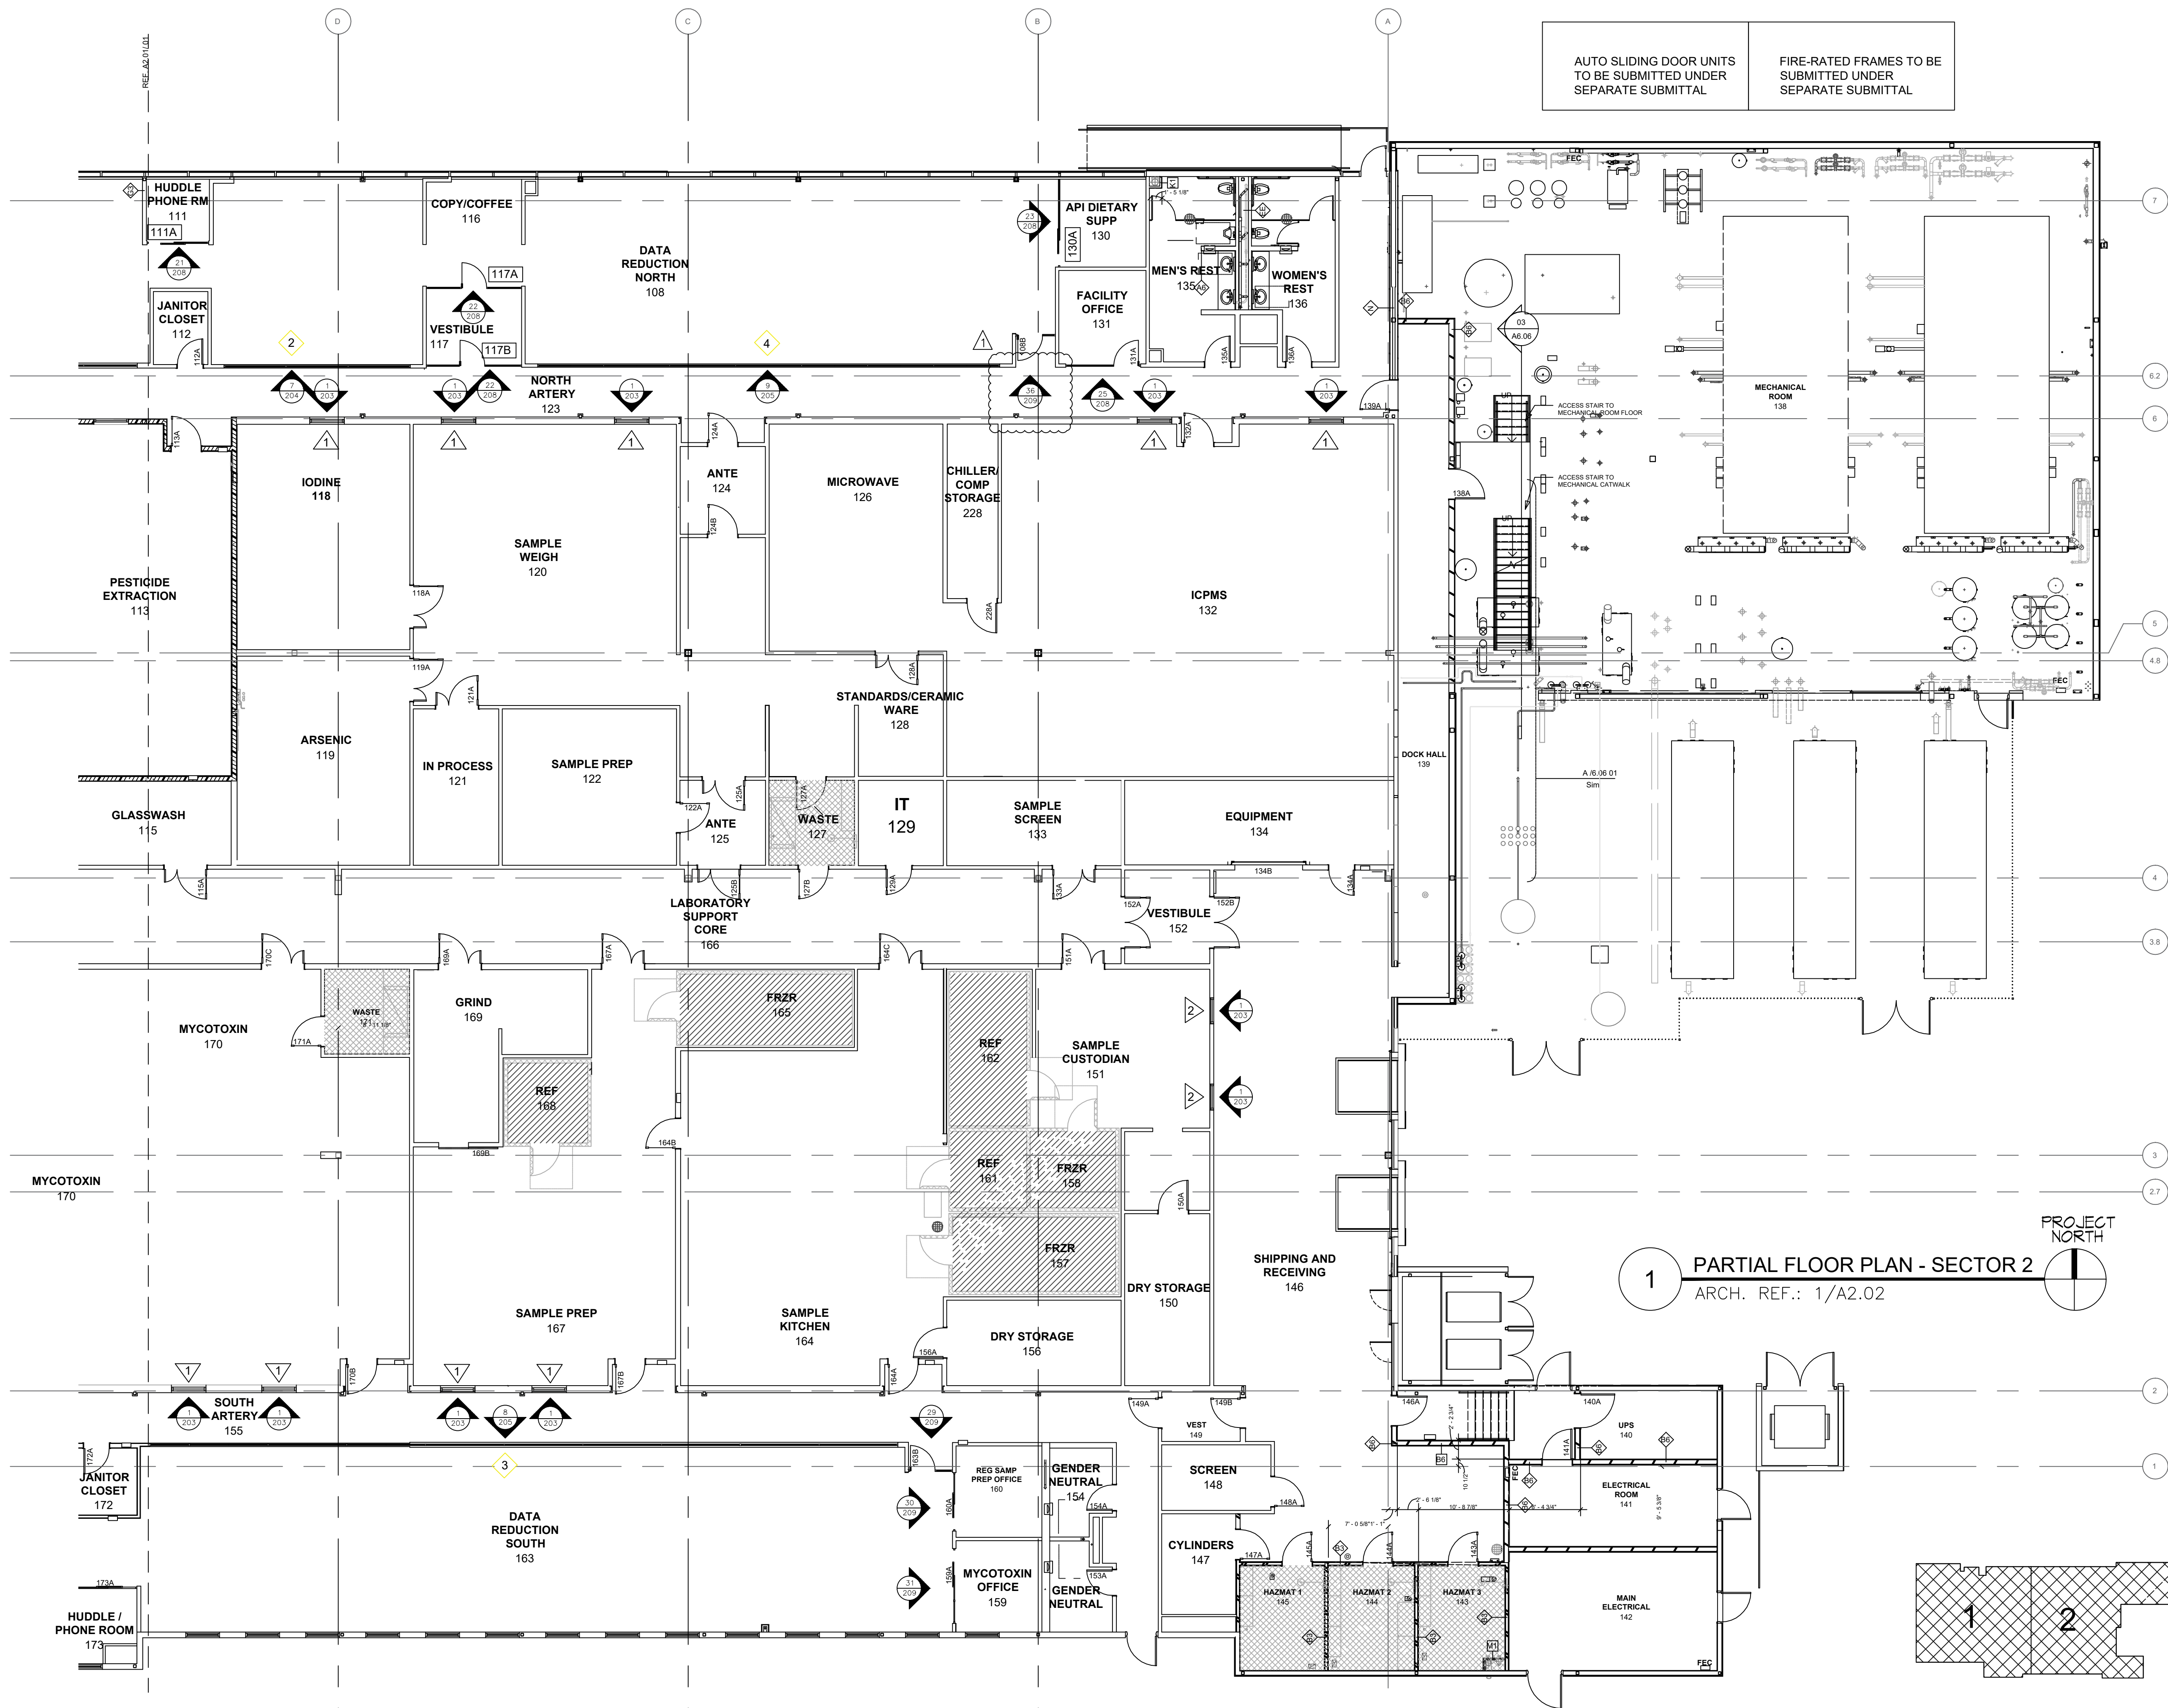

AUTO SLIDING DOOR UNITS
TO BE SUBMITTED UNDER
SEPARATE SUBMITTAL

FIRE-RATED FRAMES TO BE
SUBMITTED UNDER
SEPARATE SUBMITTAL

NO.	REVISION /ISSUED	DATE
1	1ST SUBMITTAL	12/23/19
2	1ST REVISION	2/19/20

PROJECT NAME & LOCATION:	FDA
10749 WEST 84TH TERRACE LENEXA, KANSAS 66214	
SHEET TITLE:	PARTIAL FLOOR PLAN - SECTOR 2


DRAFTSMAN:
KS DRAFTING & DESIGN, LLC. KYLE SCHNECK HARRISBURG, PA 17111 KYLE@KSDRAFTINGDESIGNLLC.COM 717-228-7114 KSDRAFTINGDESIGNLLC.COM

ARCHITECT:

GLAZING CONTRACTOR:


DRAWN BY:	KEVIN VERGARA
CHECKED BY:	KYLE SCHNECK

DATE:	12/23/19	SHEET:	202
-------	----------	--------	-----

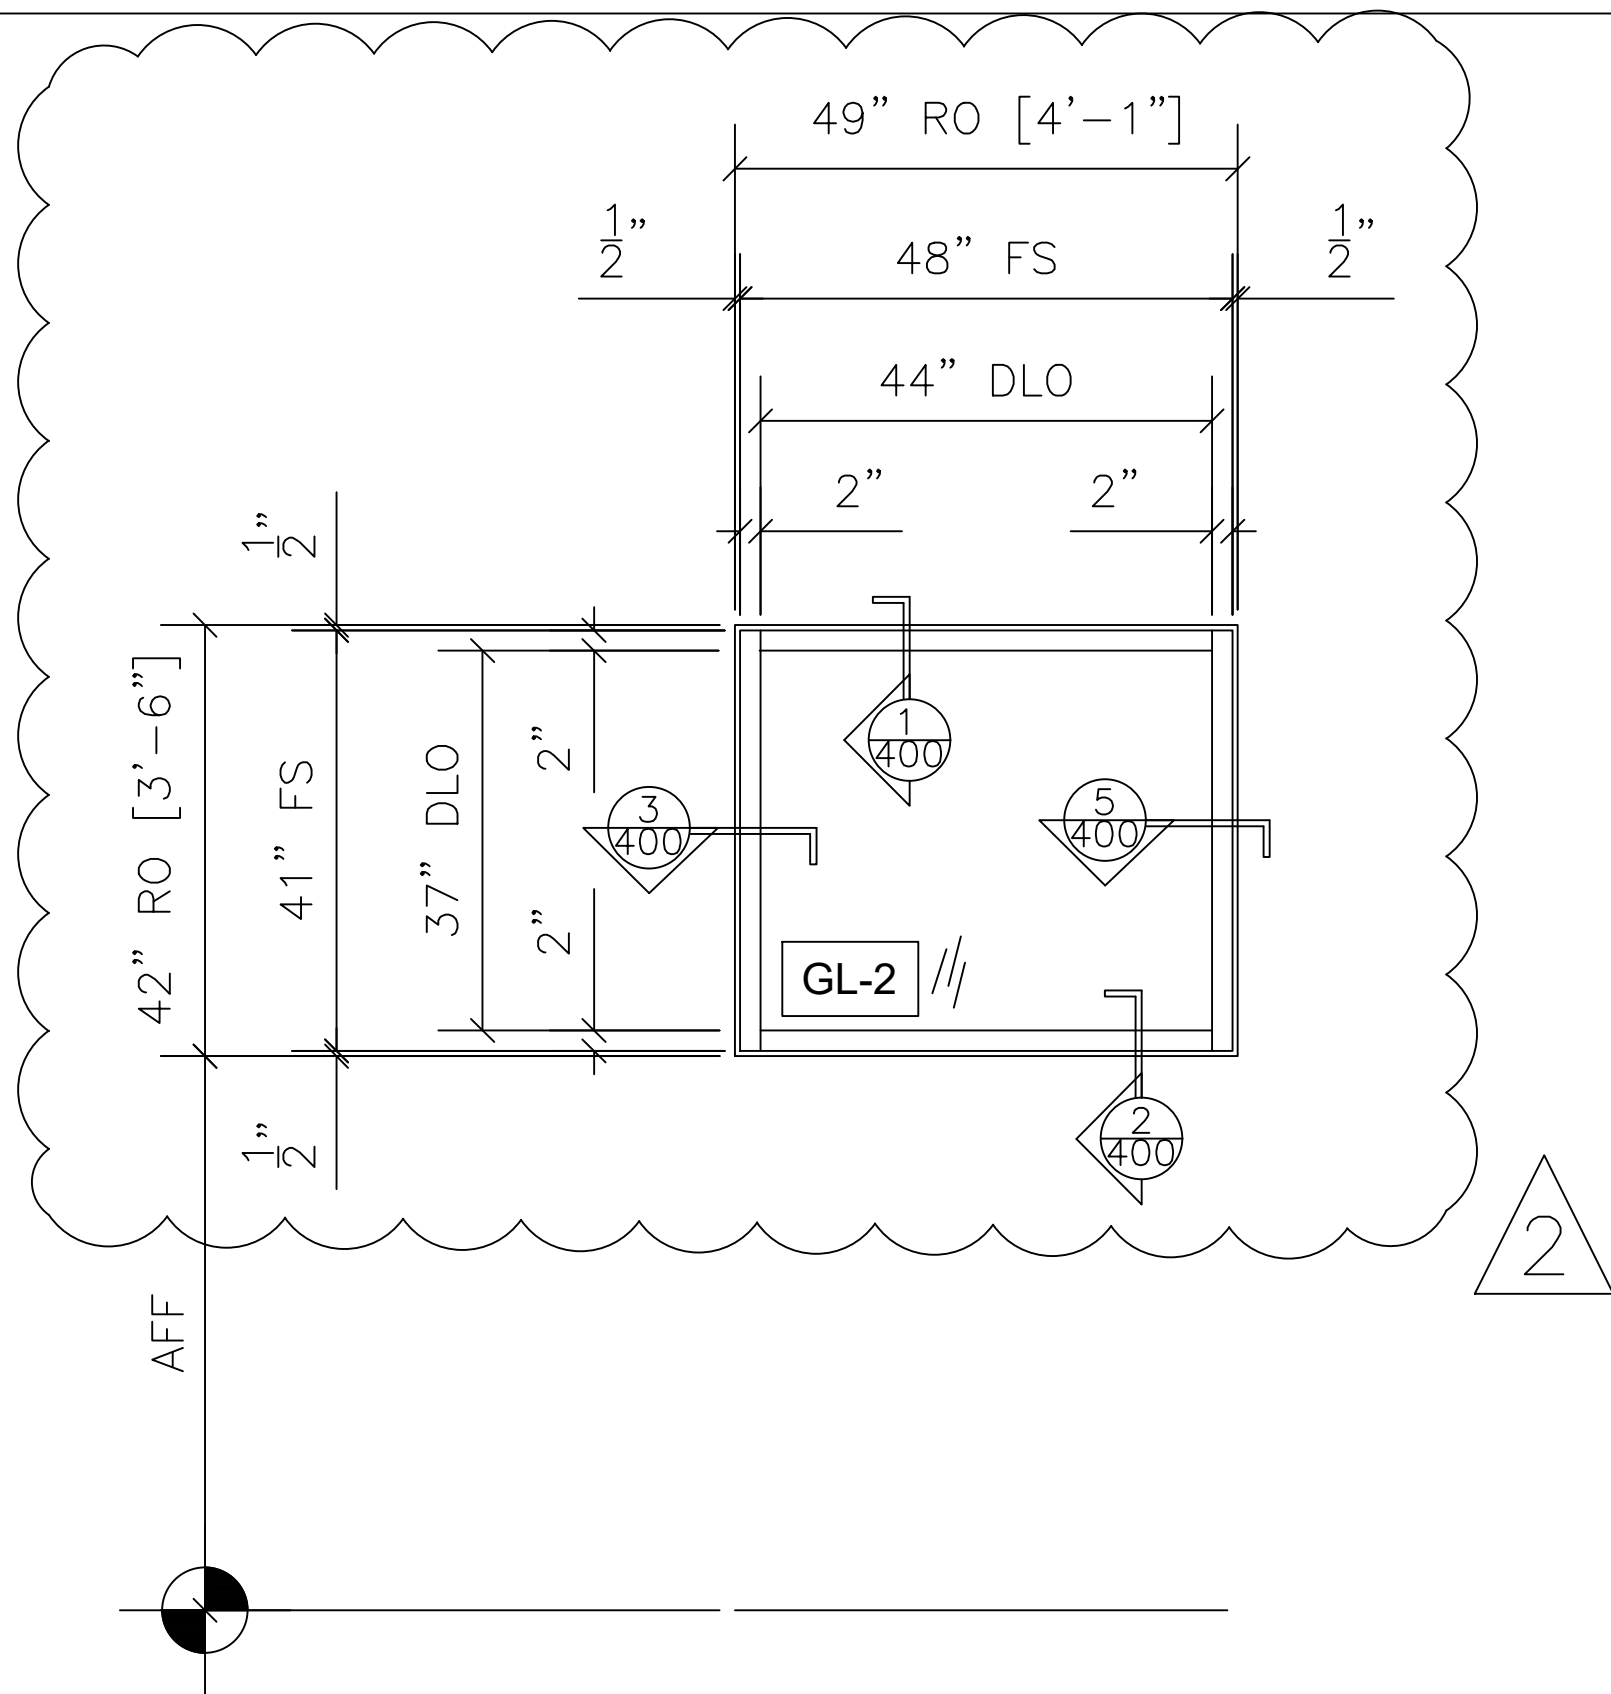


WINDOW TYPE 1 ELEVATION		QTY	LOCATION
1	TUBELITE E14000	8	SOUTH ARTERY 156
	INTERIOR STOREFRONT	5	WEST ARTERY 185
	ARCH. REF.: 1/A3.31	5	NORTH ARTERY 123


18 TOTAL

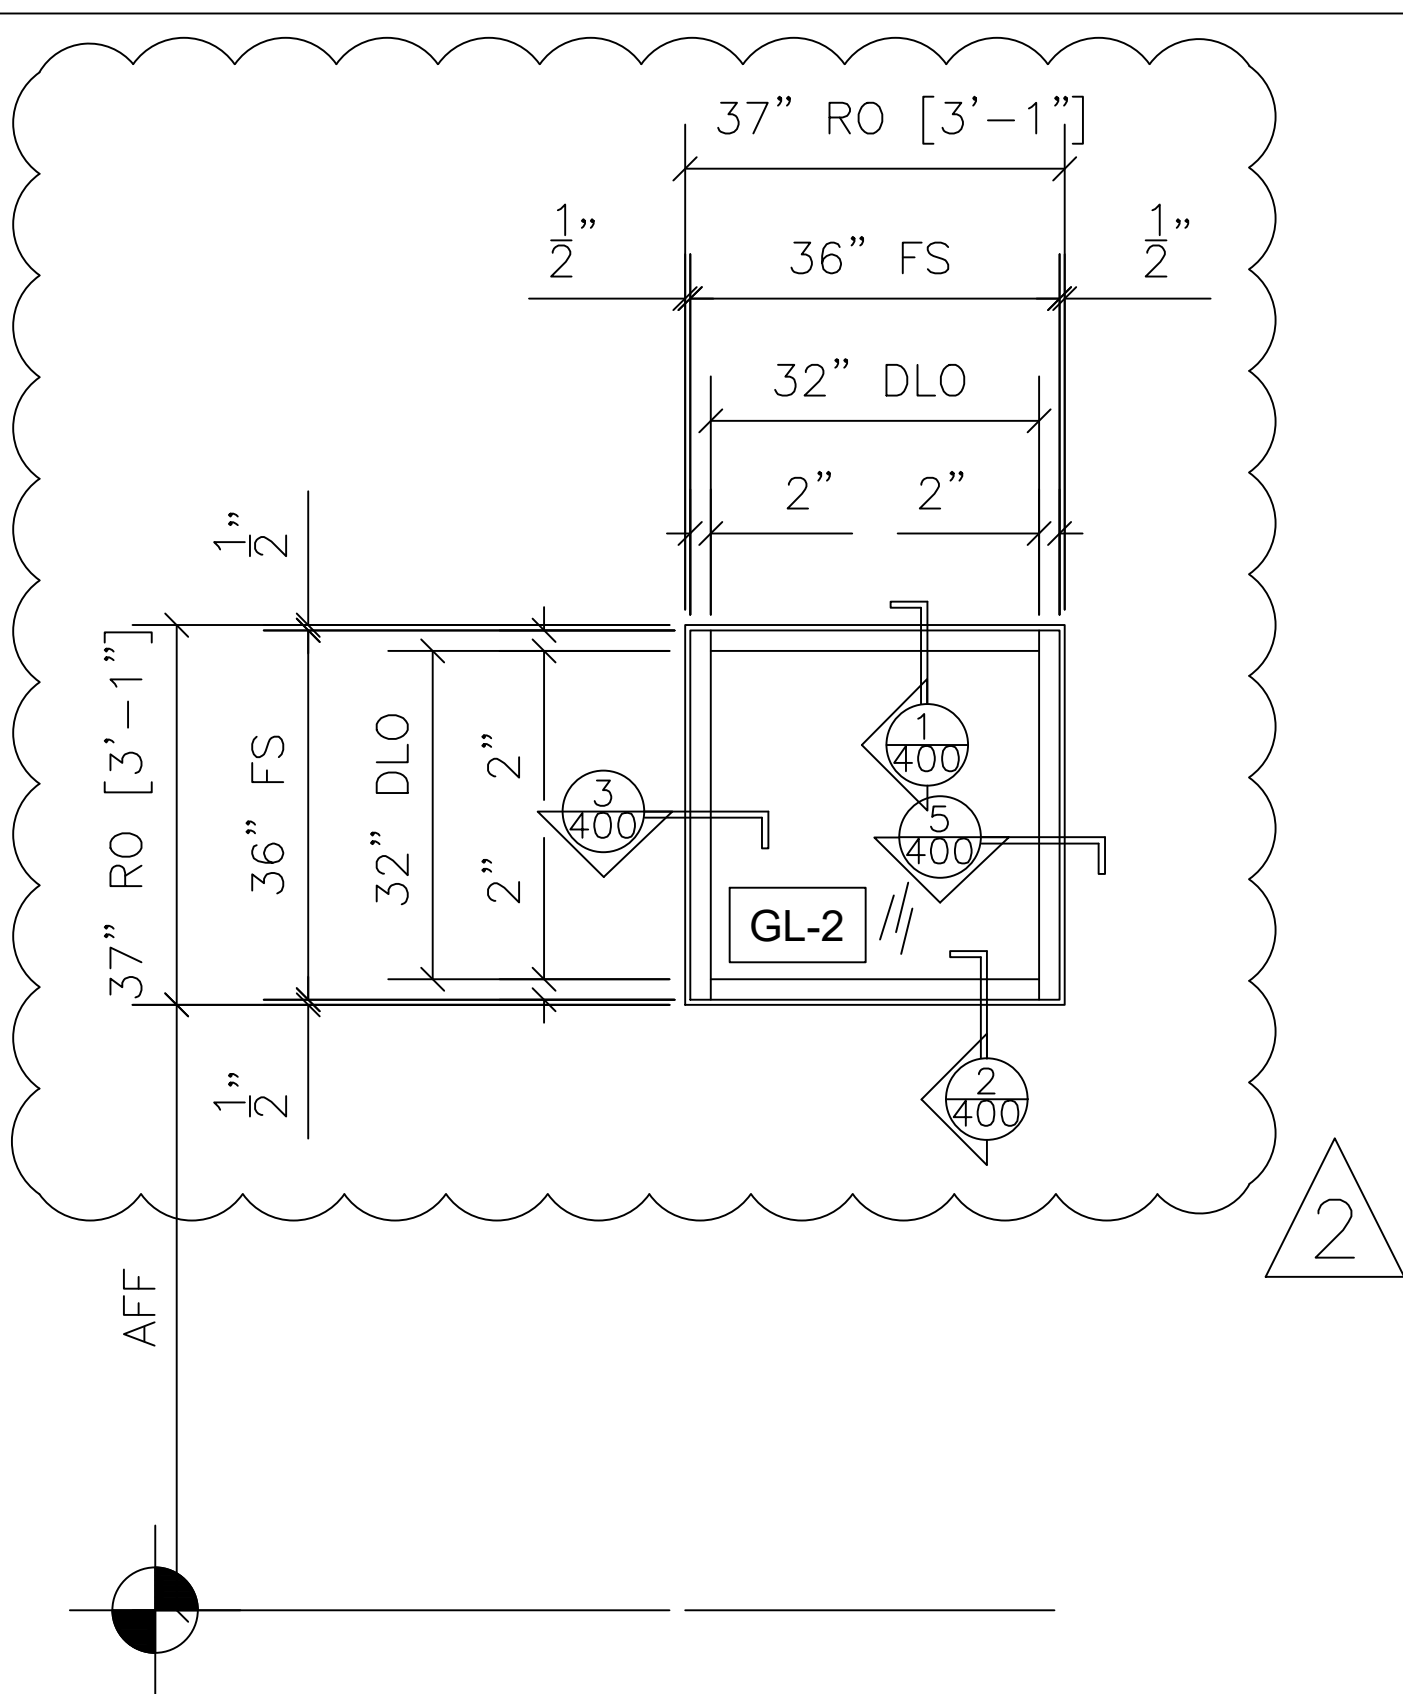

WINDOW TYPE 2 ELEVATION		QTY	LOCATION
2	TUBELITE E14000	2	SAMPLE CUSTODIAN 151
	INTERIOR STOREFRONT		
ARCH. REF.: 2/A3.31		2 TOTAL	

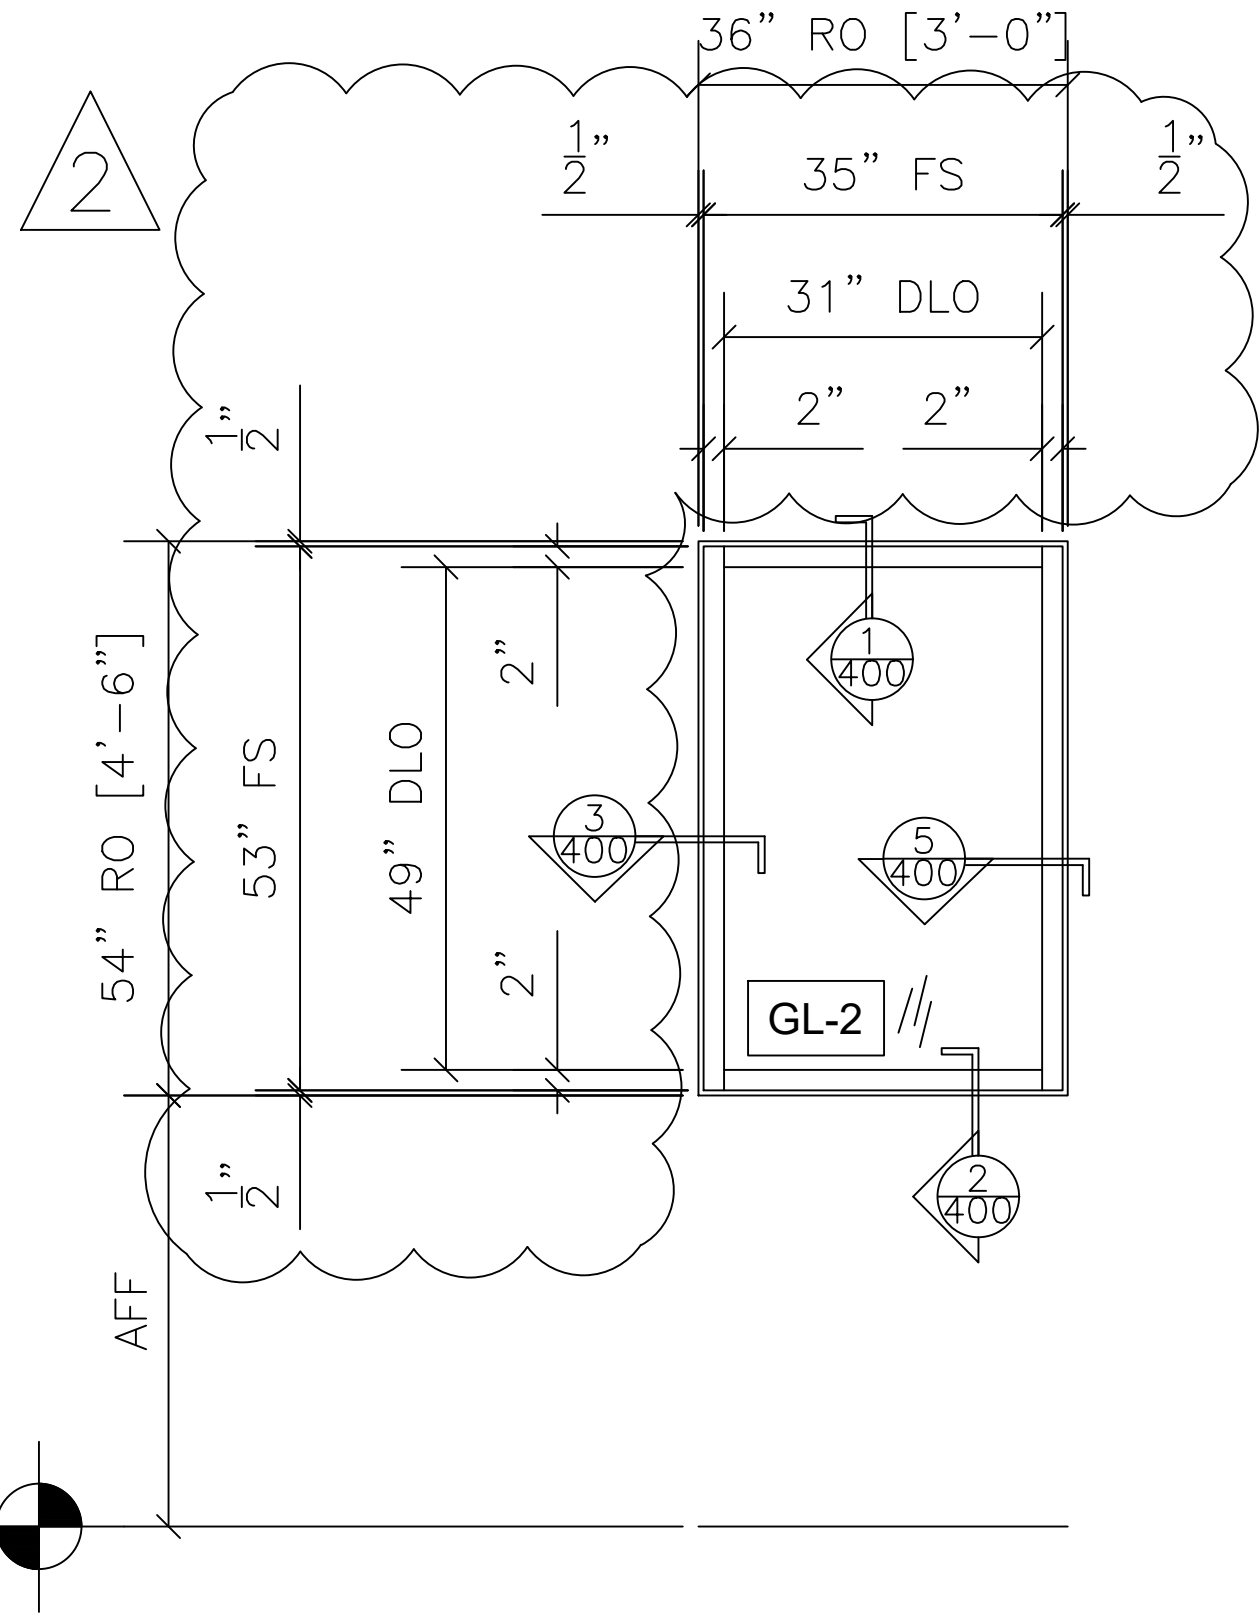

WINDOW TYPE 3 ELEVATION		QTY	LOCATION
3	TUBELITE E14000	1	TDPRC OFFICE 180
	INTERIOR STOREFRONT	3	DATA REDUCTION SOUTH 163
ARCH. REF.: 3/A3.31		4 TOTAL	

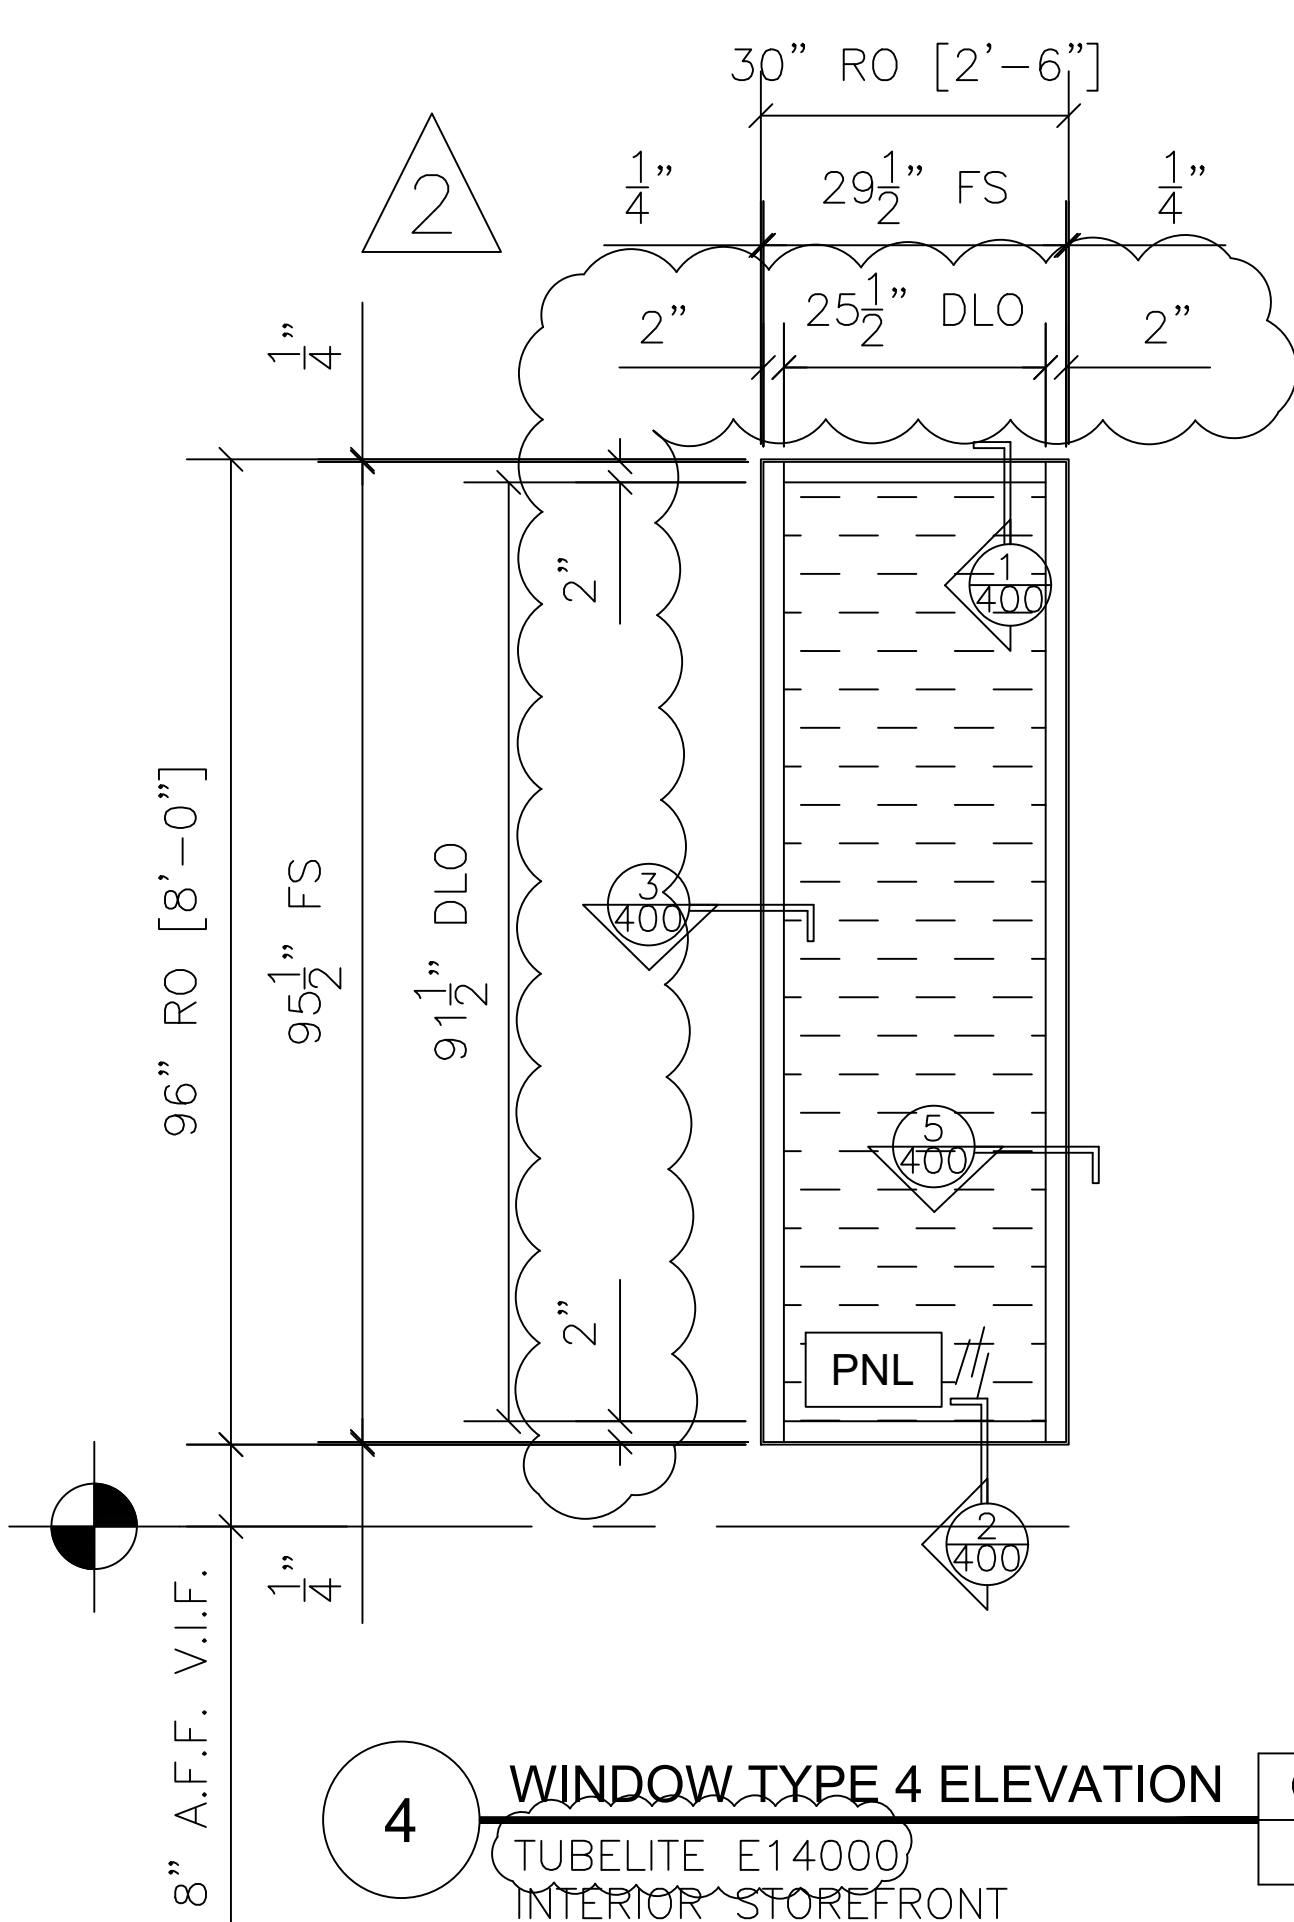

WINDOW TYPE 4 ELEVATION		QTY	LOCATION
4	TUBELITE E14000	4	BREAK ROOM 186
	INTERIOR STOREFRONT		
ARCH. REF.: 8/A3.31		4 TOTAL	

NO.	REVISION/ISSUED	DATE
1	1ST SUBMITTAL	12/23/19
2	PER COMMENTS	2/18/20

PROJECT NAME & LOCATION:	FDA
	10749 WEST 84TH TERRACE LENEXA, KANSAS 66214
	SHEET TITLE: FRAMING ELEVATION


DRAFTSMAN:
KS DRAFTING & DESIGN, LLC. KYLE SCHNECK HARRISBURG, PA 17110 KYLE@KSDRAFTINGDESIGNLLC.COM 717-228-7114 KSDRAFTINGDESIGNLLC.COM

ARCHITECT:

GLAZING CONTRACTOR:

DRAWN BY:	KEVIN VERGARA
CHECKED BY:	KYLE SCHNECK

DATE:	12/23/19	SHEET:
		203

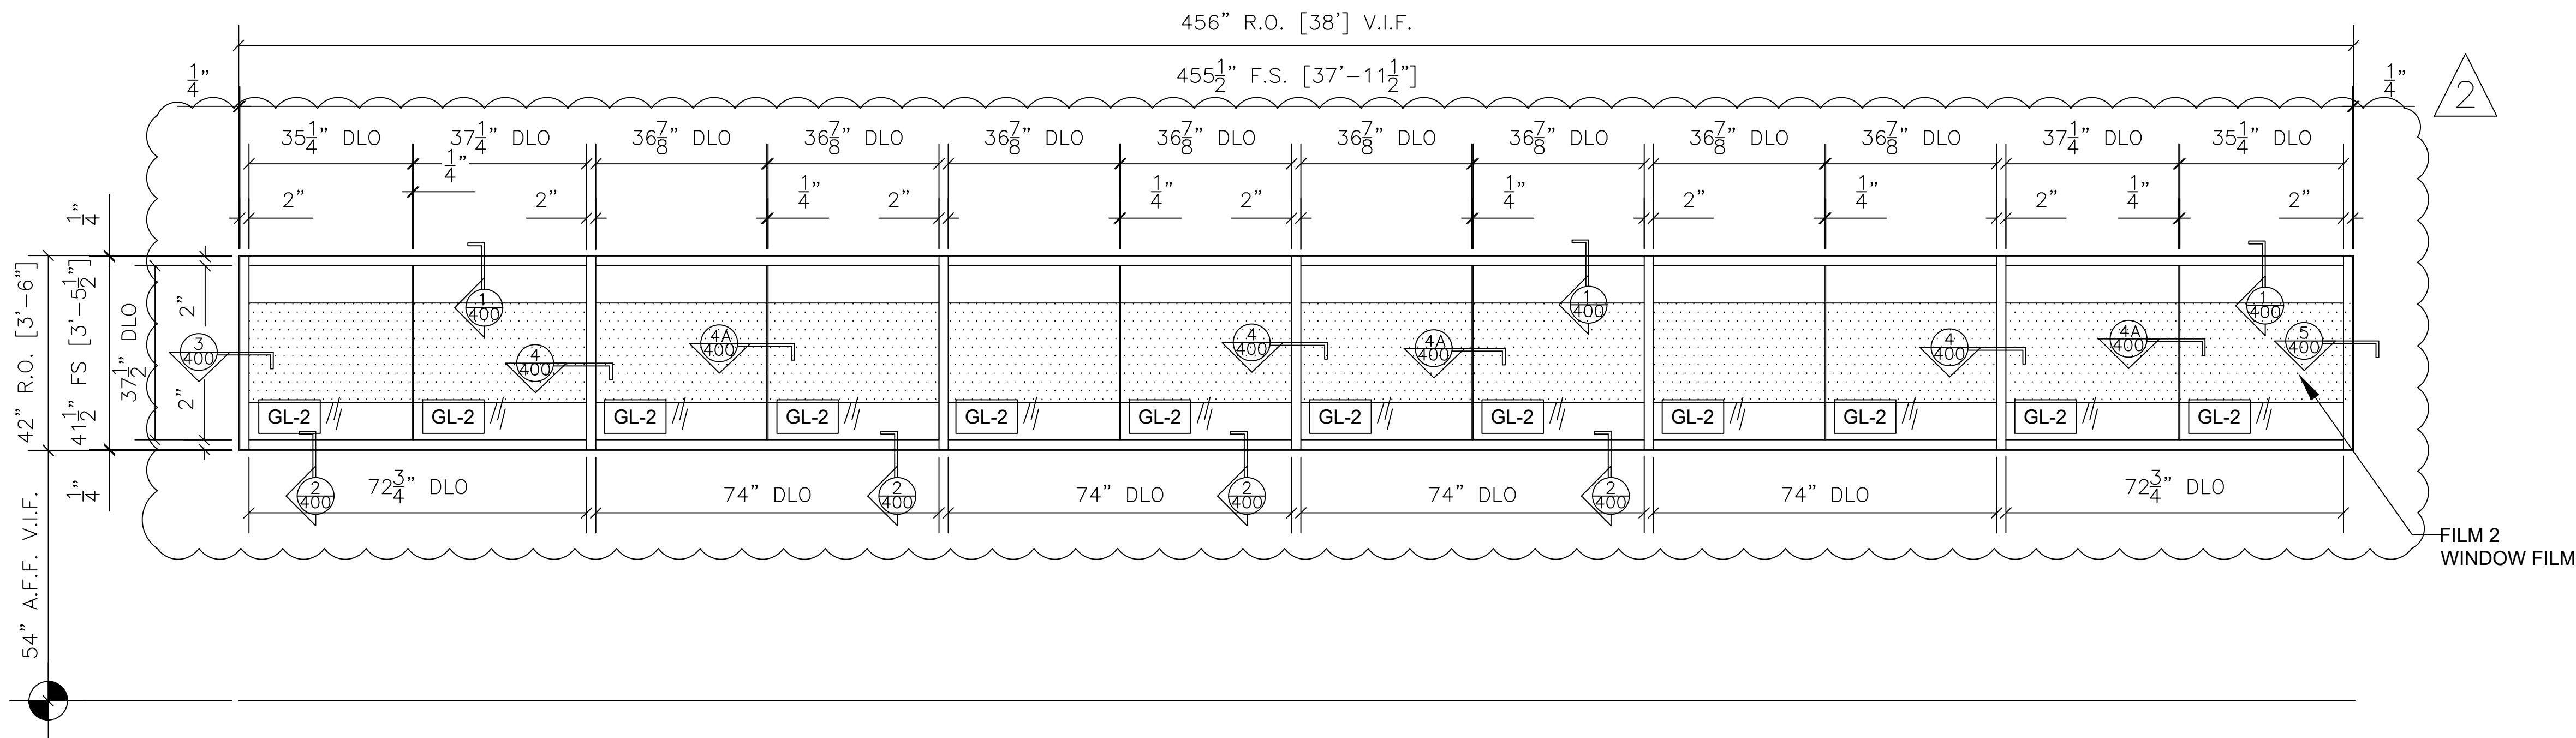


6 WINDOW FRAMING ELEVATION

QTY	LOCATION
1	NORTH ARTERY 123

1 TOTAL

TUBELITE E14000
INTERIOR STOREFRONT
ARCH. REF.: SIM. 4/A3.31

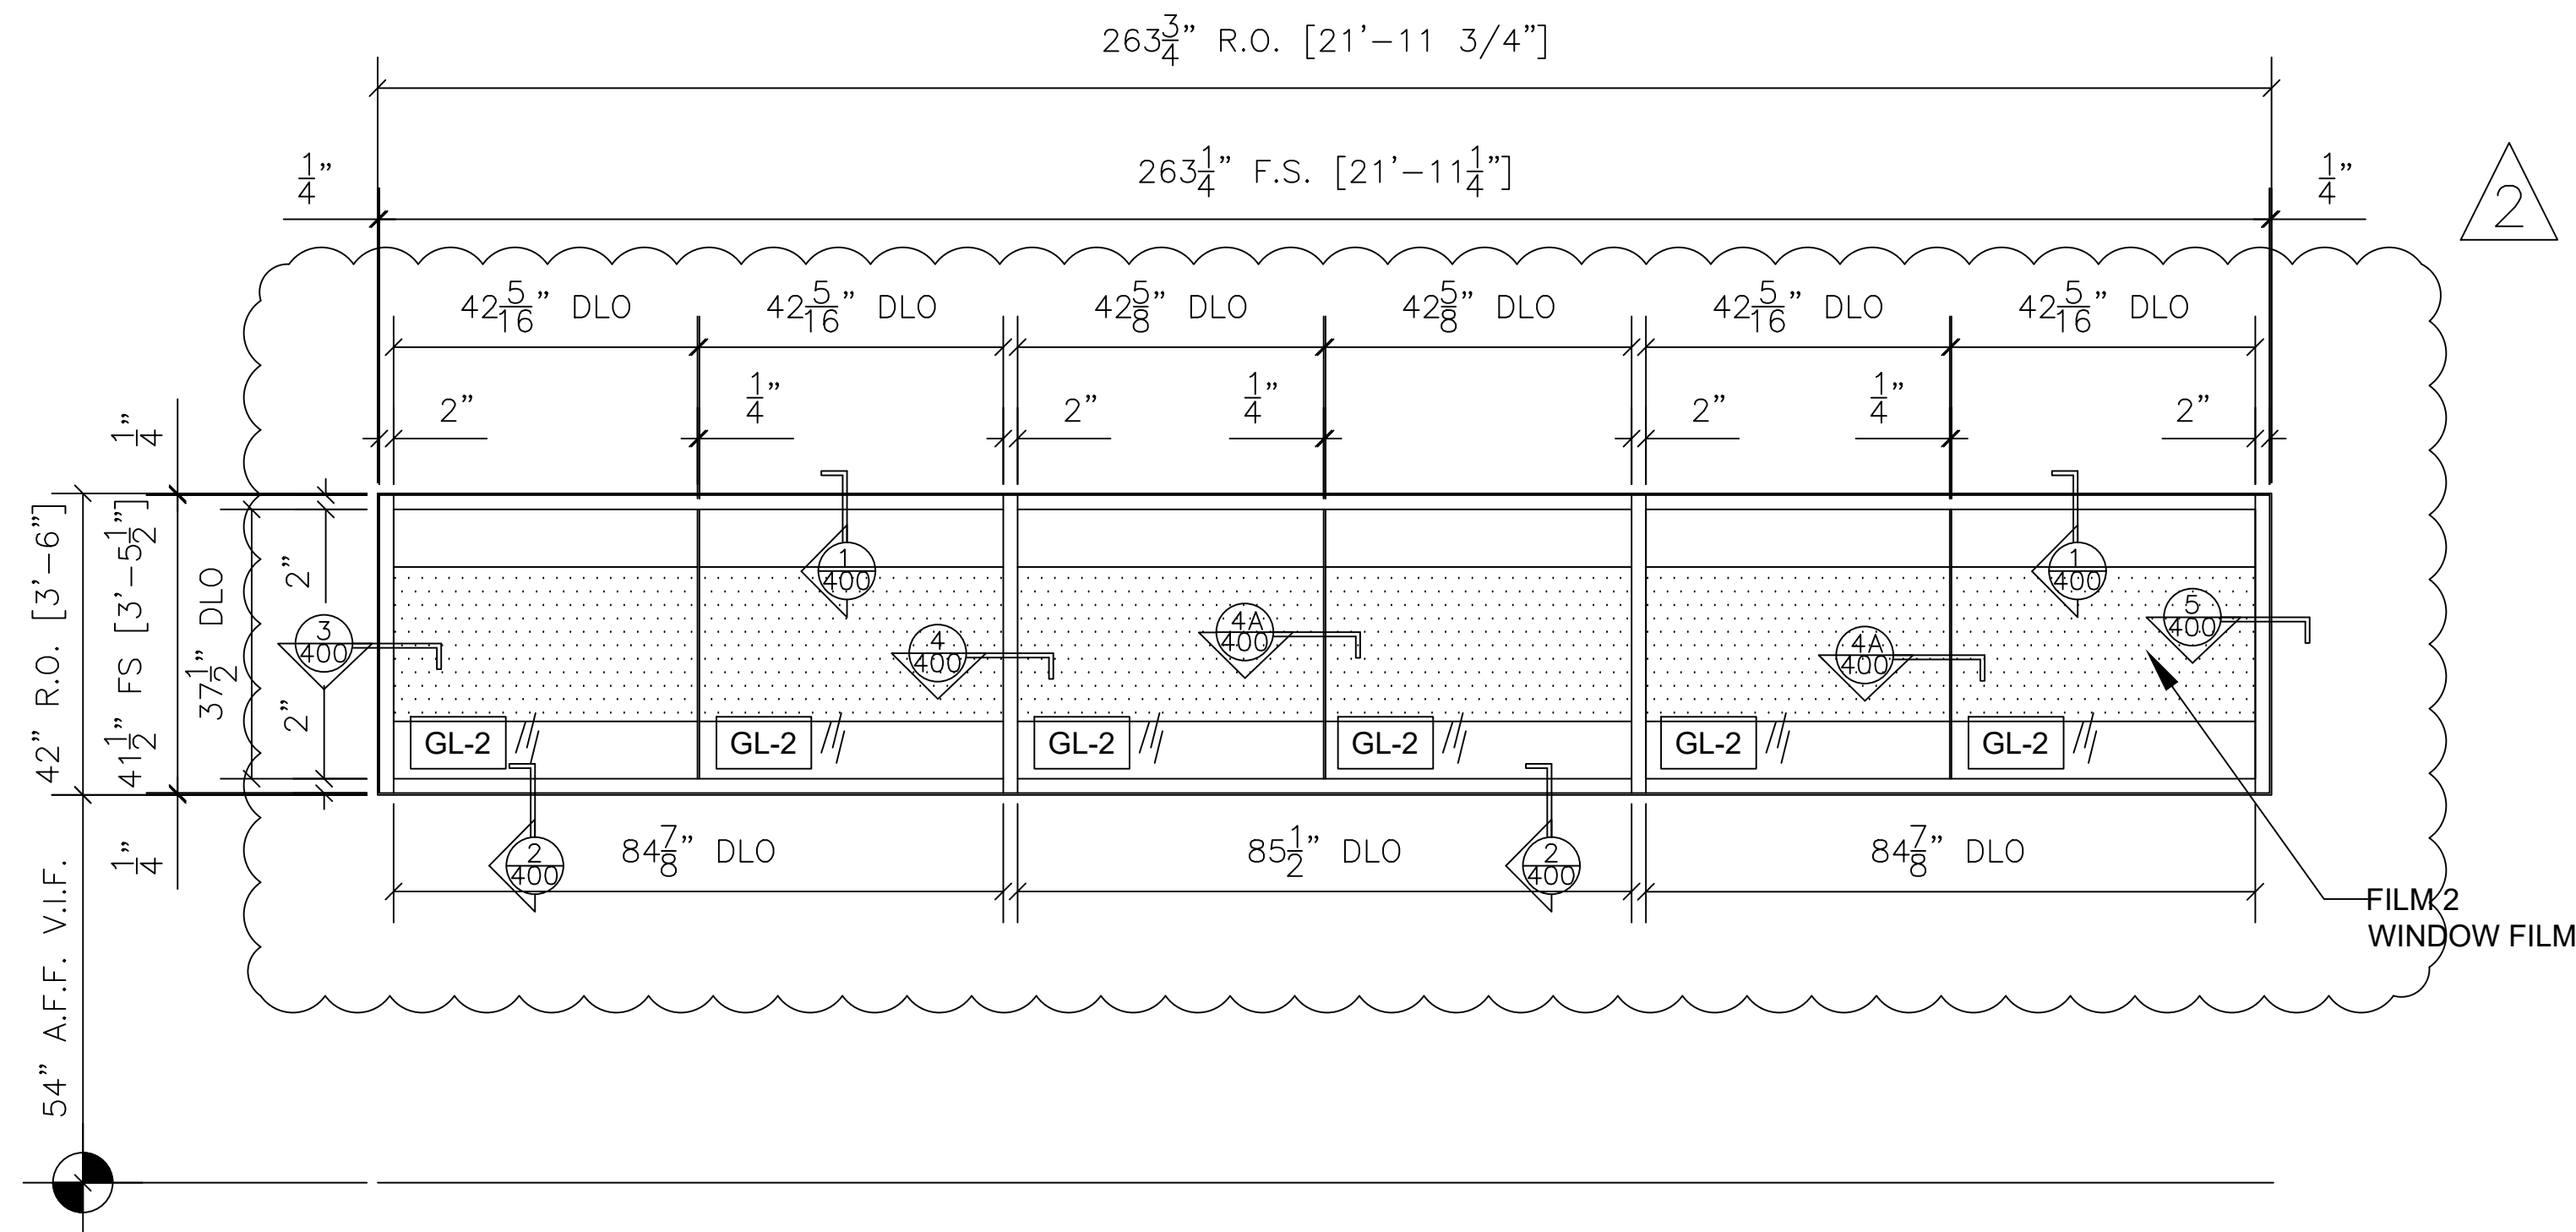


7 WINDOW FRAMING ELEVATION

QTY	LOCATION
1	NORTH ARTERY 123

1 TOTAL

TUBELITE E14000
INTERIOR STOREFRONT
ARCH. REF.: SIM. 4/A3.31

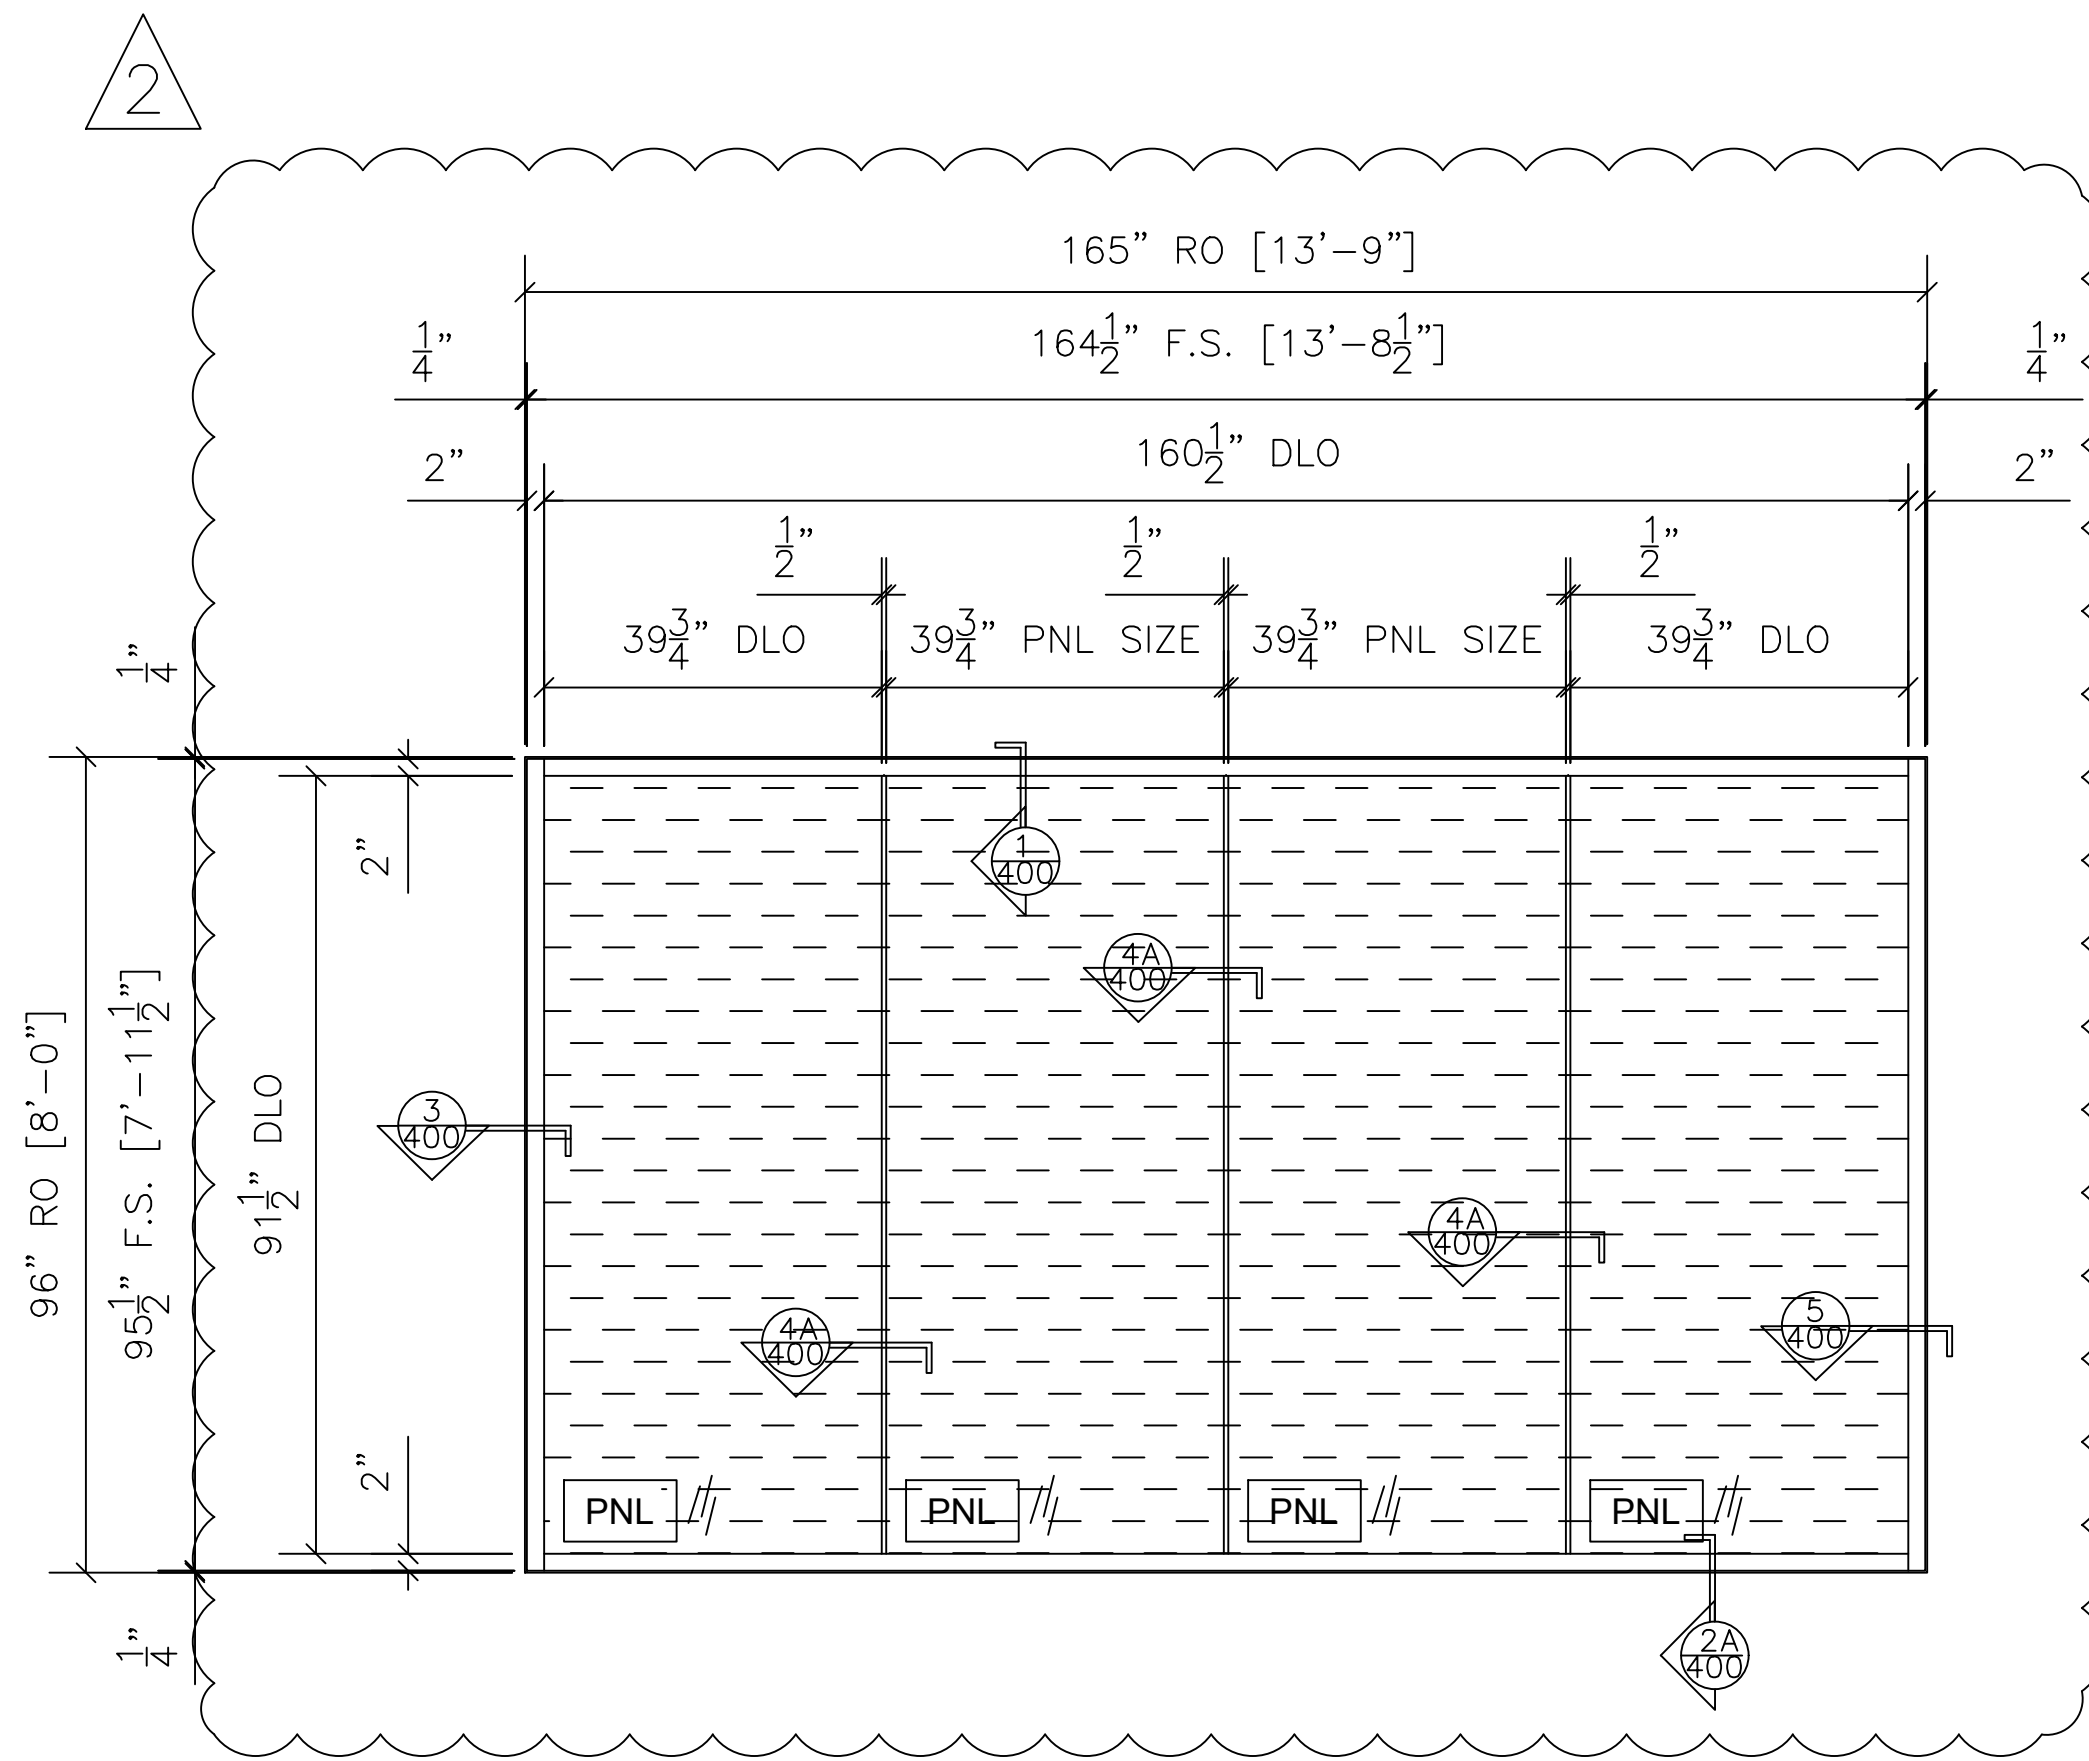

7A WINDOW TYPE 5 ELEVATION

QTY	LOCATION
1	HOLDING VESTIBULE 226

1 TOTAL

TUBELITE E14000
INTERIOR STOREFRONT
ARCH. REF.: 8/A3.31

NO.	REVISION/ISSUED	DATE
1	1ST SUBMITTAL	12/23/19
2	PER COMMENTS	2/18/20

PROJECT NAME & LOCATION:	FDA	10749 WEST 84TH TERRACE LENEXA, KANSAS 66214	SHEET TITLE:	FRAMING ELEVATION
--------------------------	-----	---	--------------	-------------------



DRAFTSMAN:	KS DRAFTING & DESIGN, LLC. KYLE SCHNECK HARRISBURG, PA 17110 KYLE@KSDRAFTINGDESIGNLLC.COM 717-228-7114 KSDRAFTINGDESIGNLLC.COM
------------	---

ARCHITECT:	
------------	--

GLAZING CONTRACTOR:	
---------------------	--

DRAWN BY:	KEVIN VERGARA
CHECKED BY:	KYLE SCHNECK


DATE:	12/23/19	SHEET:	204
-------	----------	--------	-----

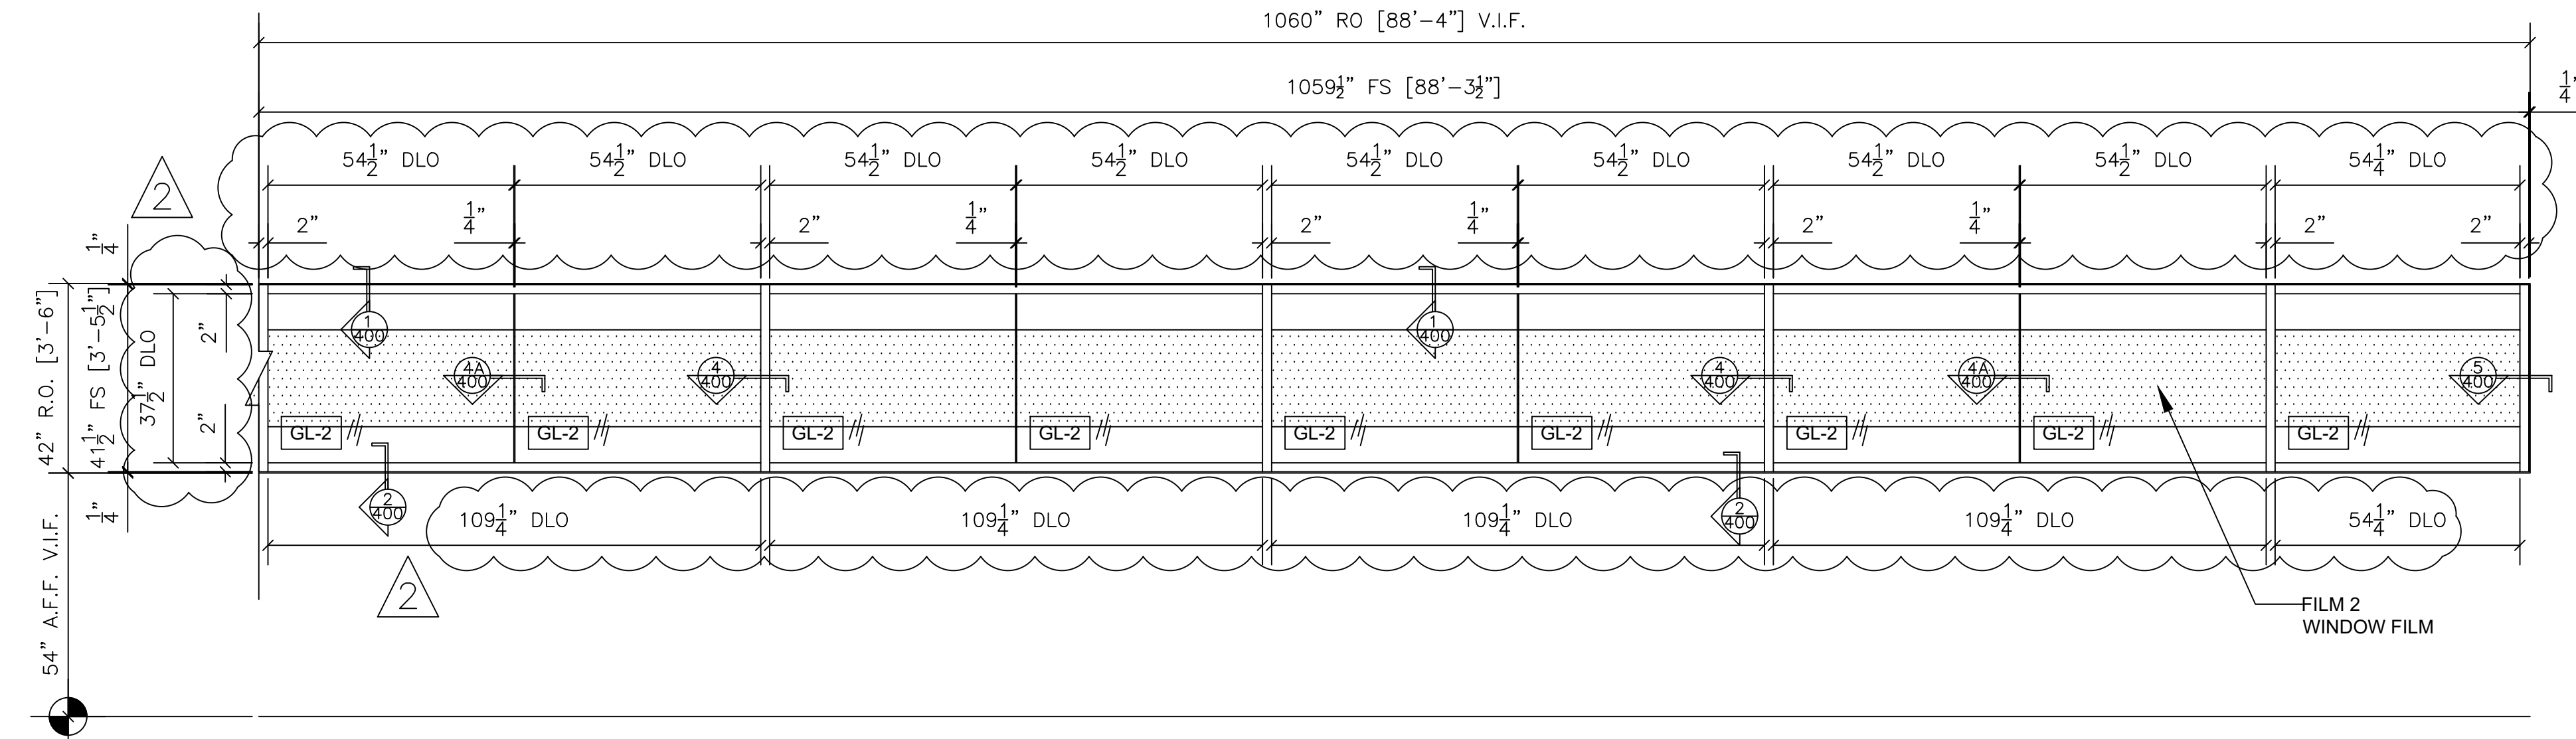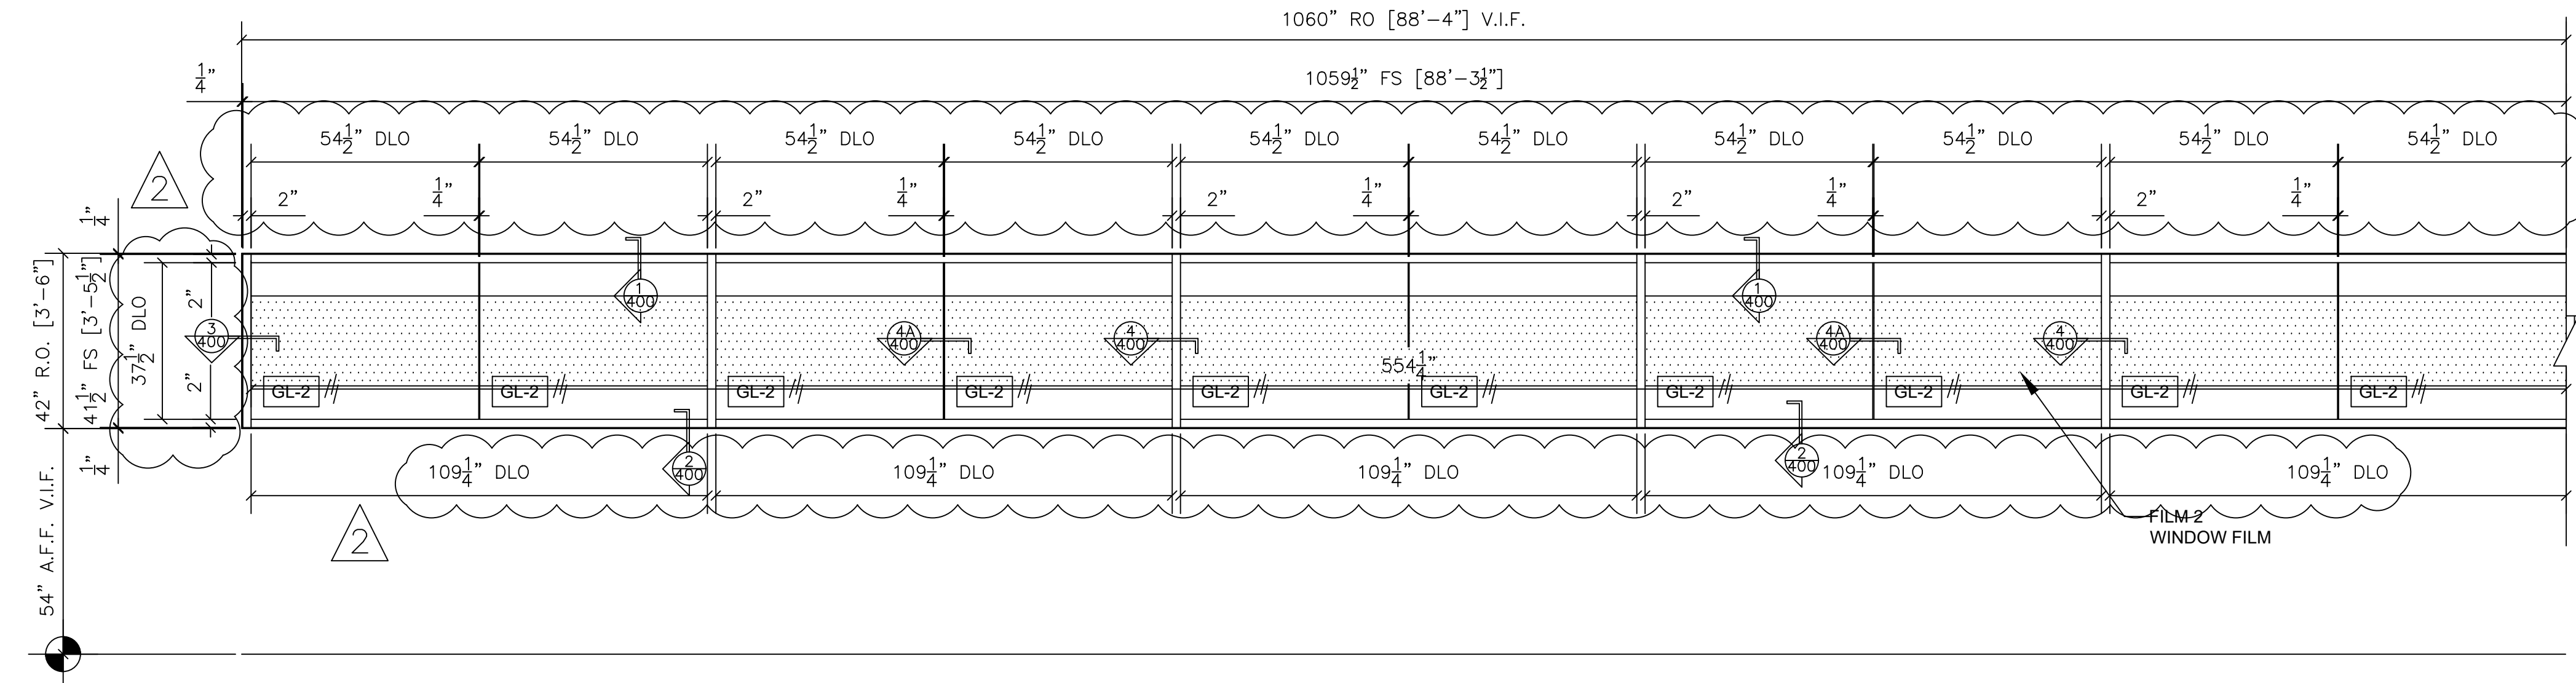

8 WINDOW FRAMING ELEVATION
TUBELITE E14000
INTERIOR STOREFRONT
ARCH. REF.: SIM. 4/A3.31

QTY	LOCATION
1	SOUTH ARTERY 155

1 TOTAL

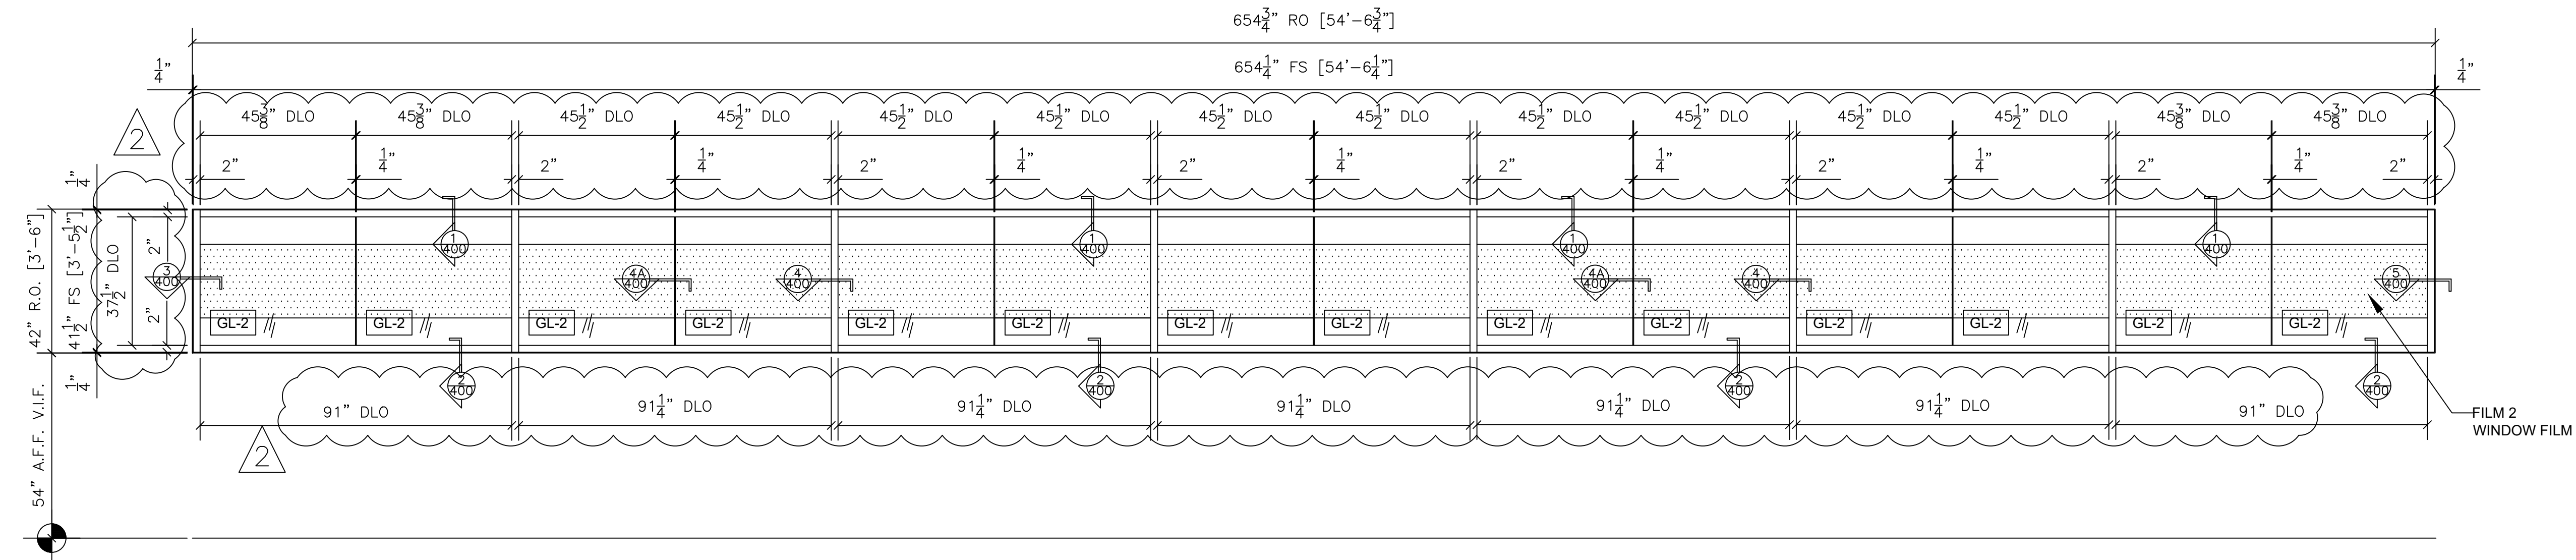

9 WINDOW FRAMING ELEVATION
TUBELITE E14000
INTERIOR STOREFRONT
ARCH. REF.: SIM. 4/A3.31

QTY	LOCATION
1	NORTH ARTERY 123

1 TOTAL

NO.	REVISION/ISSUED	DATE
1	1ST SUBMITTAL	12/23/19
2	1ST REVISION	2/19/2020

PROJECT NAME & LOCATION:	FDA	
	10749 WEST 84TH TERRACE LENEXA, KANSAS 66214	
SHEET TITLE:		FRAMING ELEVATION


DRAFTSMAN:
KS DRAFTING & DESIGN, LLC. KYLE SCHNECK HARRISBURG, PA 17110 KYLE@KSDRAFTINGDESIGNLLC.COM 717-228-7114 KSDRAFTINGDESIGNLLC.COM

ARCHITECT:

GLAZING CONTRACTOR:

DRAWN BY:	KEVIN VERGARA
CHECKED BY:	KYLE SCHNECK


DATE:	12/23/19	SHEET: 205

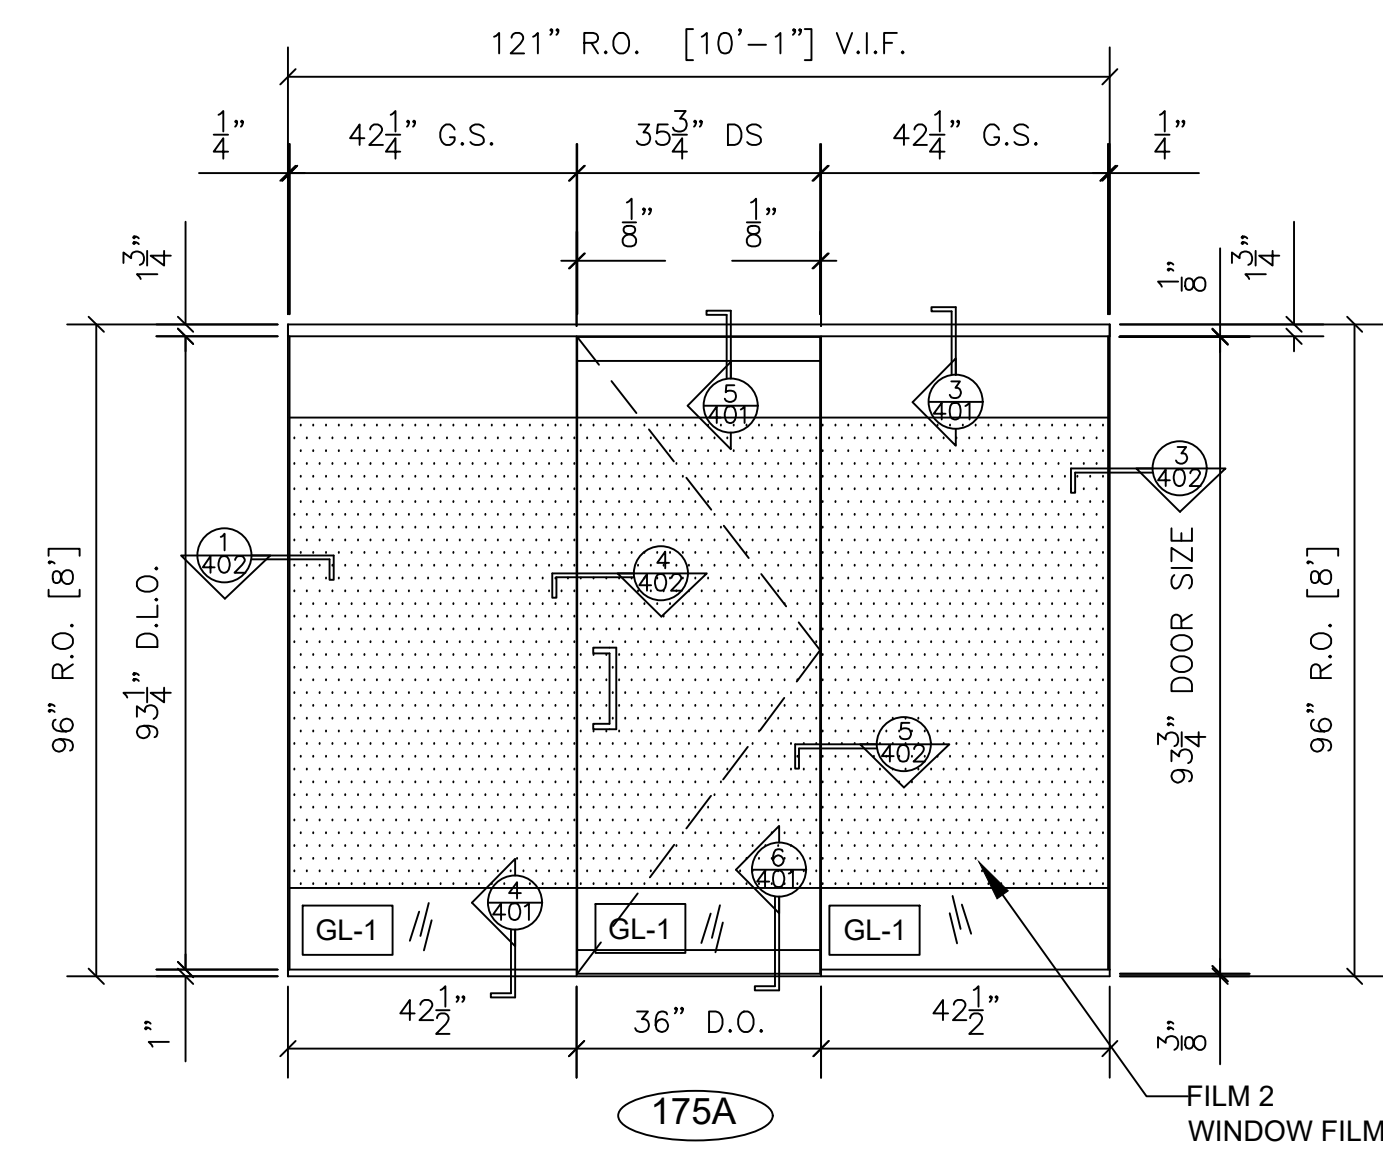

18 SWINGING DOOR SYSTEM FRAME ELEVATION
SWINGING DOOR WITH RAILS AND SIDELITES
ARCH. REF.: 1/A2.01

QTY	LOCATION
1	VESTIBULE 175


1 TOTAL

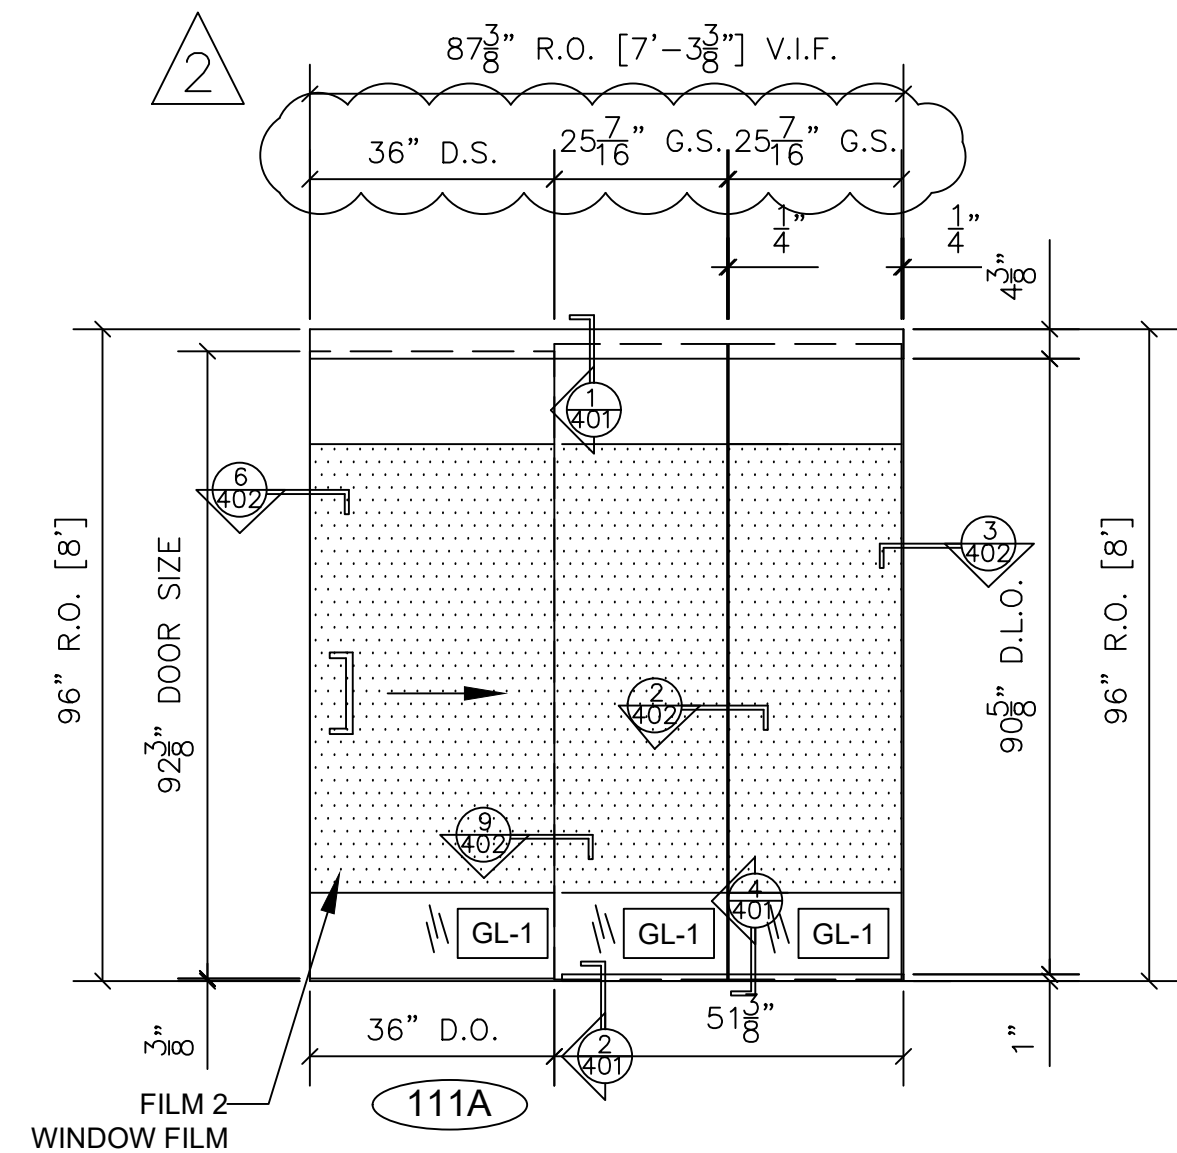

21 SLIDING DOOR SYSTEM FRAME ELEVATION
CRL 70 SLIDING DOOR UNIT
W/ SIDELITES
ARCH. REF.: 1/A2.01

QTY	LOCATION
1	HUDDLE/PHONE ROOM 111


1 TOTAL

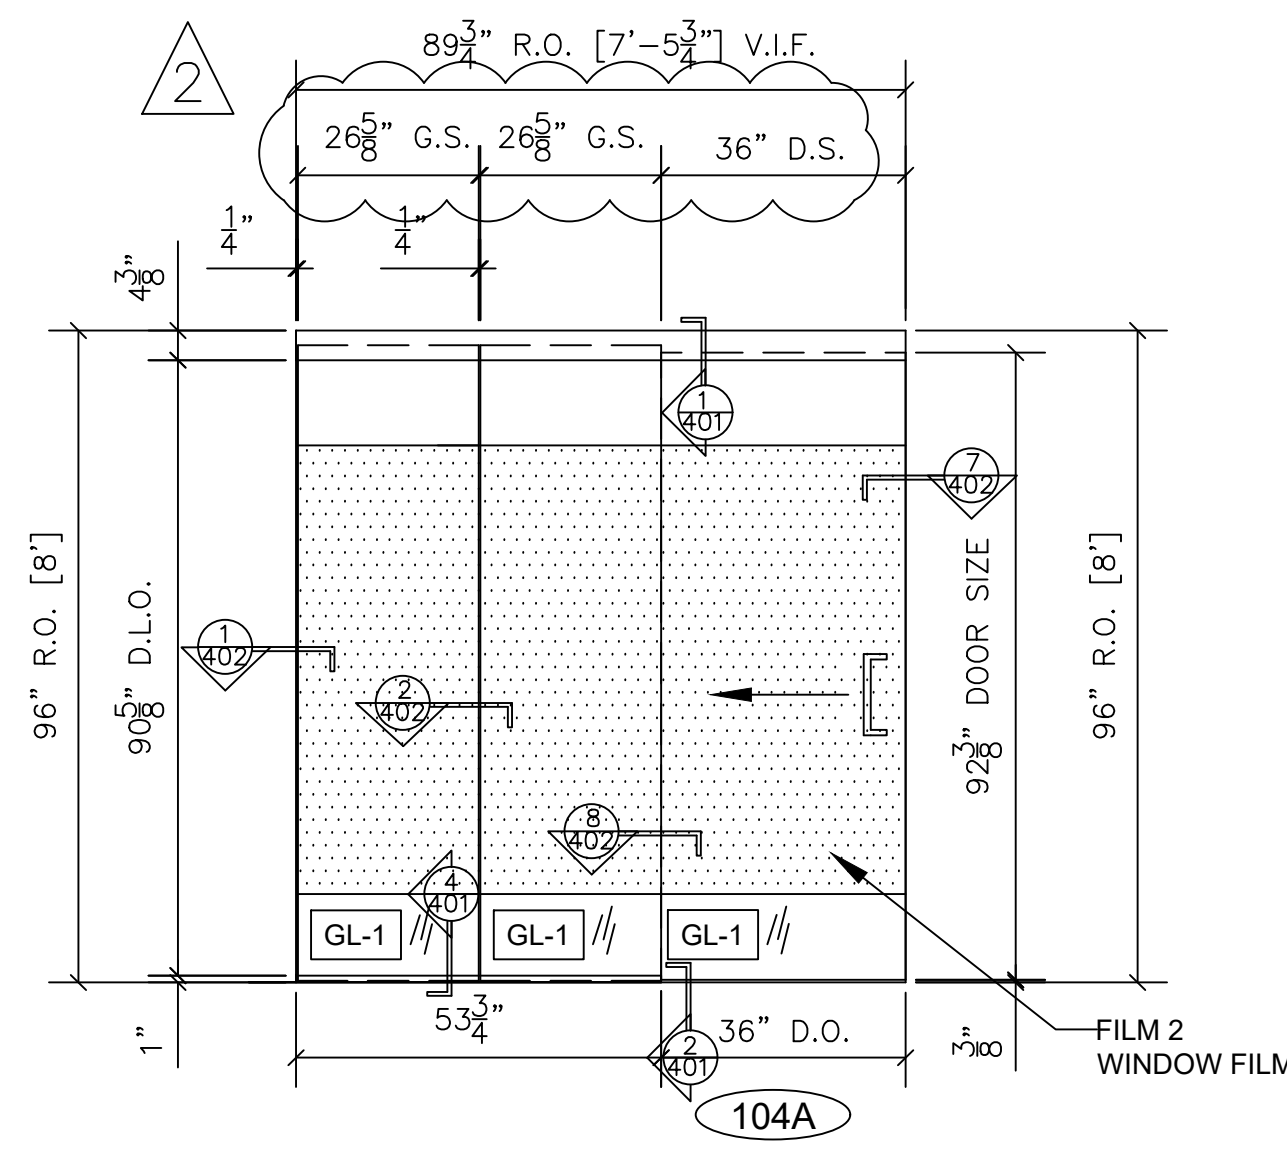

26 SLIDING DOOR SYSTEM FRAME ELEVATION
CRL 70 SLIDING DOOR UNIT
W/ SIDELITES
ARCH. REF.: 1/A2.01

QTY	LOCATION
1	METALS OFFICE 104


1 TOTAL

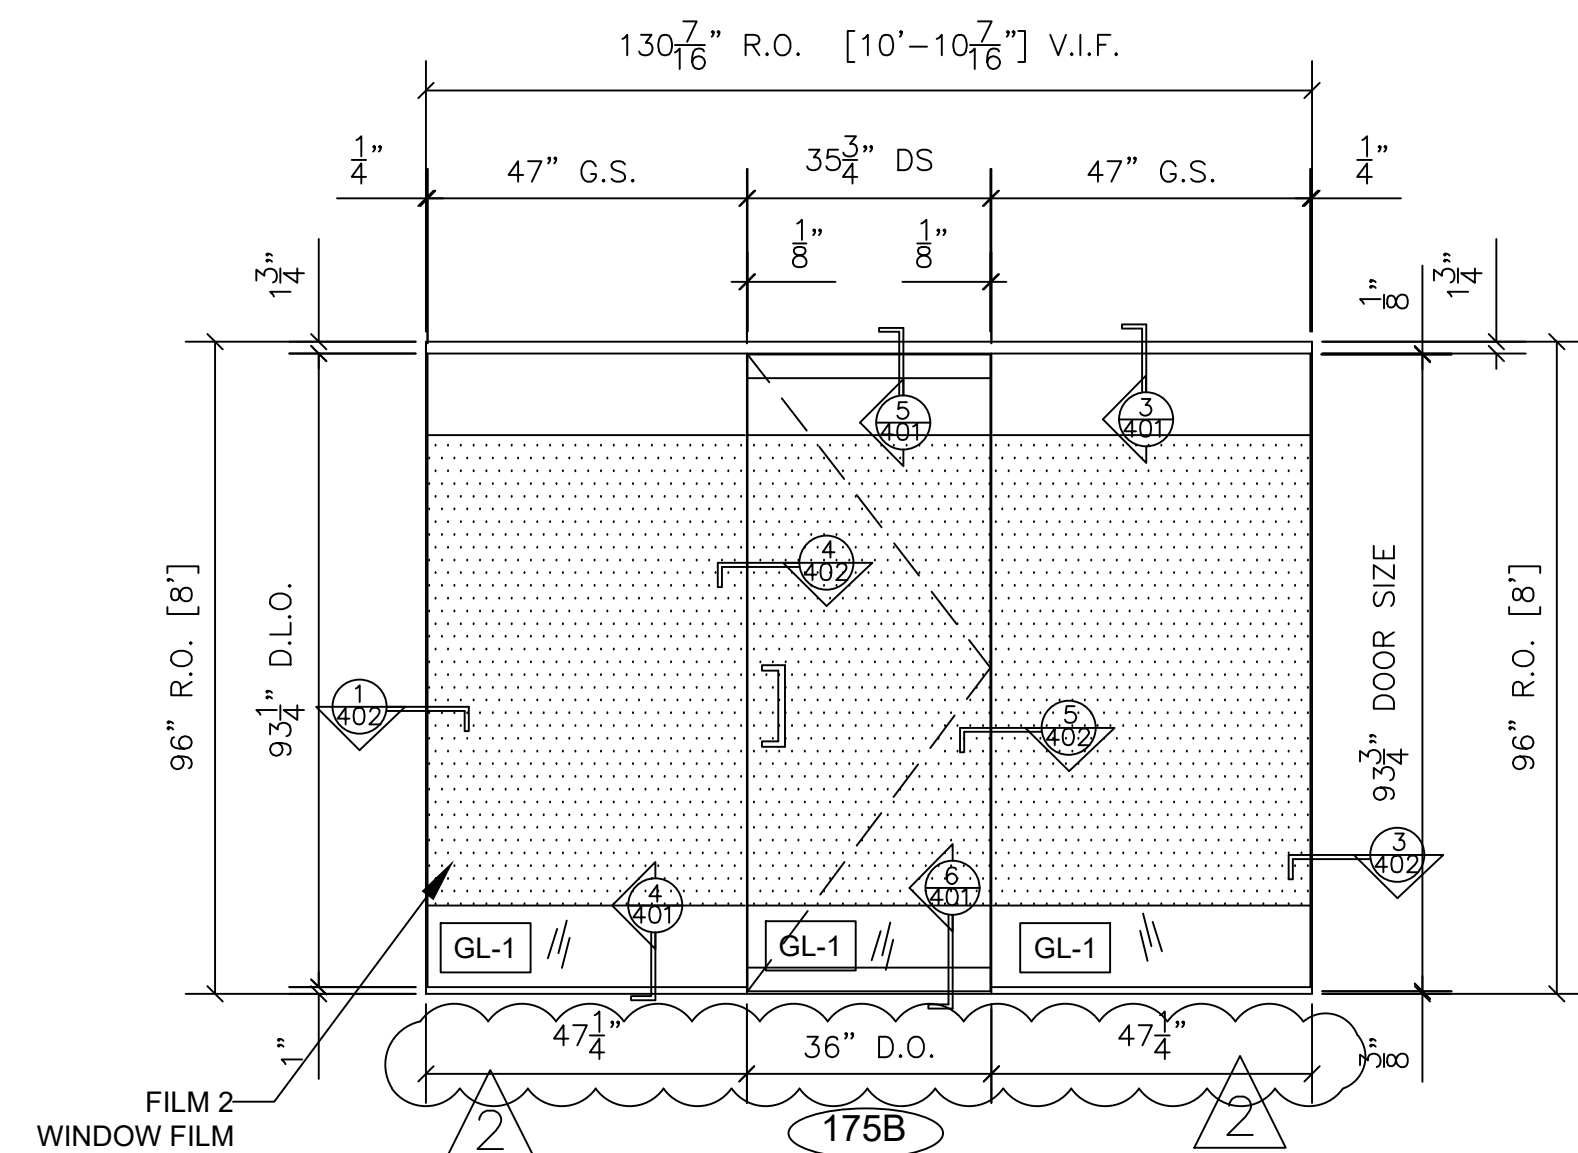

19 SWINGING DOOR SYSTEM FRAME ELEVATION
SWINGING DOOR WITH RAILS AND SIDELITES
ARCH. REF.: 1/A2.01

QTY	LOCATION
1	VESTIBULE 175


1 TOTAL

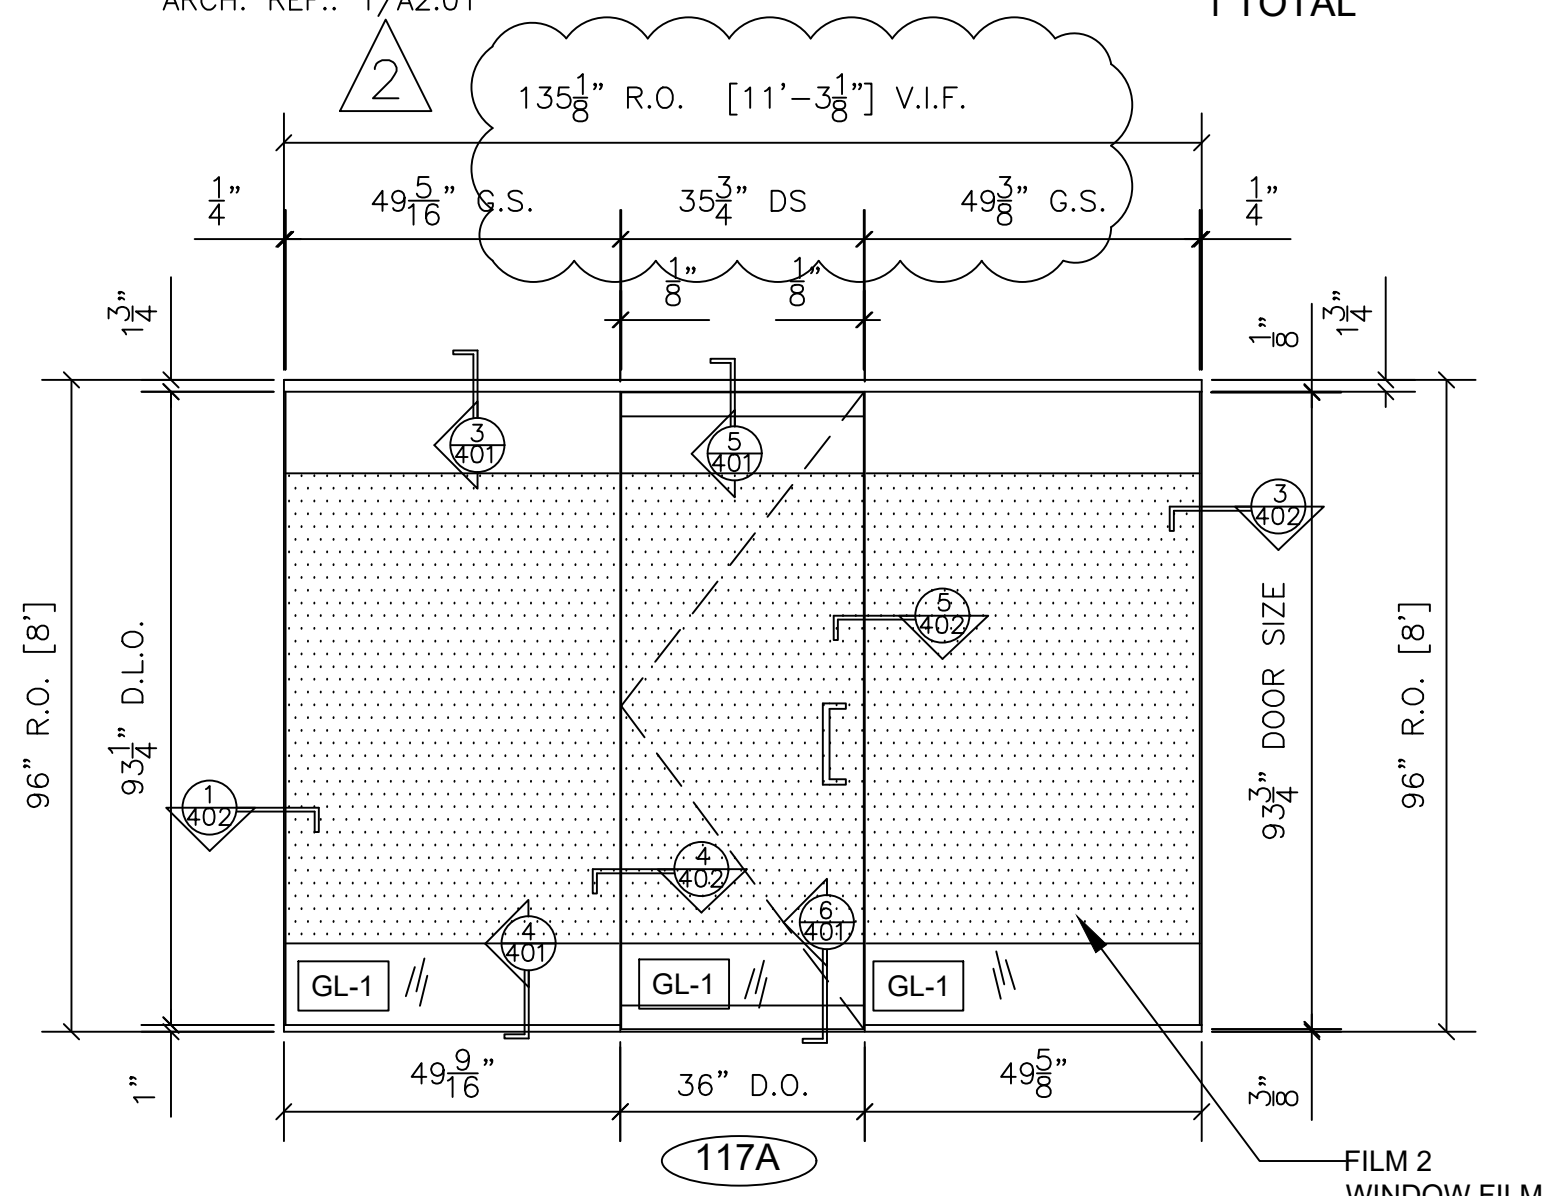

22 SWINGING DOOR SYSTEM FRAME ELEVATION
SWINGING DOOR WITH RAILS AND SIDELITES
ARCH. REF.: 1/A2.01

QTY	LOCATION
2	VESTIBULE 117


2 TOTAL

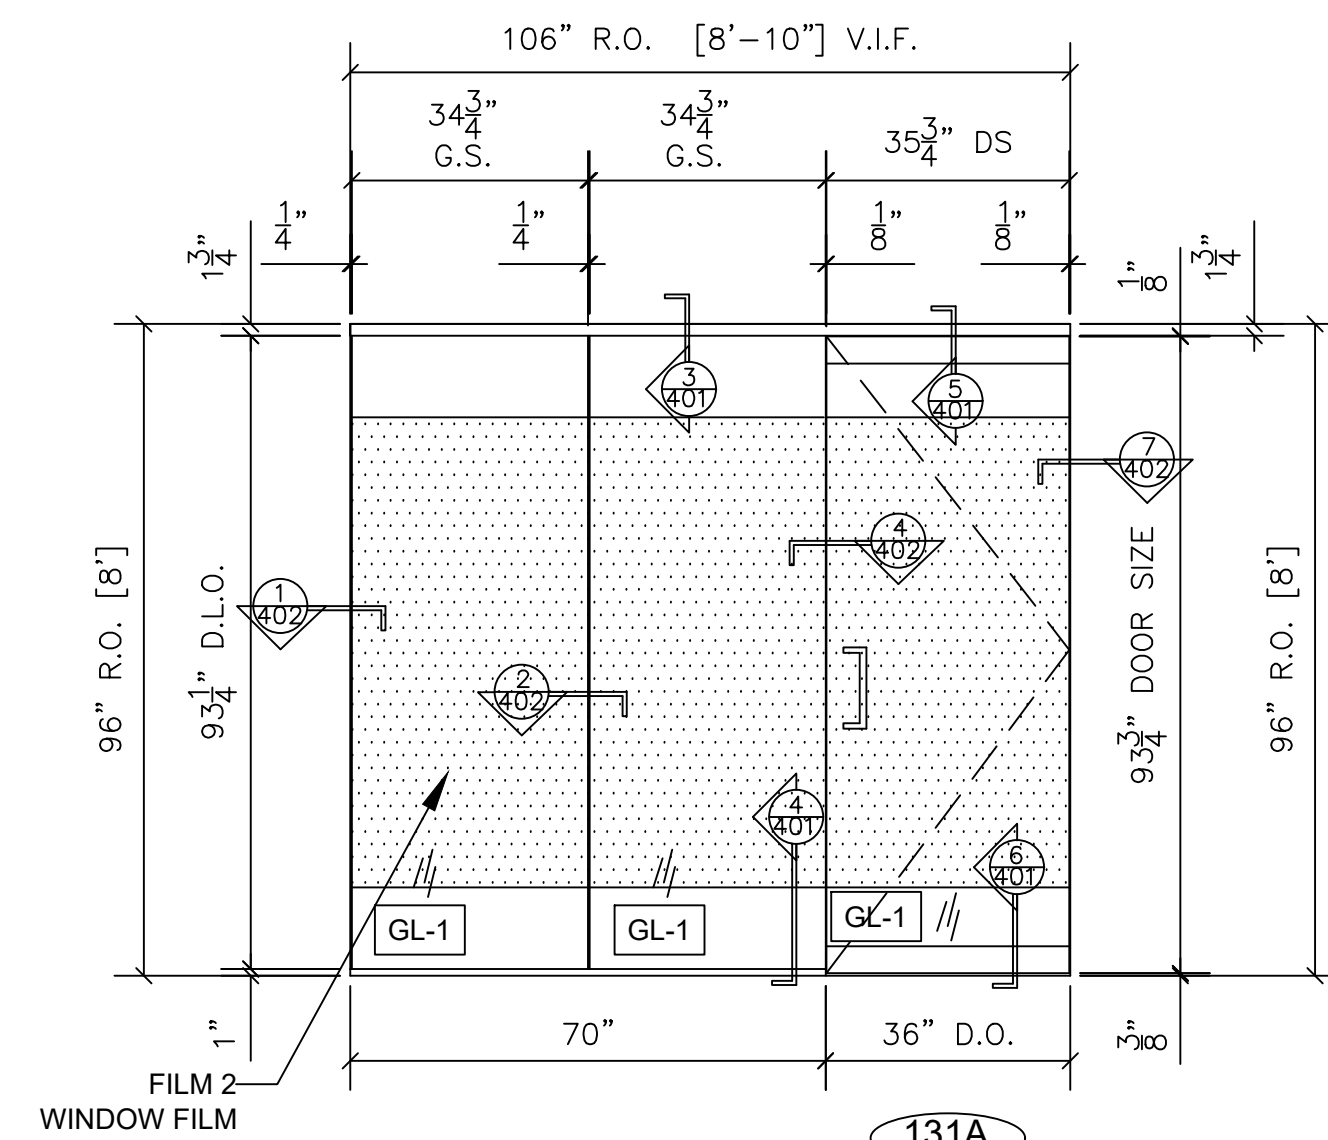

25 SWINGING DOOR SYSTEM FRAME ELEVATION
SWINGING DOOR WITH RAILS AND SIDELITE
ARCH. REF.: 1/A2.01

QTY	LOCATION
1	FACILITY OFFICE 131


1 TOTAL

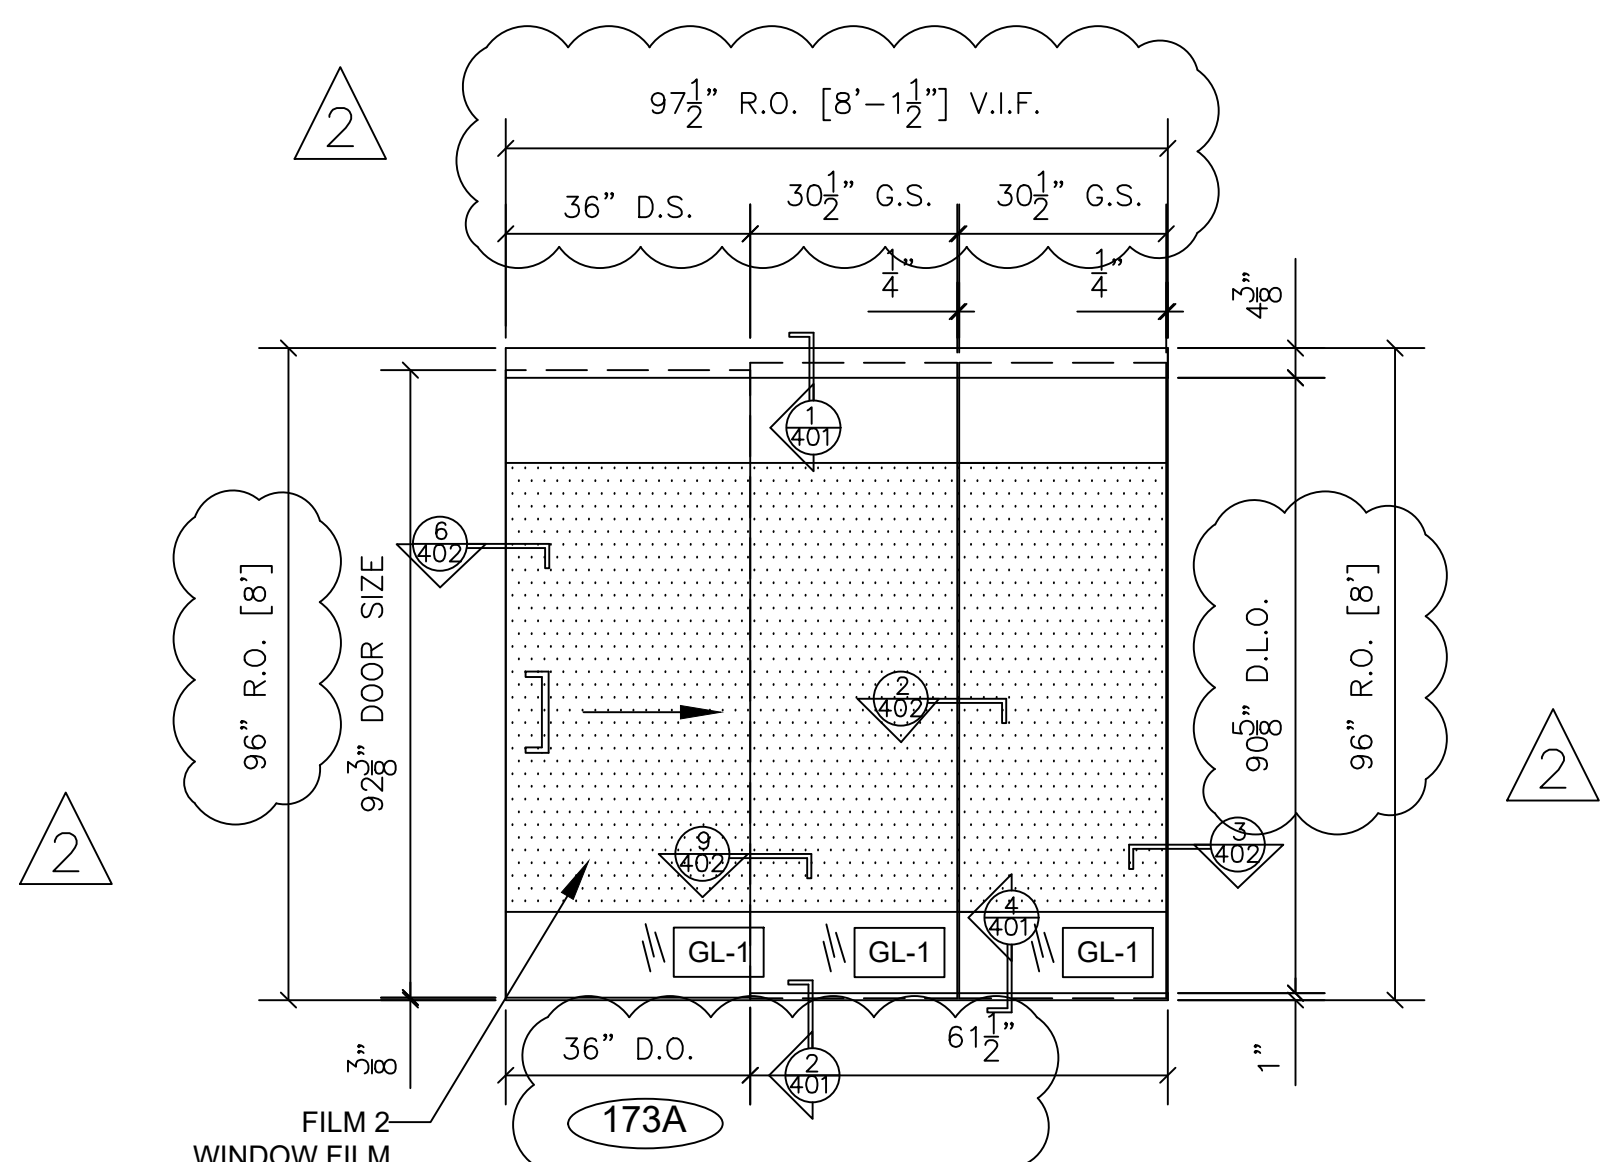

20 SLIDING DOOR SYSTEM FRAME ELEVATION
CRL 70 SLIDING DOOR UNIT
W/ SIDELITES
ARCH. REF.: 1/A2.01

QTY	LOCATION
1	HUDDLE/PHONE ROOM 173


1 TOTAL

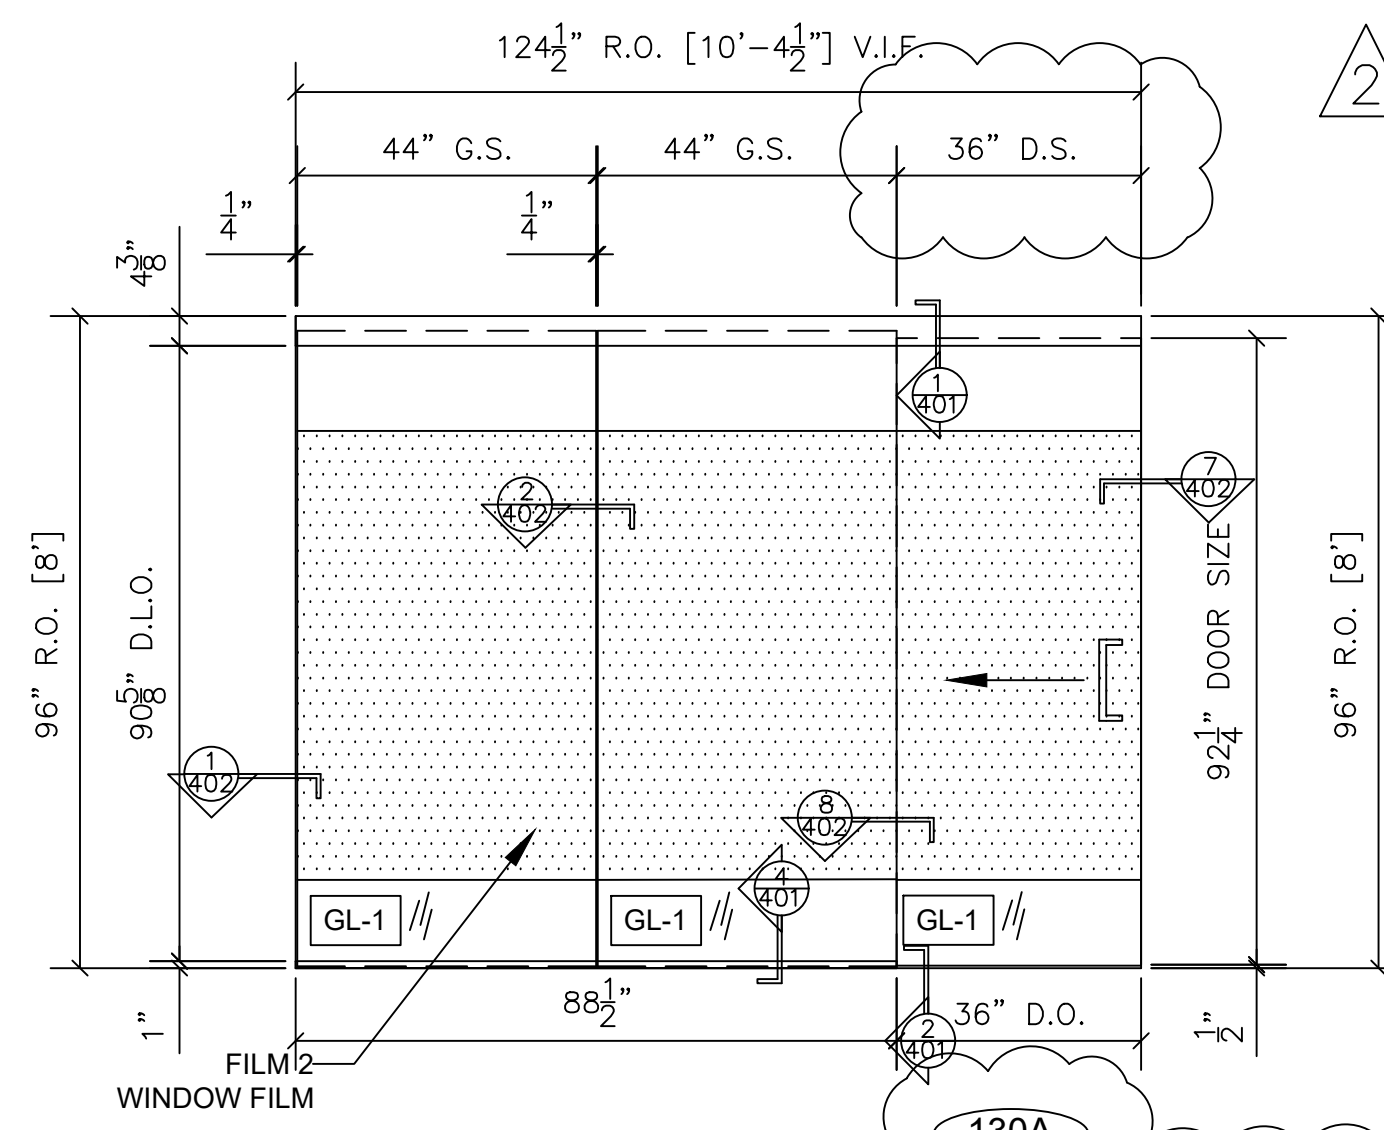

23 SLIDING DOOR SYSTEM FRAME ELEVATION
CRL 70 SLIDING DOOR UNIT
W/ SIDELITES
ARCH. REF.: 1/A2.01

QTY	LOCATION
1	API DIETARY SUPP 130

1 TOTAL

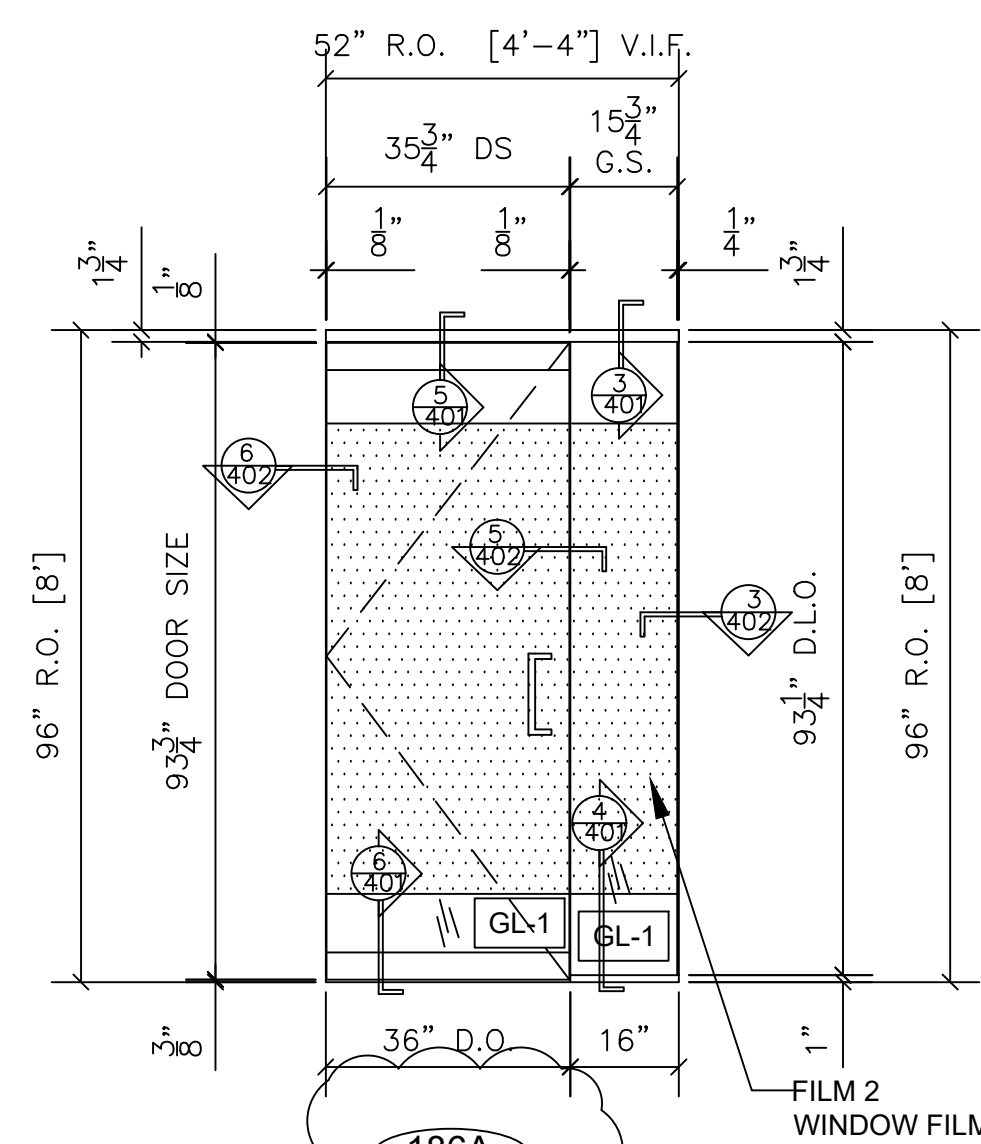

24 SWINGING DOOR SYSTEM FRAME ELEVATION
SWINGING DOOR WITH RAILS AND SIDELITE
ARCH. REF.: 1/A2.01

QTY	LOCATION
1	BRAKE ROOM 186

1 TOTAL

NO.	REVISION/ISSUED	DATE
1	1ST SUBMITTAL	12/23/19
2	PER COMMENTS	2/18/20

PROJECT NAME & LOCATION: FDA 10749 WEST 84TH TERRACE LENEXA, KANSAS 66214	SHEET TITLE: FRAMING ELEVATION	












DRAFTSMAN: KS DRAFTING & DESIGN, LLC. KYLE SCHNECK HARRISBURG, PA 17110 KYLE@KSDRAFTINGDESIGNLLC.COM 717-228-7114 KSDRAFTINGDESIGNLLC.COM

ARCHITECT:

GLAZING CONTRACTOR:

DRAWN BY:	KEVIN VERGARA
CHECKED BY:	KYLE SCHNECK

DATE:	12/23/19	SHEET:	208
-------	----------	--------	-----

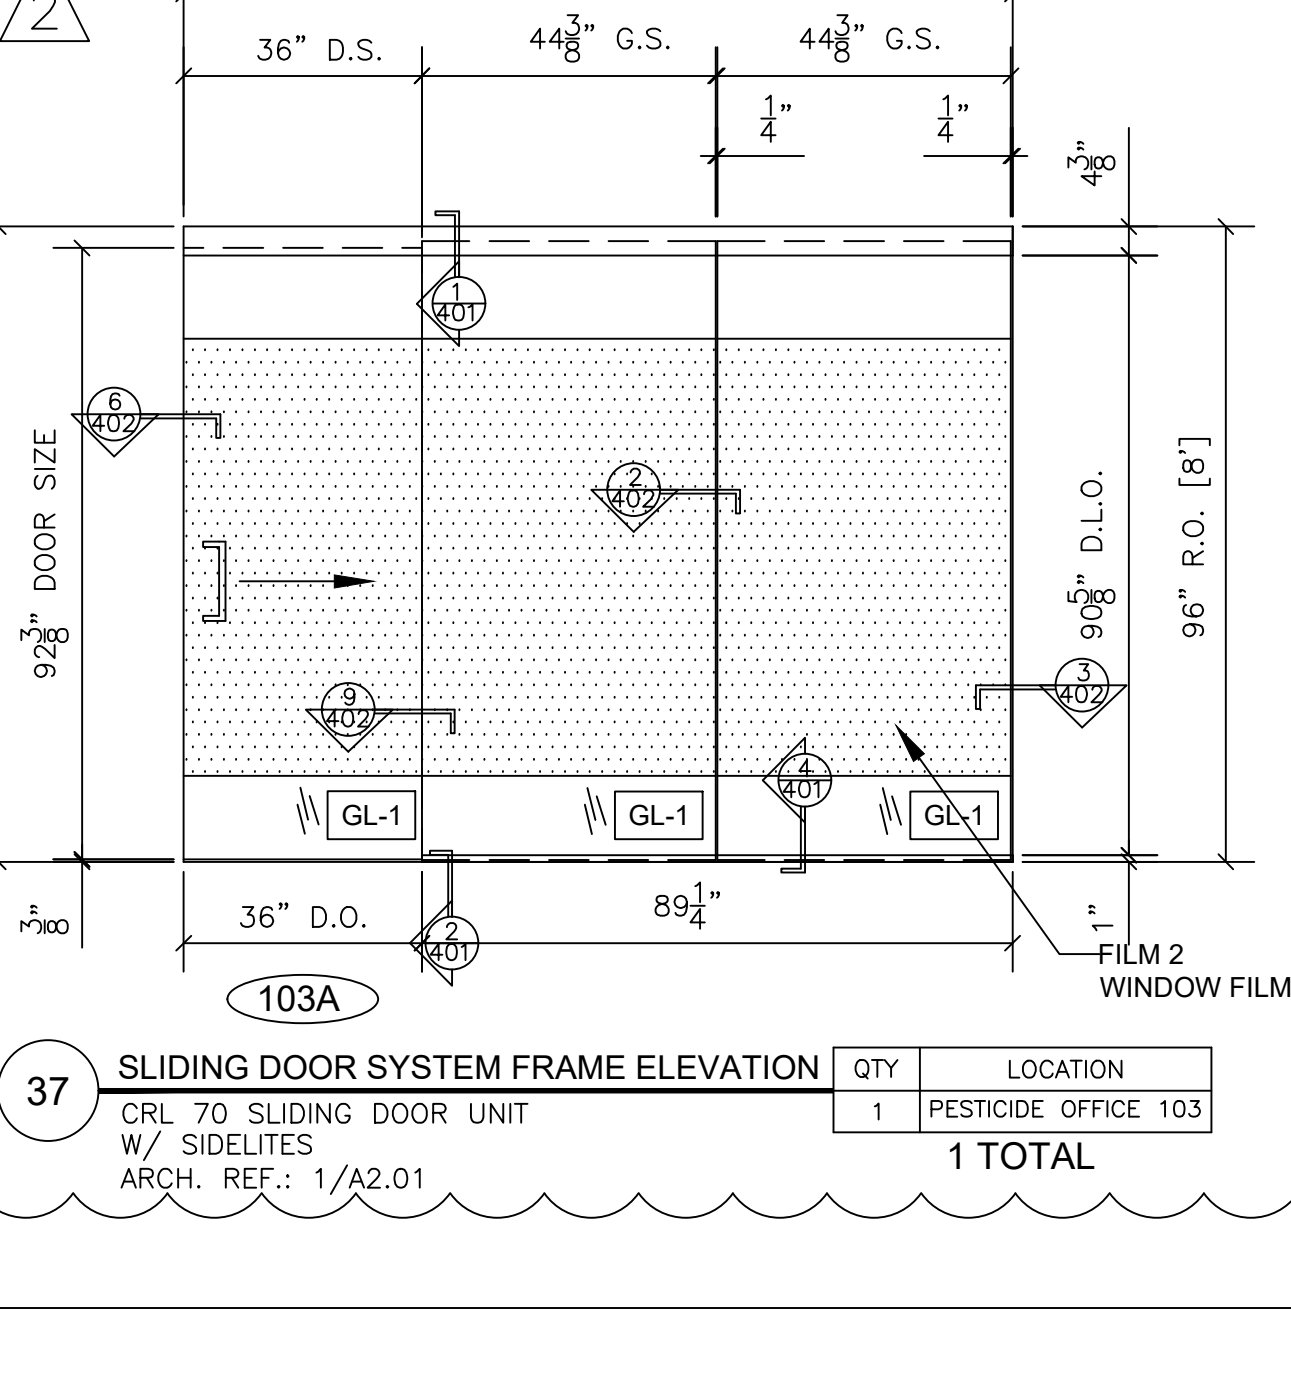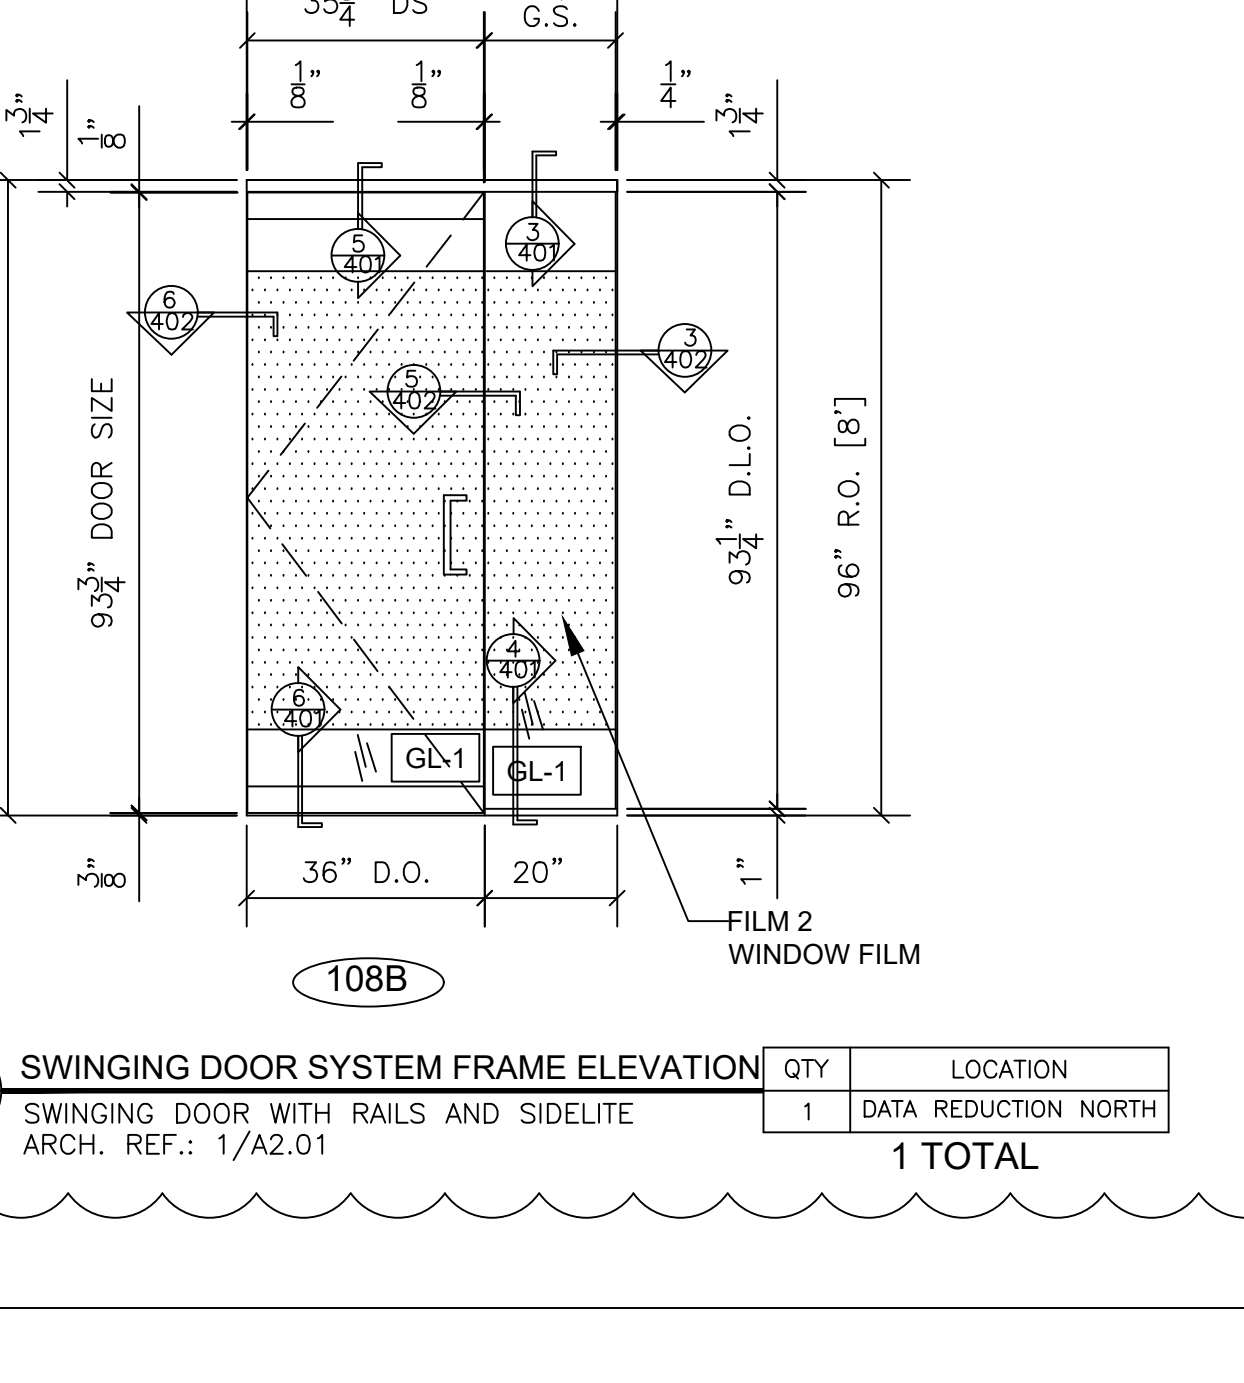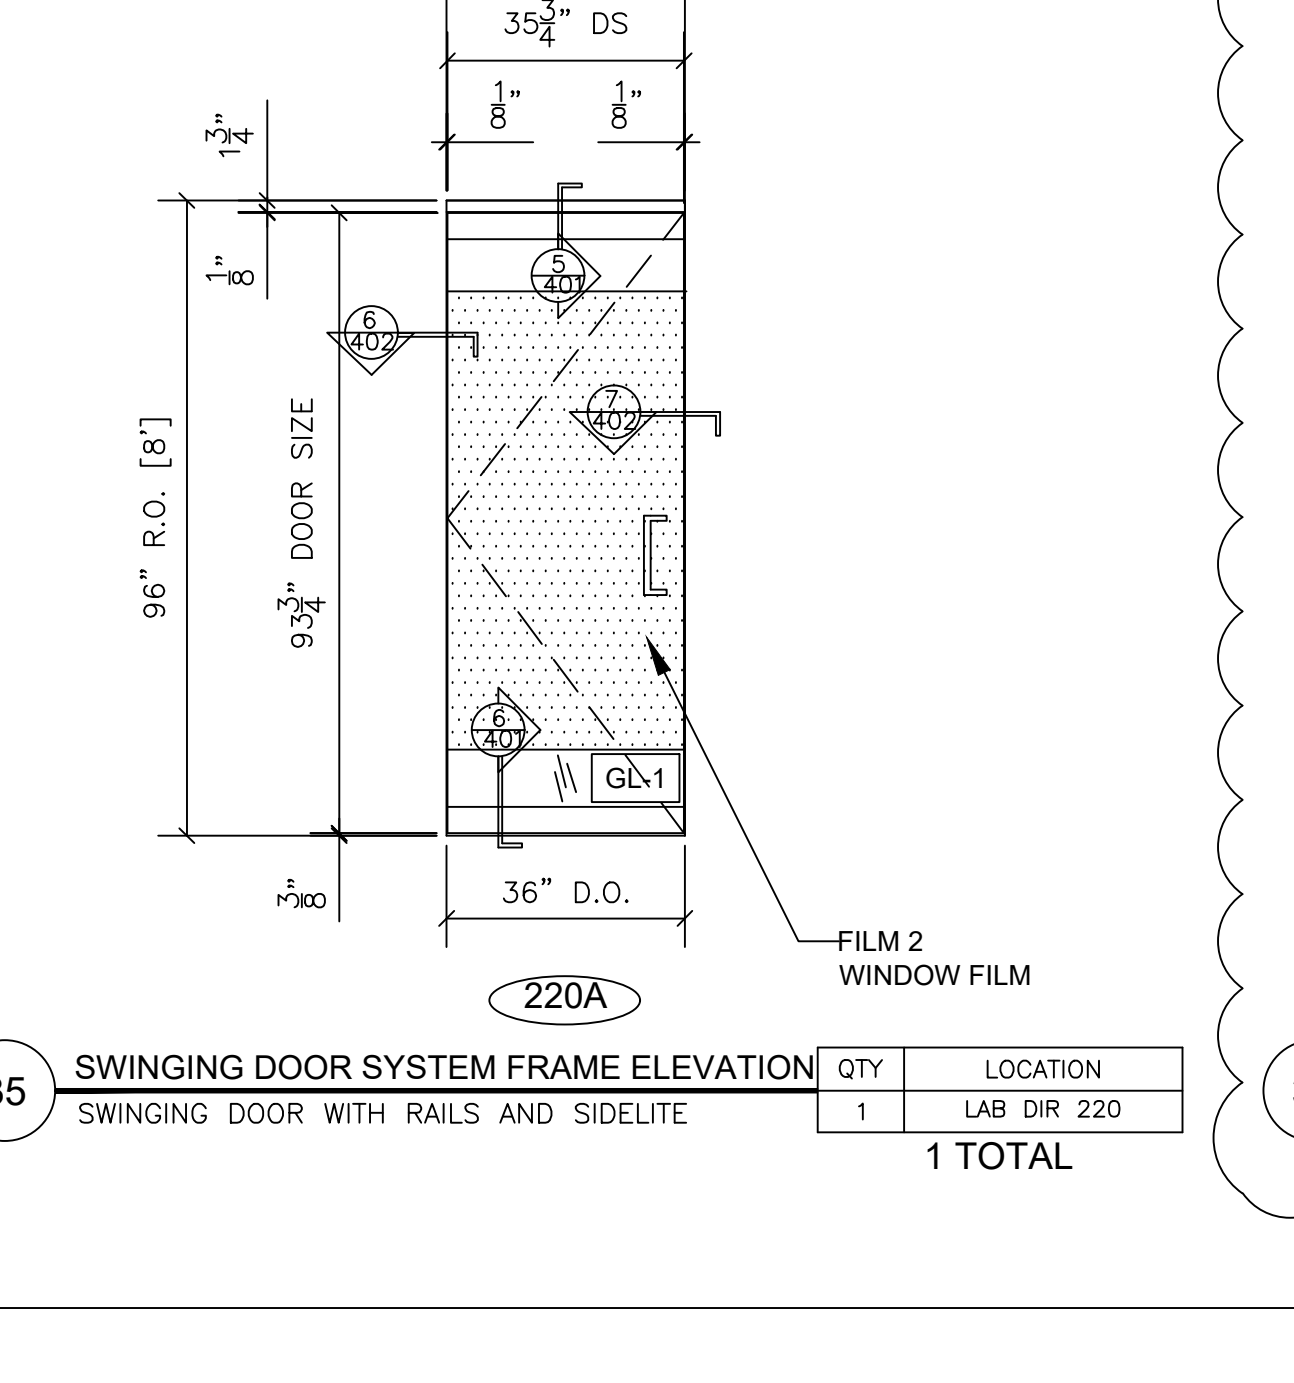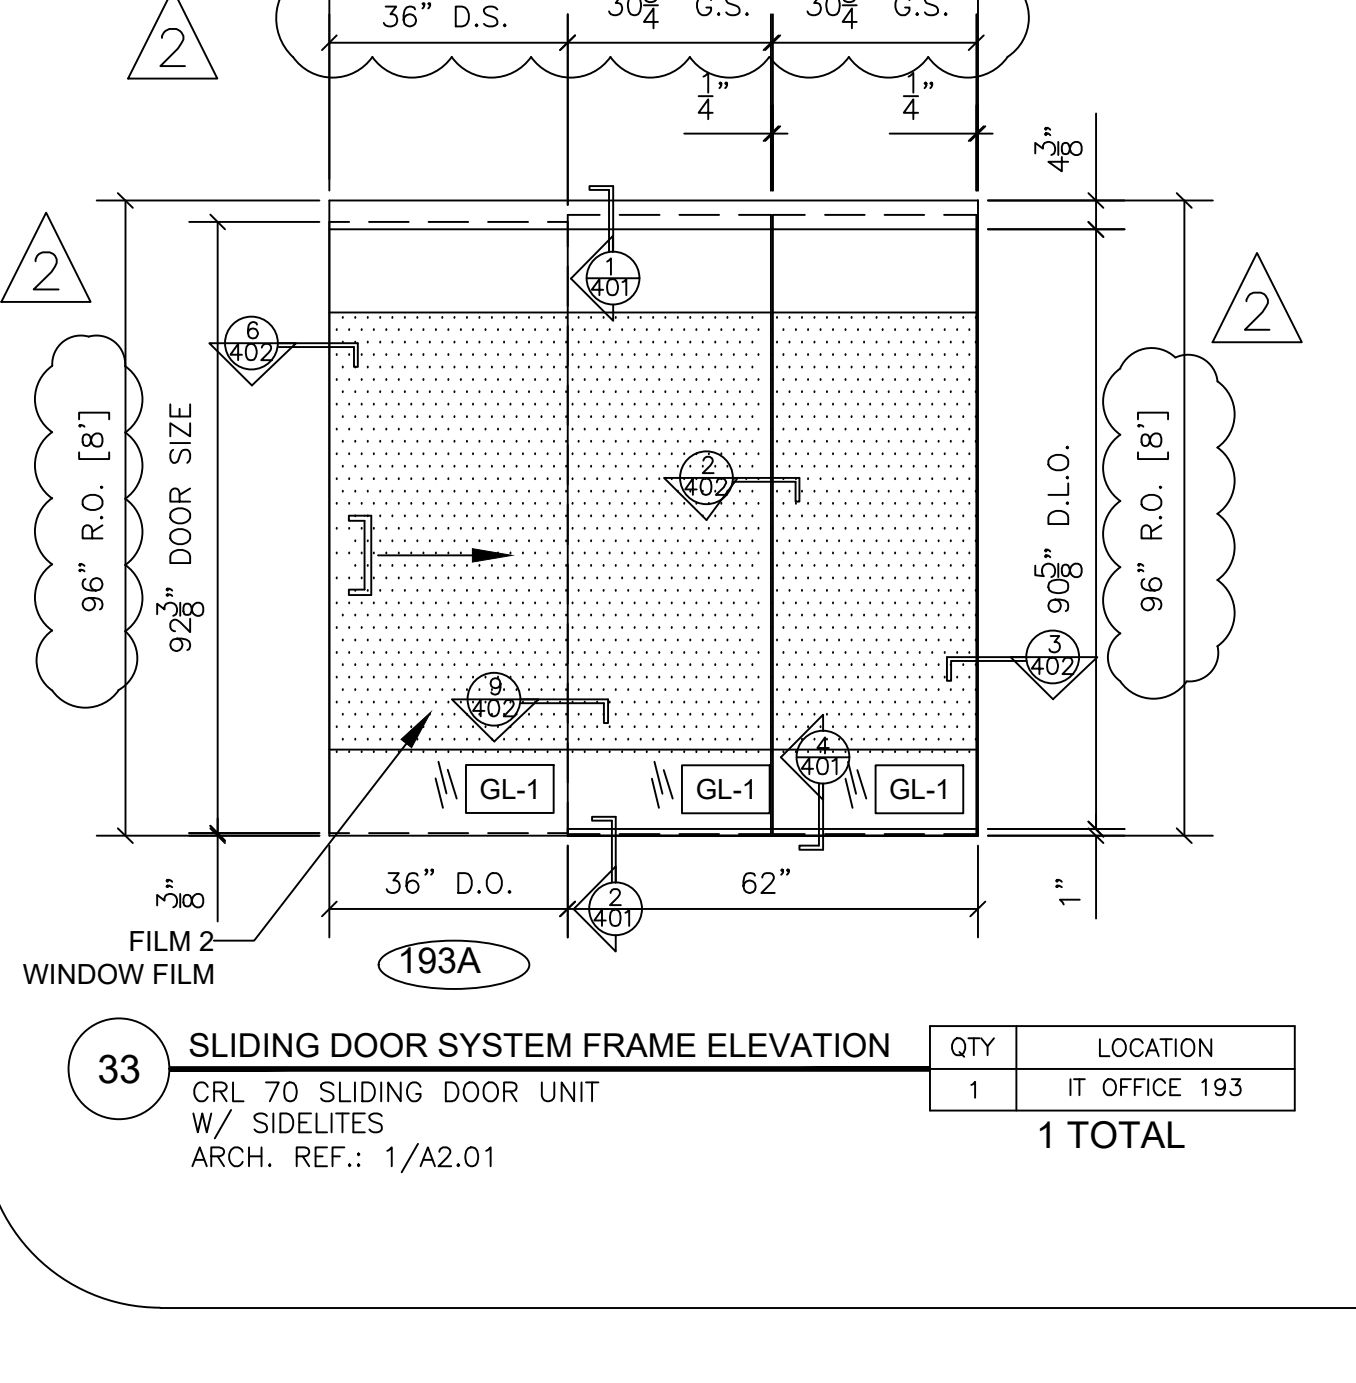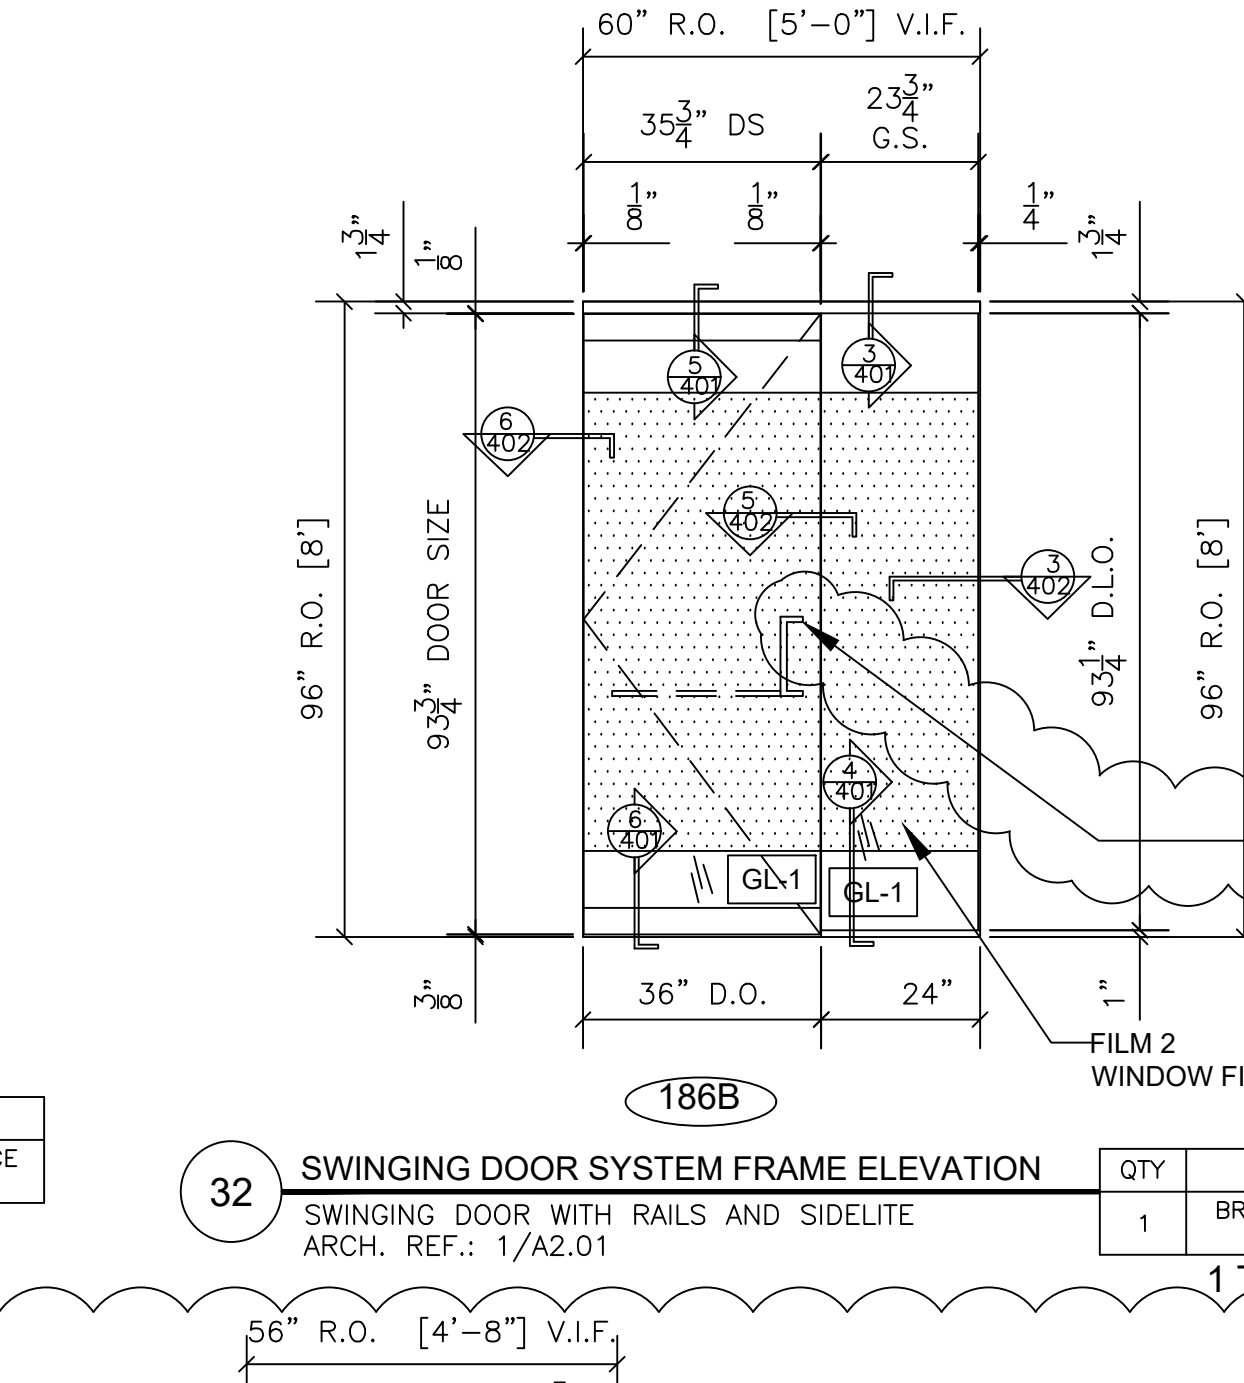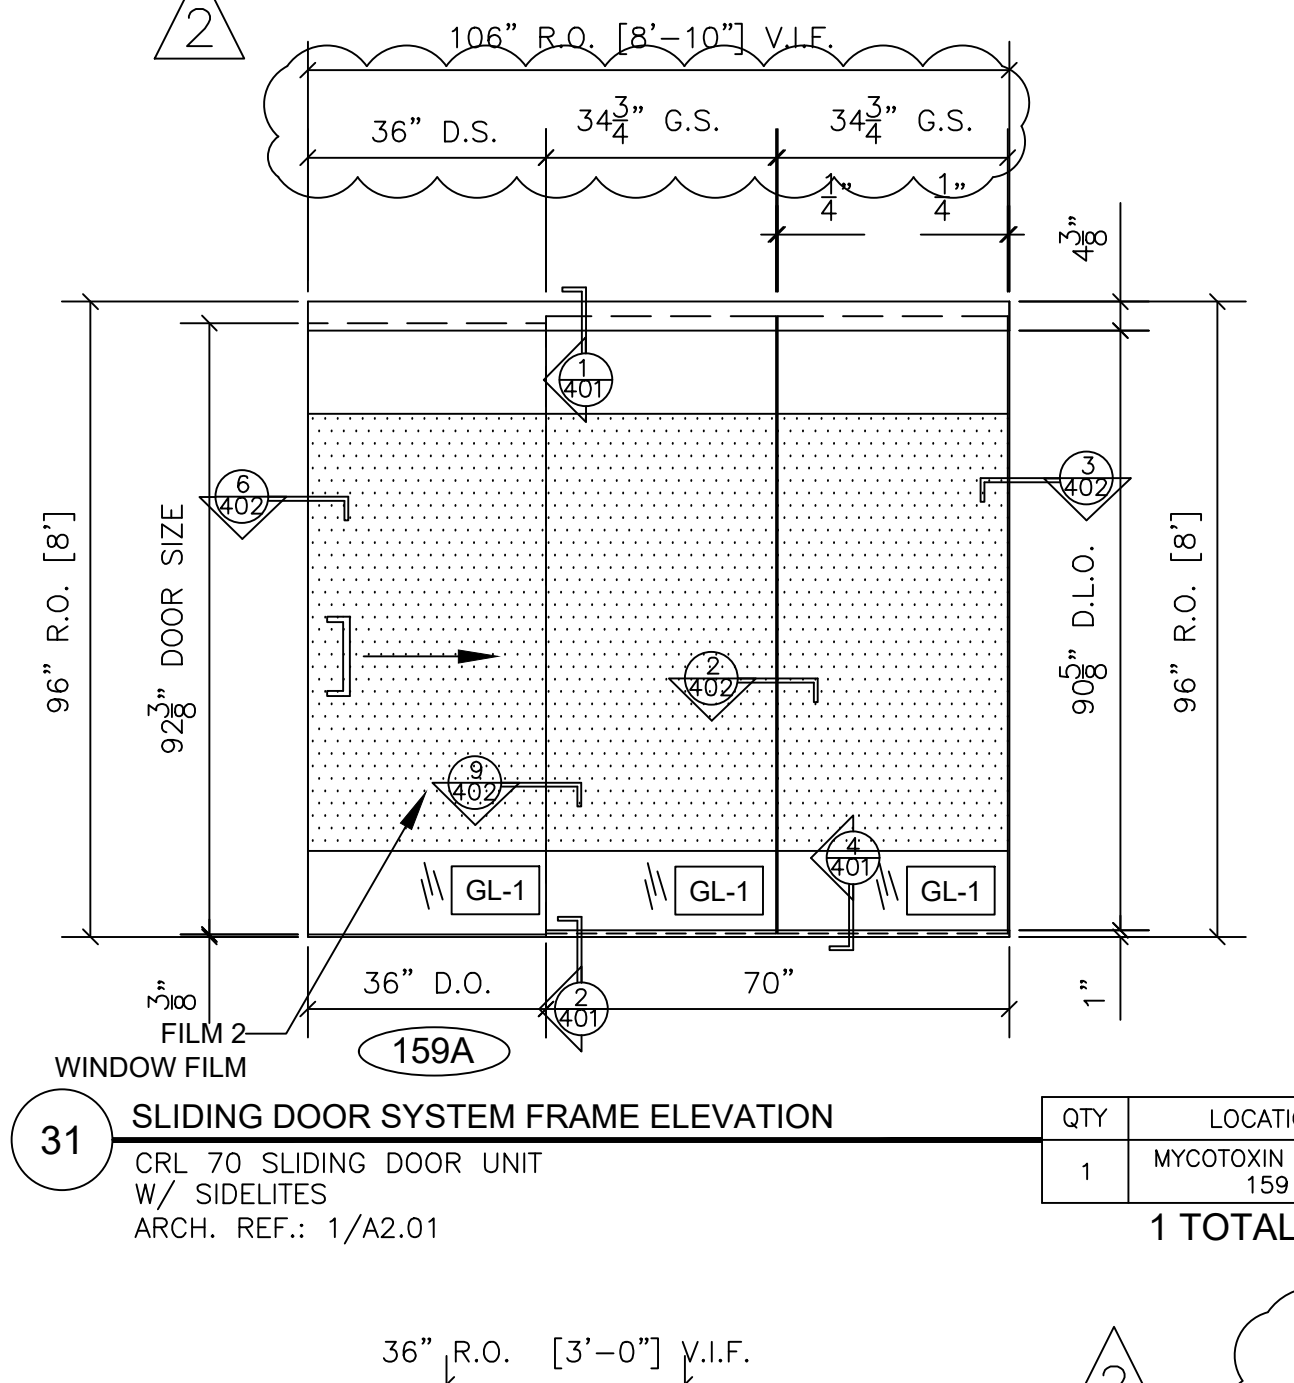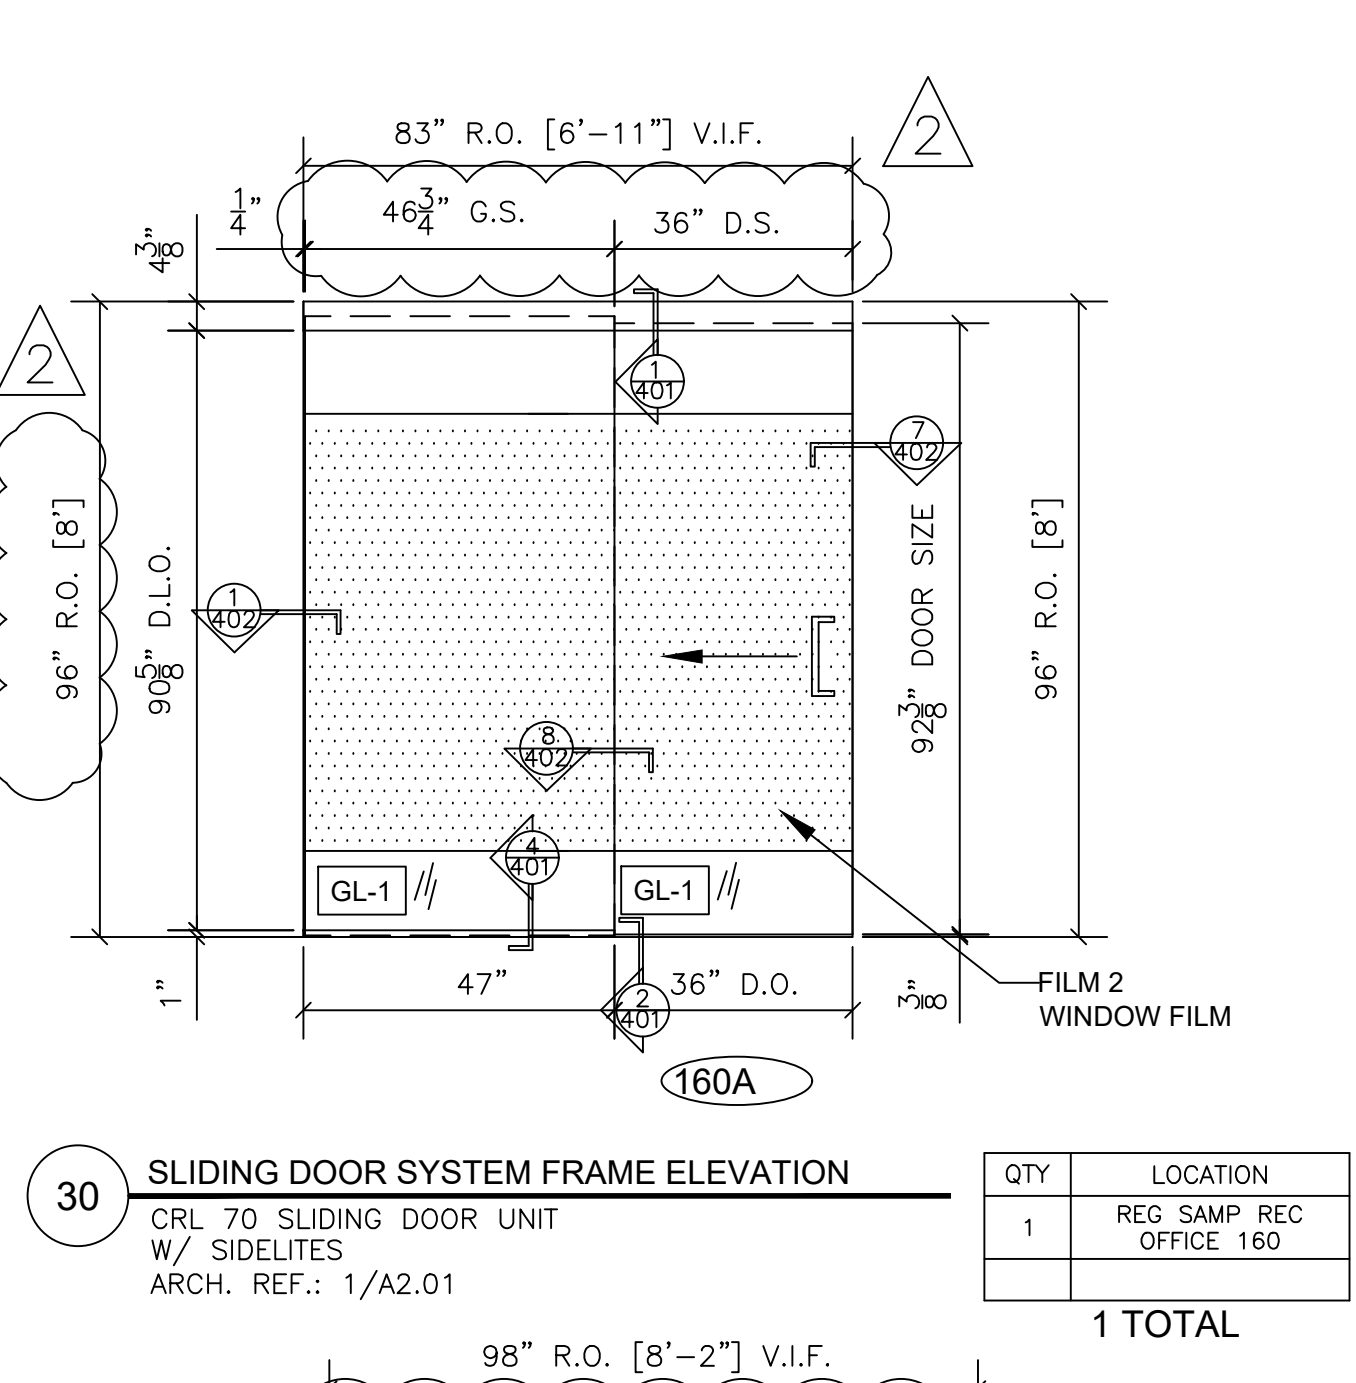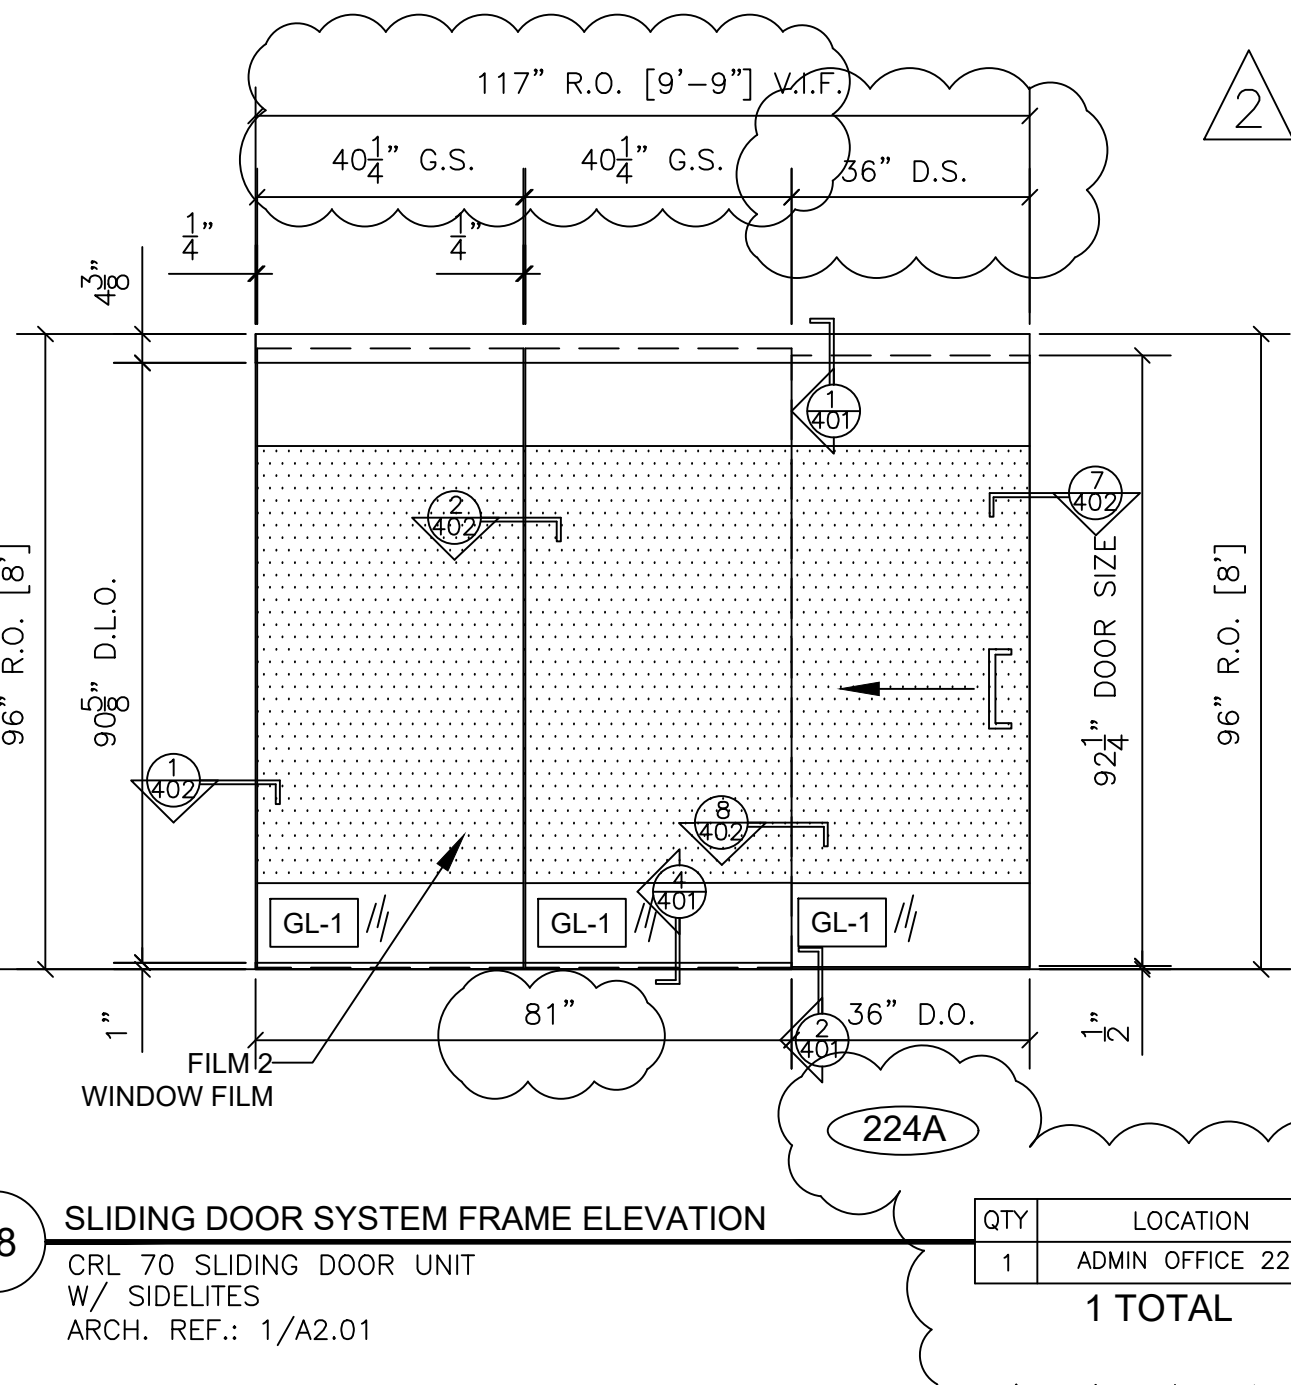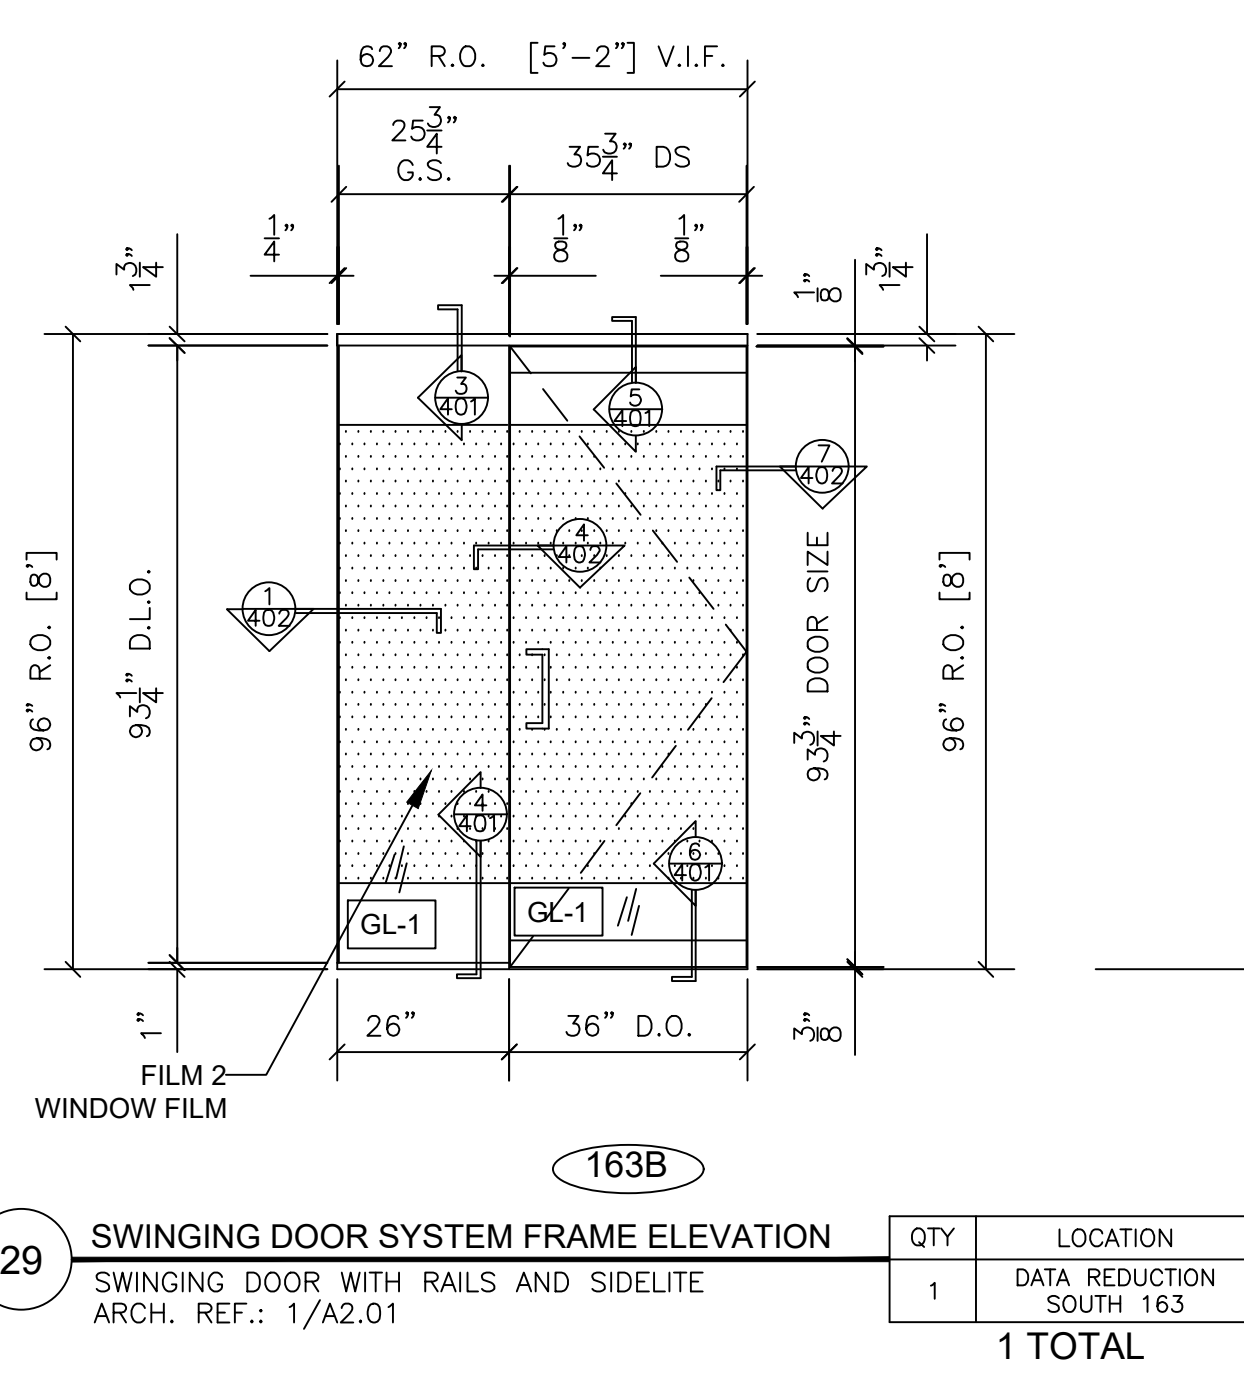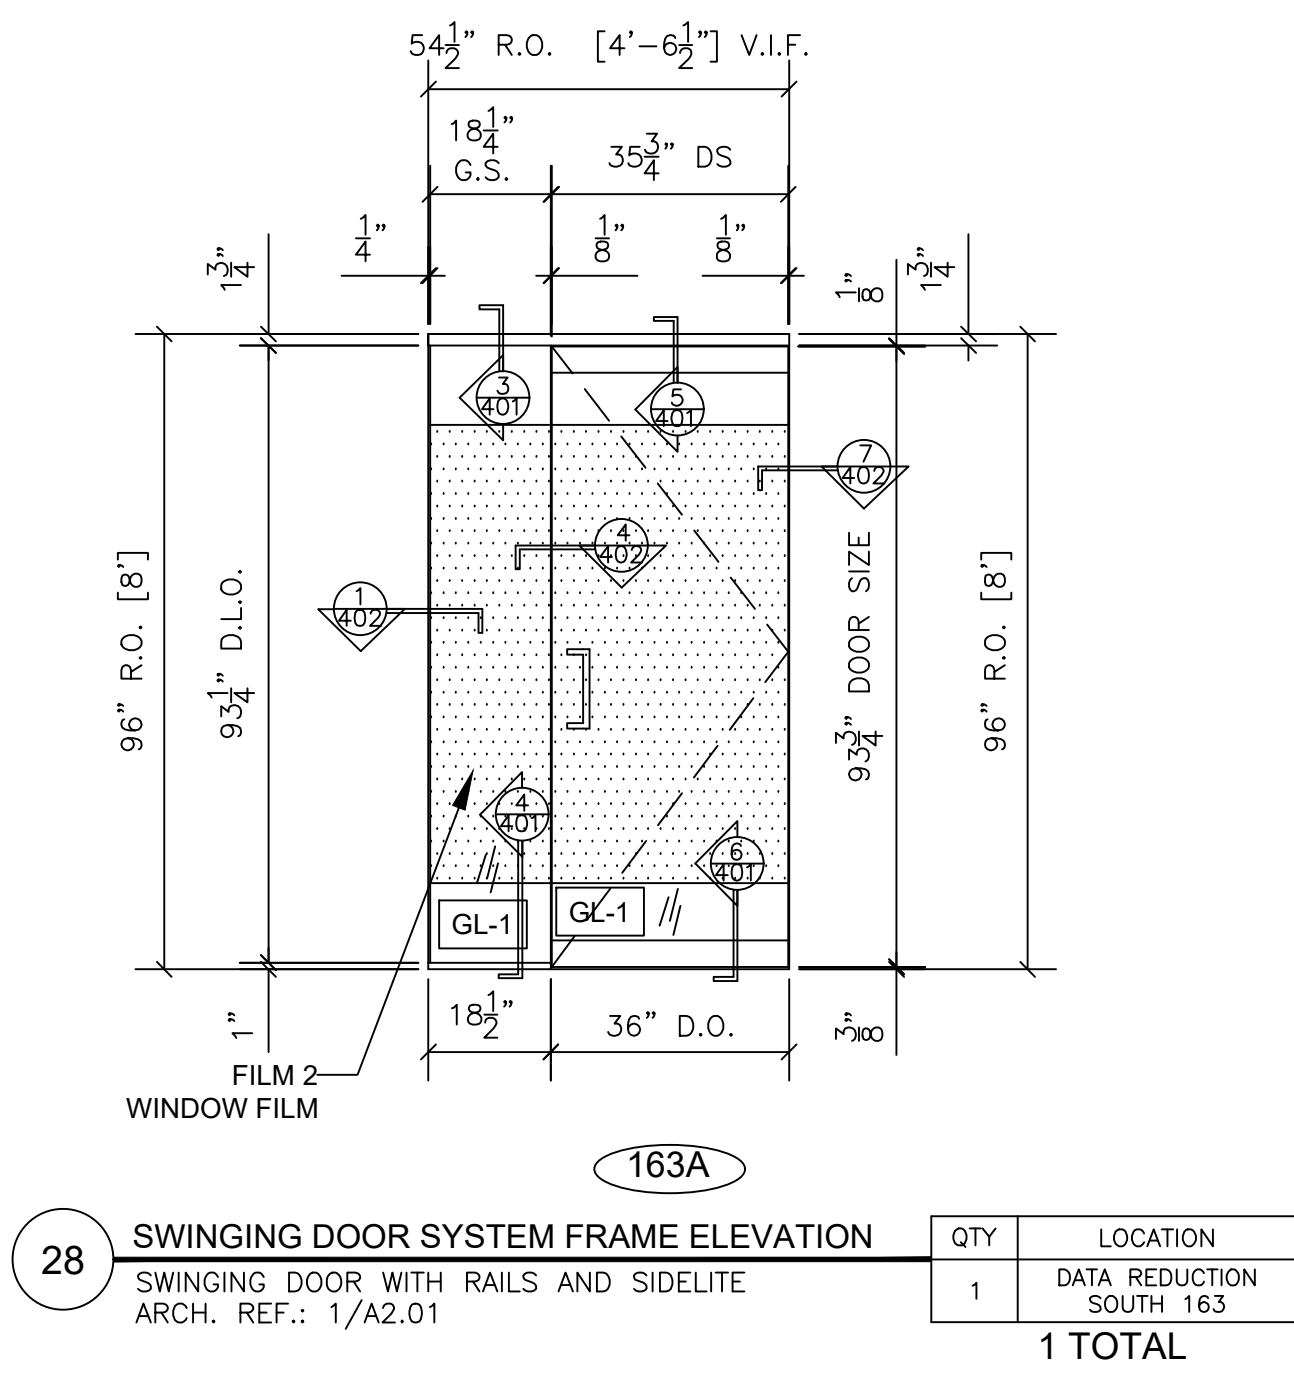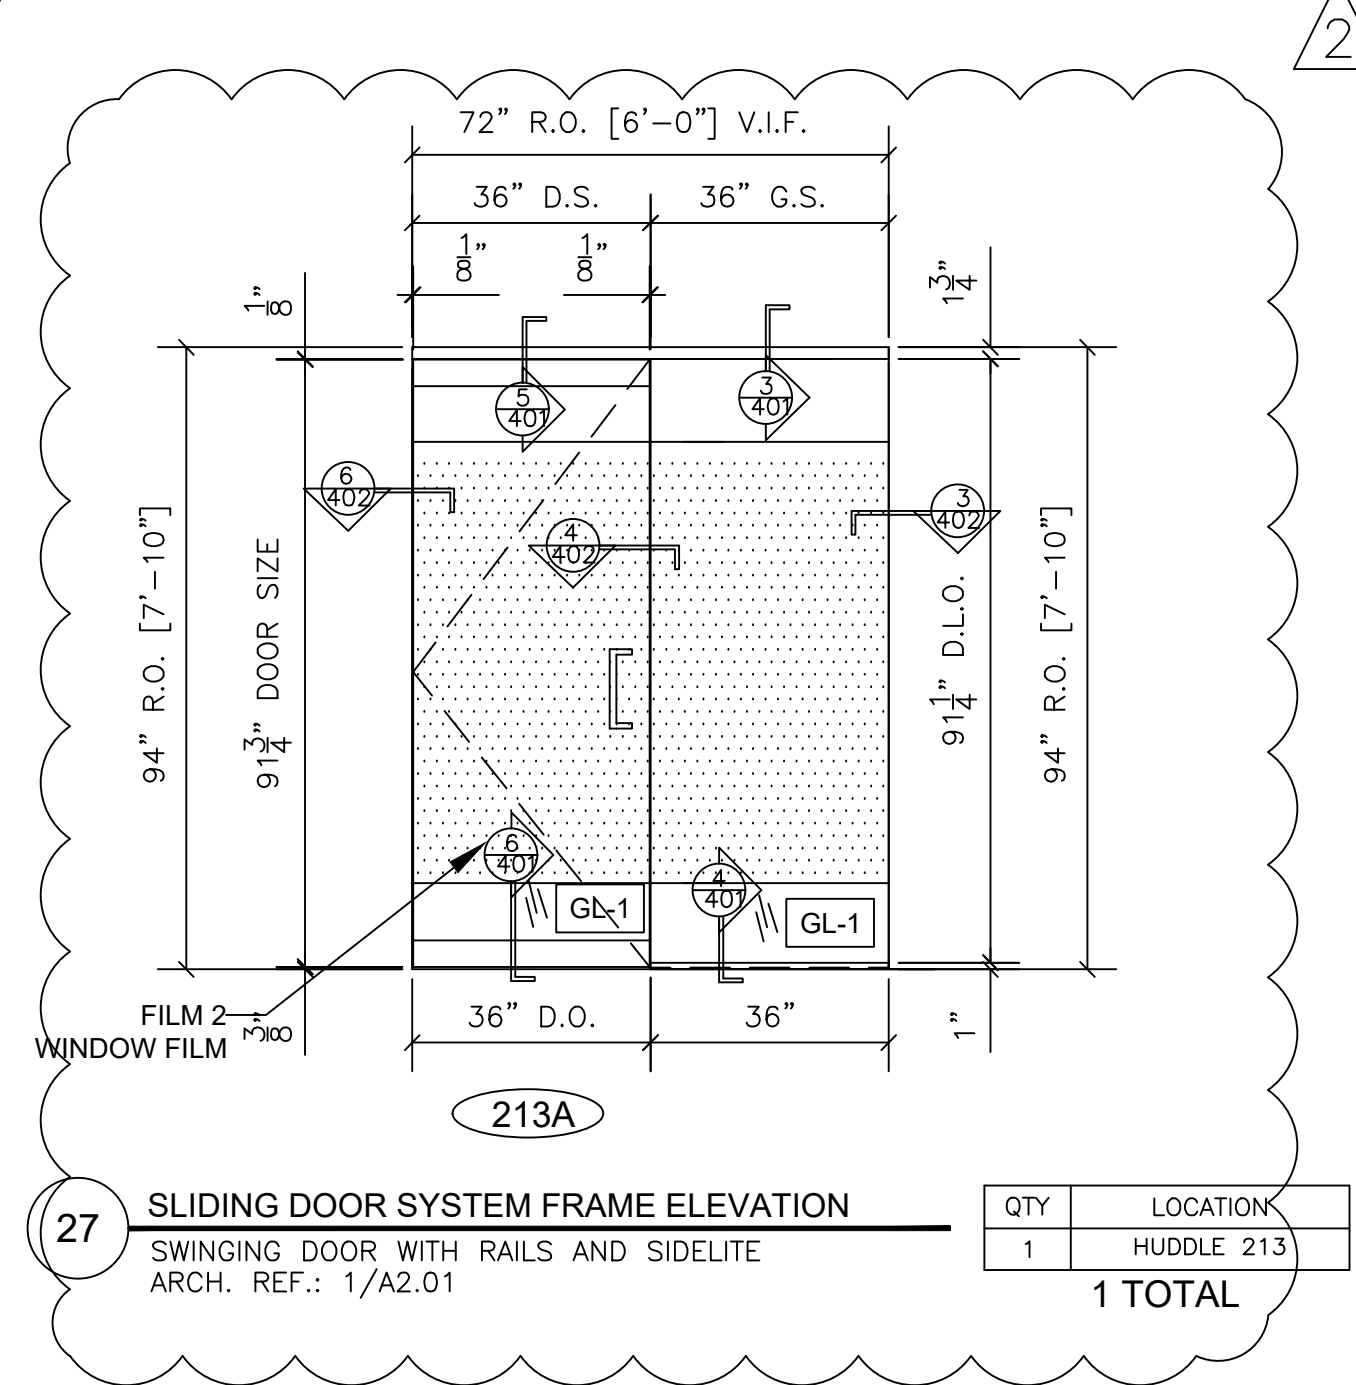

NO.	REVISION/ISSUED	DATE
1	1ST SUBMITTAL	12/23/19
2	PER COMMENTS	2/19/20

PROJECT NAME & LOCATION:
FDA
10749 WEST 84TH TERRACE
LENEXA, KANSAS 66214
SHEET TITLE:
FRAMING ELEVATION

DRAFTSMAN:
KS DRAFTING & DESIGN, LLC.
KYLE SCHNECK
HARRISBURG, PA 17110
KYLE@KSDRAFTINGDESIGNLLC.COM
717-228-7114
KSDRAFTINGDESIGNLLC.COM

ARCHITECT:

GLAZING CONTRACTOR:


DRAWN BY: KEVIN VERGARA
CHECKED BY: KYLE SCHNECK

DATE: 12/23/19
SHEET: 209

FILM 1 AT ALL LITES IN THIS
FRAME ELEVATION



FILM 2
WINDOW FILM

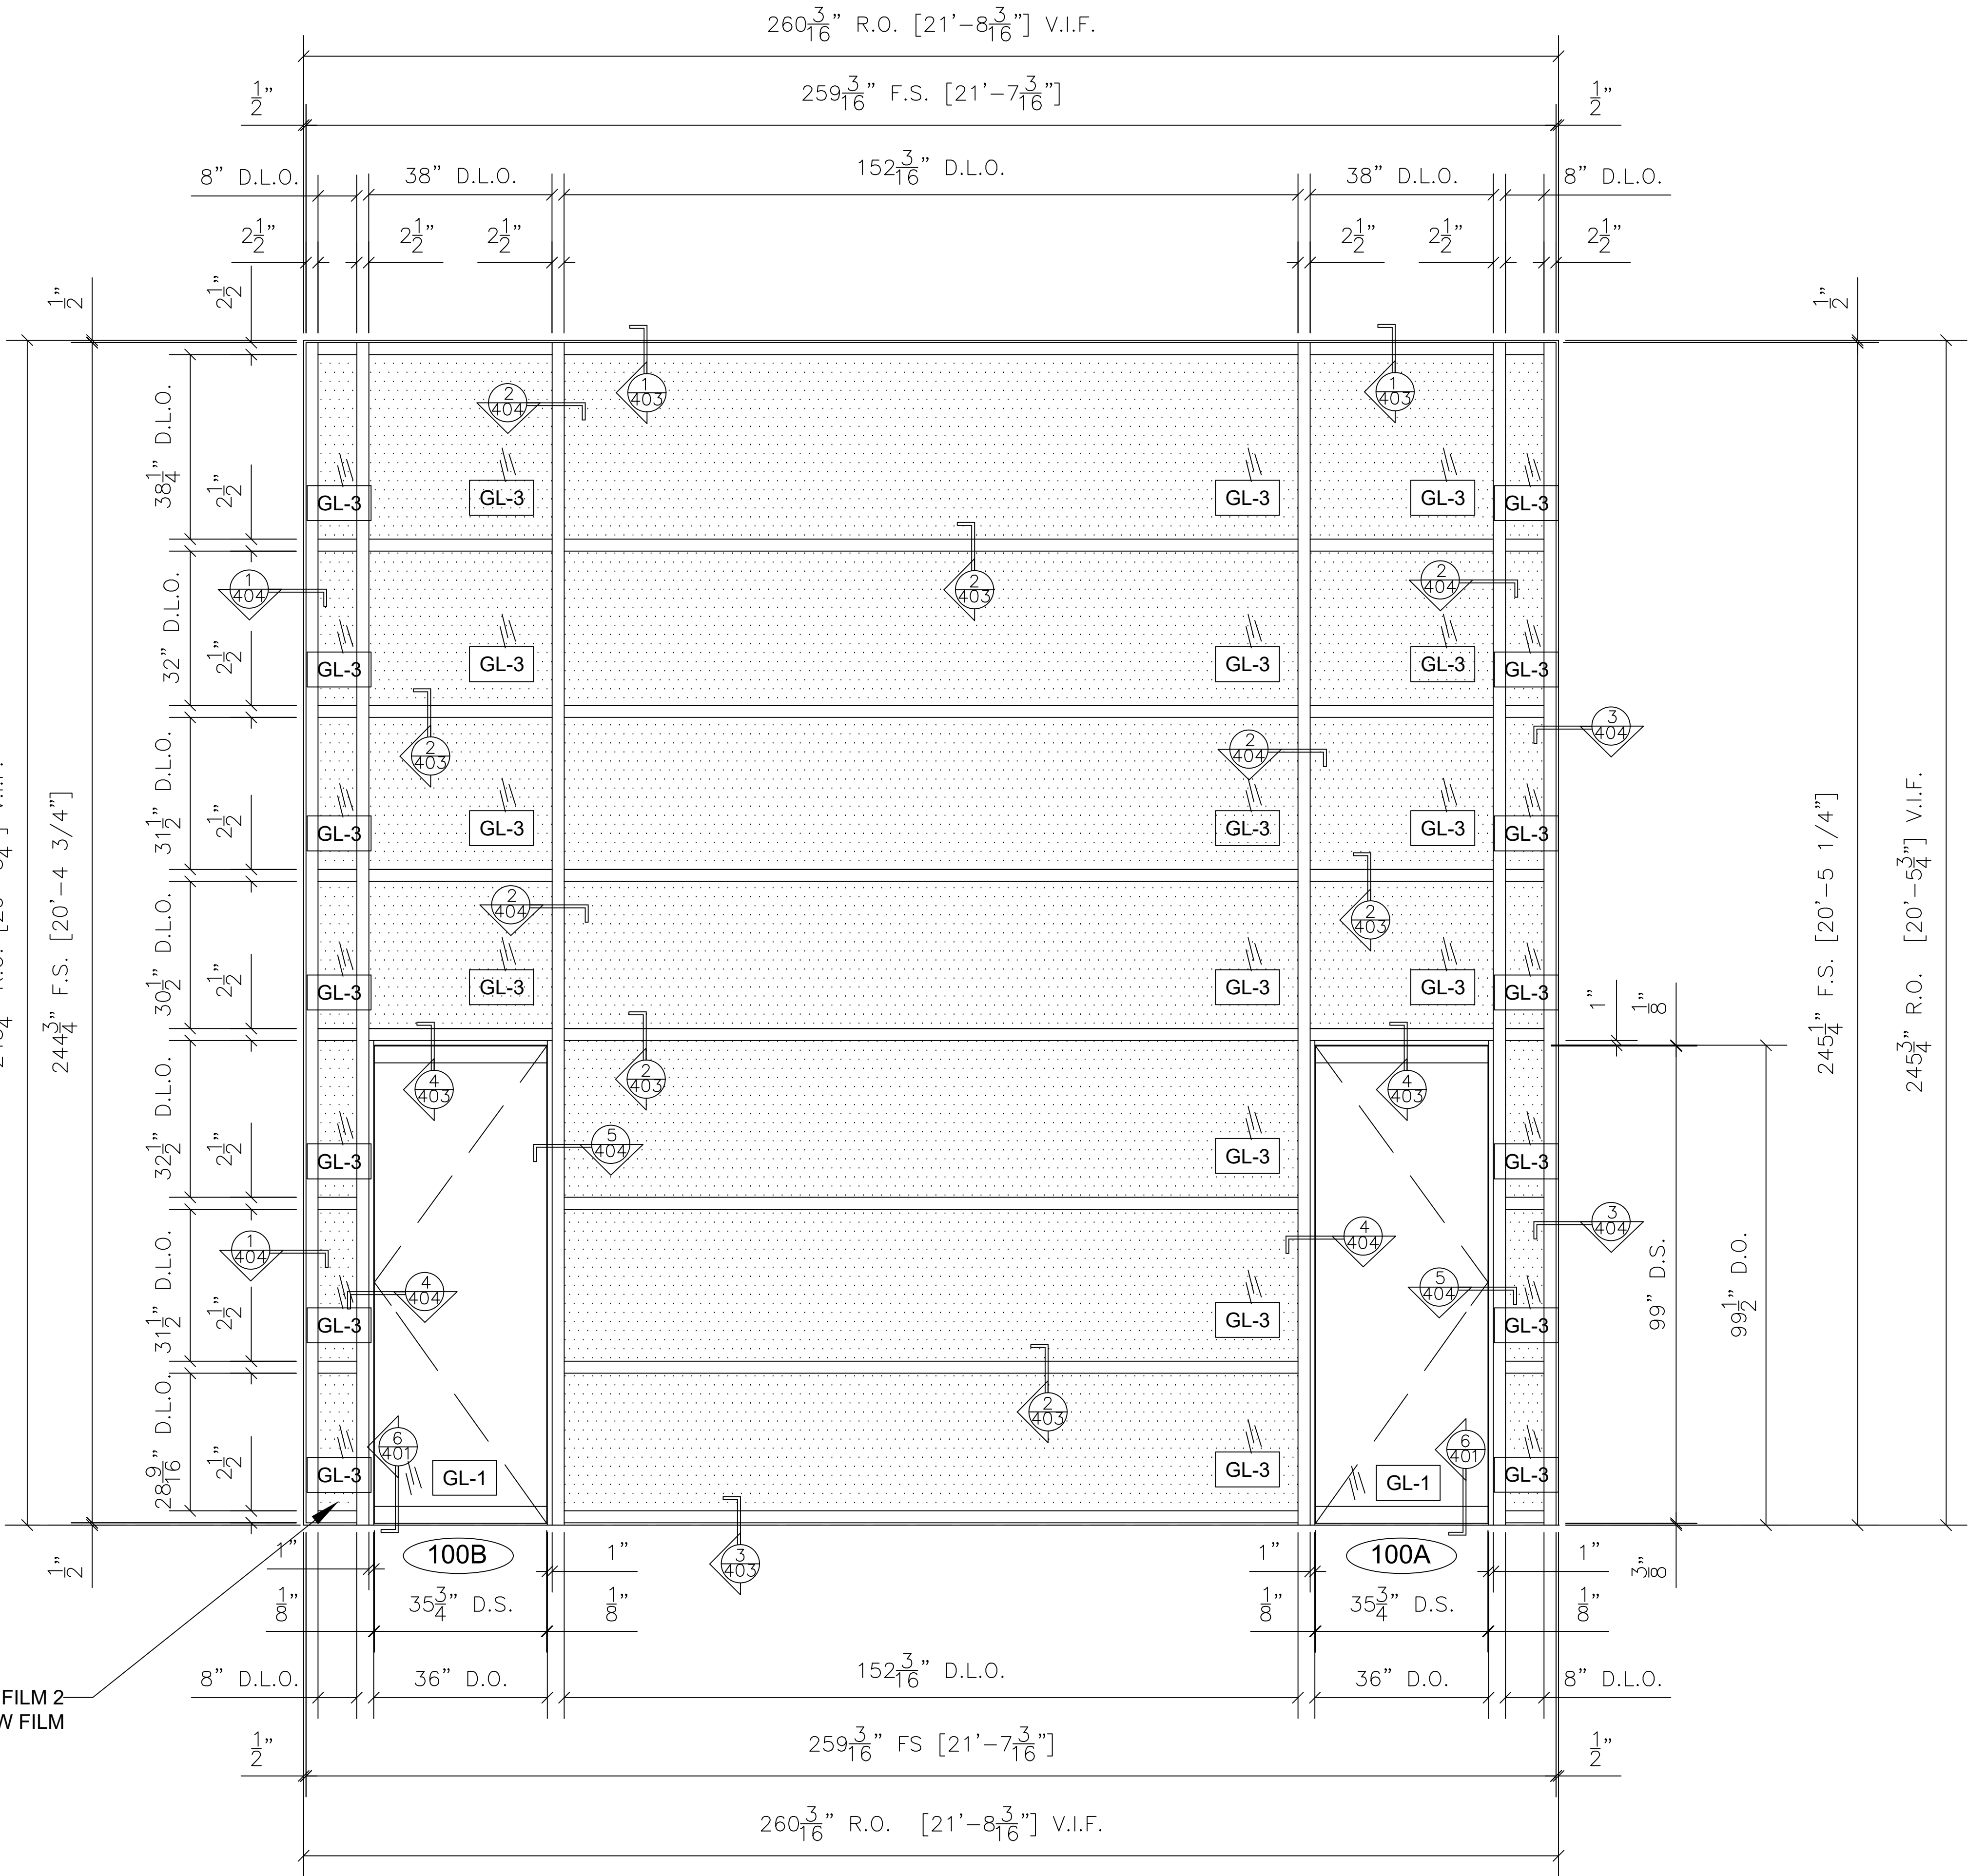

34 CURTAINWALL VESTIBULE FRAME ELEVATION			QTY	LOCATION
TUBELITE 400TU CURTAIN WALL ARCH. REF.: 7/A6.00			1	SECURITY VESTIBULE 101
			1 TOTAL	

NO.	REVISION/ISSUED	DATE
1	1ST SUBMITTAL	12/23/19

PROJECT NAME & LOCATION:	FDA
	10749 WEST 84TH TERRACE LENEXA, KANSAS 66214
	SHEET TITLE: FRAMING ELEVATION

DRAFTSMAN:
KS DRAFTING & DESIGN, LLC. KYLE SCHNECK HARRISBURG, PA 17110 KYLE@KSDRAFTINGDESIGNLLC.COM 717-228-7114 KSDRAFTINGDESIGNLLC.COM

ARCHITECT:

GLAZING CONTRACTOR:

DRAWN BY:	KEVIN VERGARA
CHECKED BY:	KYLE SCHNECK

DATE:	12/23/19	SHEET:
		211

NO.	REVISION/ISSUED	DATE
1	1ST SUBMITTAL	12/23/19
2	PER COMMENTS	2/19/20

PROJECT NAME & LOCATION:	10749 WEST 84TH TERRACE	
	LENEXA, KANSAS 66214	
FDA	SHEET TITLE:	DETAILS






DRAFTSMAN:
KS DRAFTING & DESIGN, LLC. KYLE SCHNECK HARRISBURG, PA 17110 KYLE@KSDRAFTINGDESIGNLLC.COM 717-228-7114 KSDRAFTINGDESIGNLLC.COM

ARCHITECT:


GLAZING CONTRACTOR:

DRAWN BY:	KEVIN VERGARA
CHECKED BY:	KYLE SCHNECK


DATE:	12/23/19	SHEET:
		400

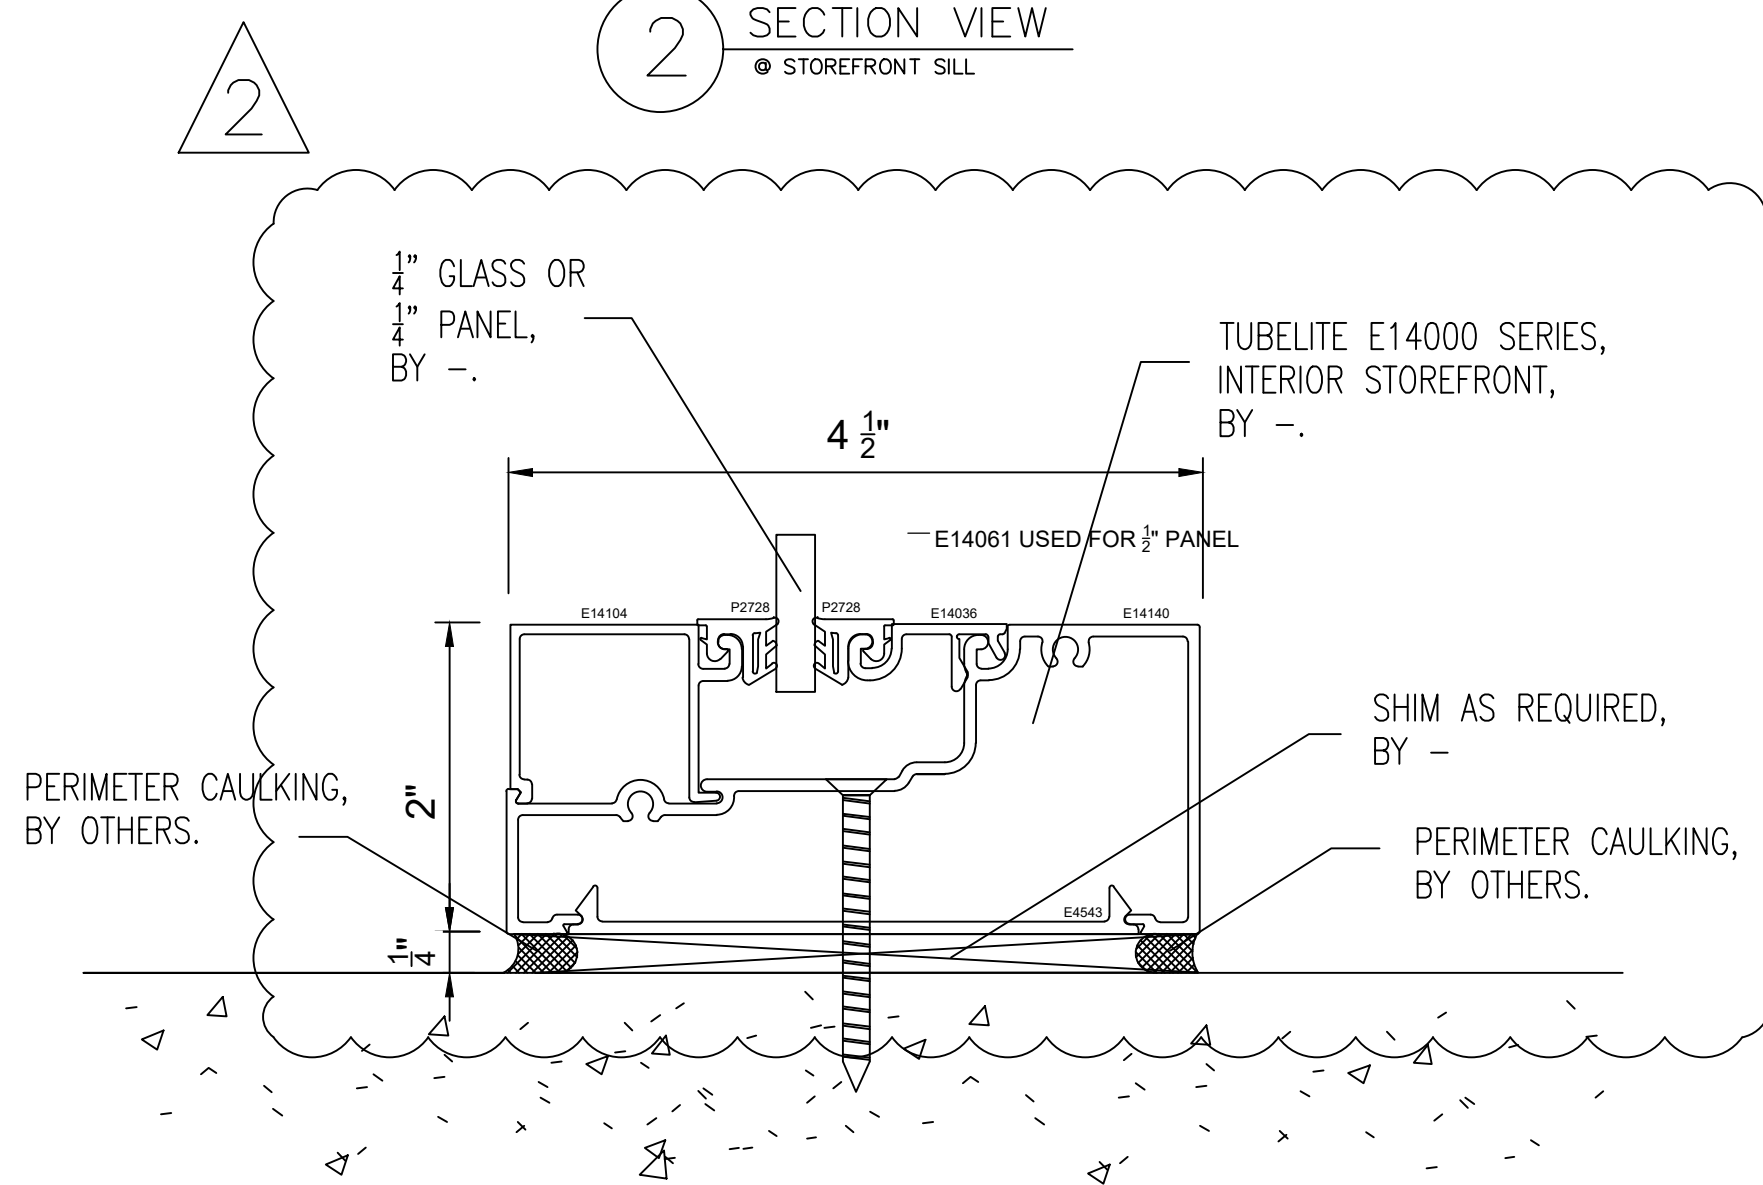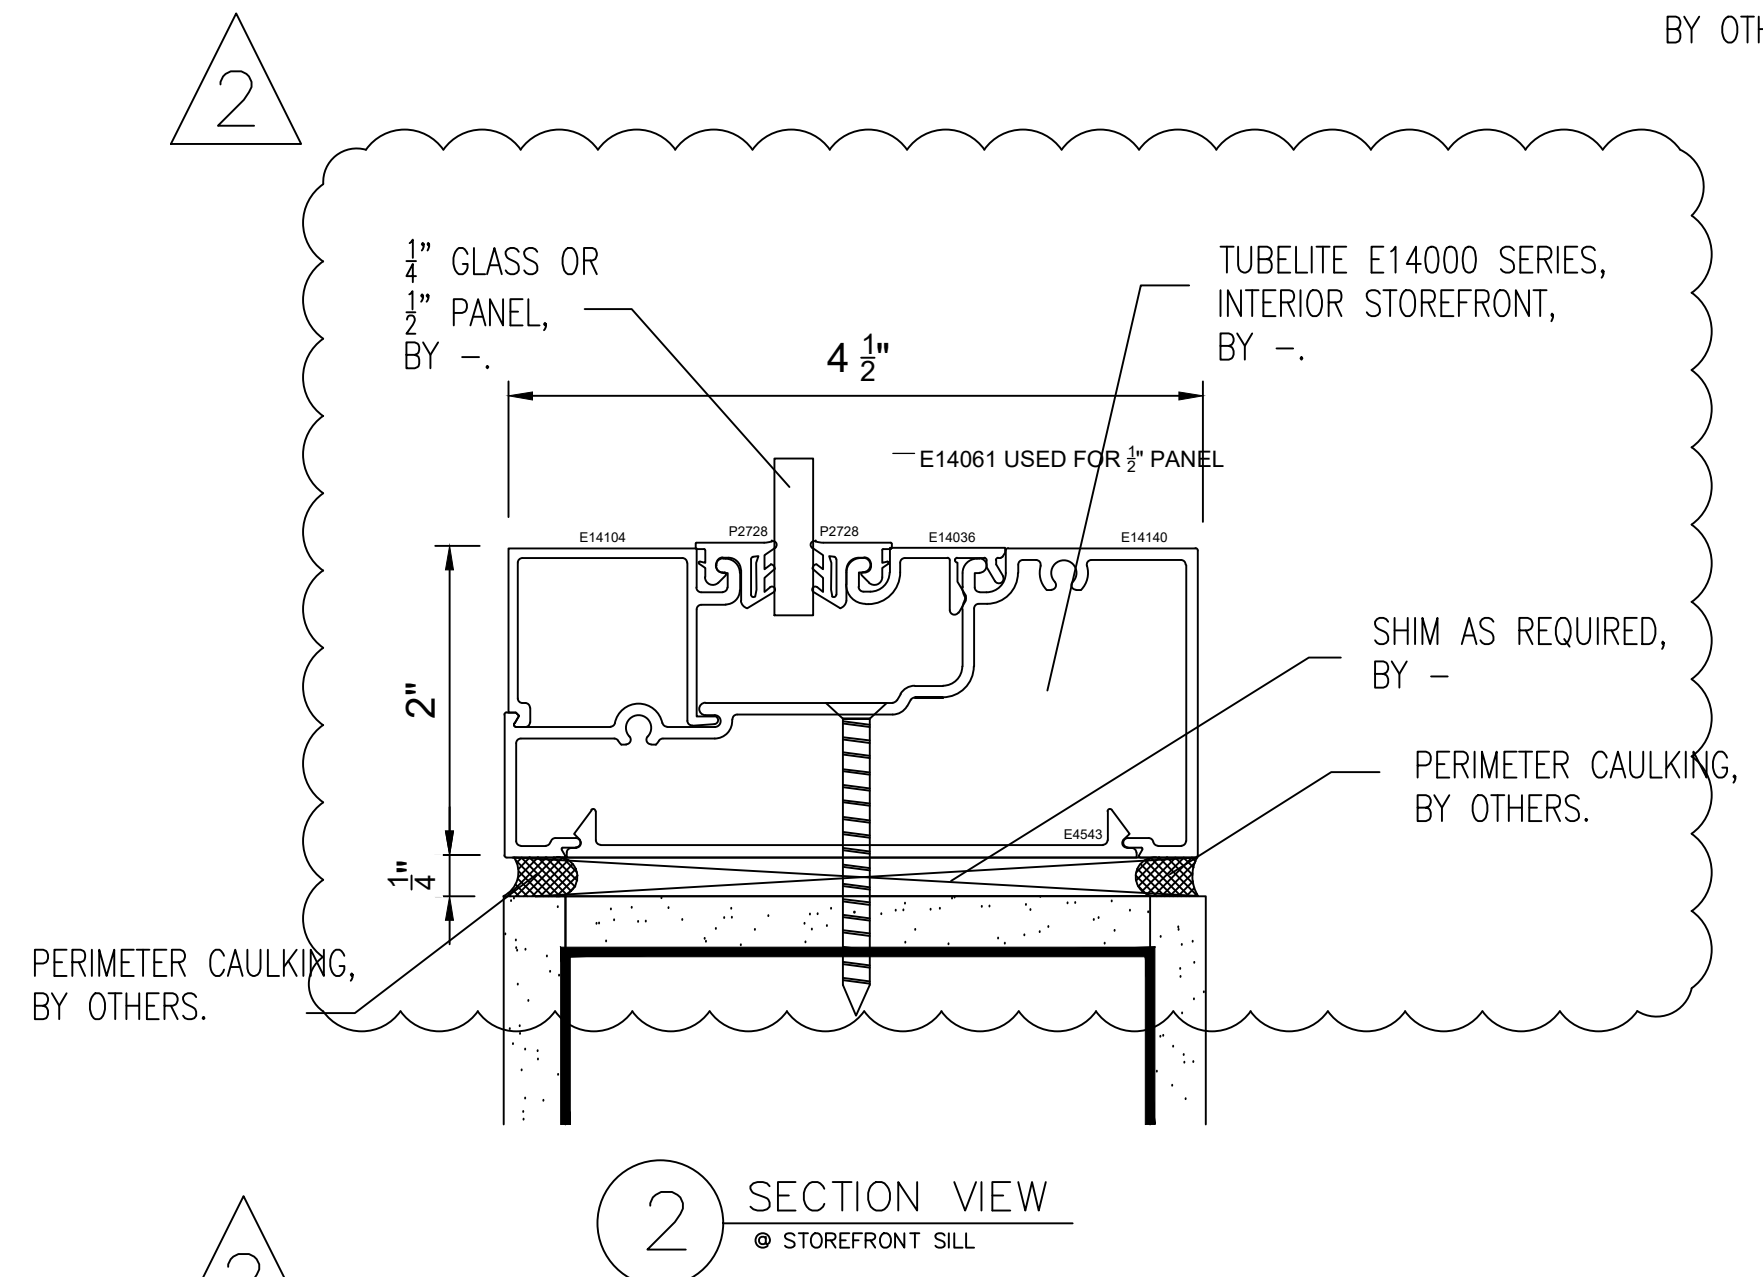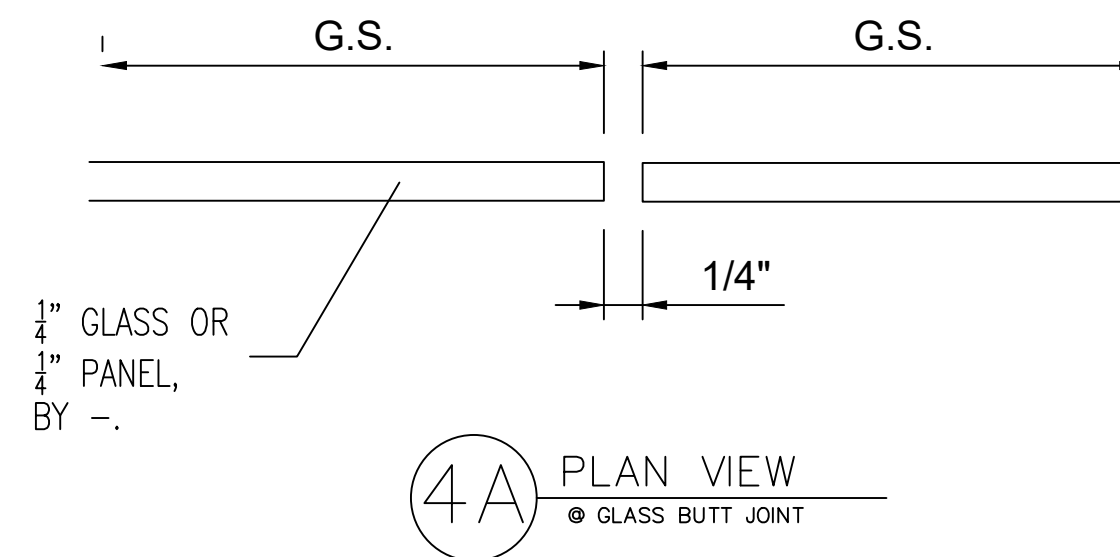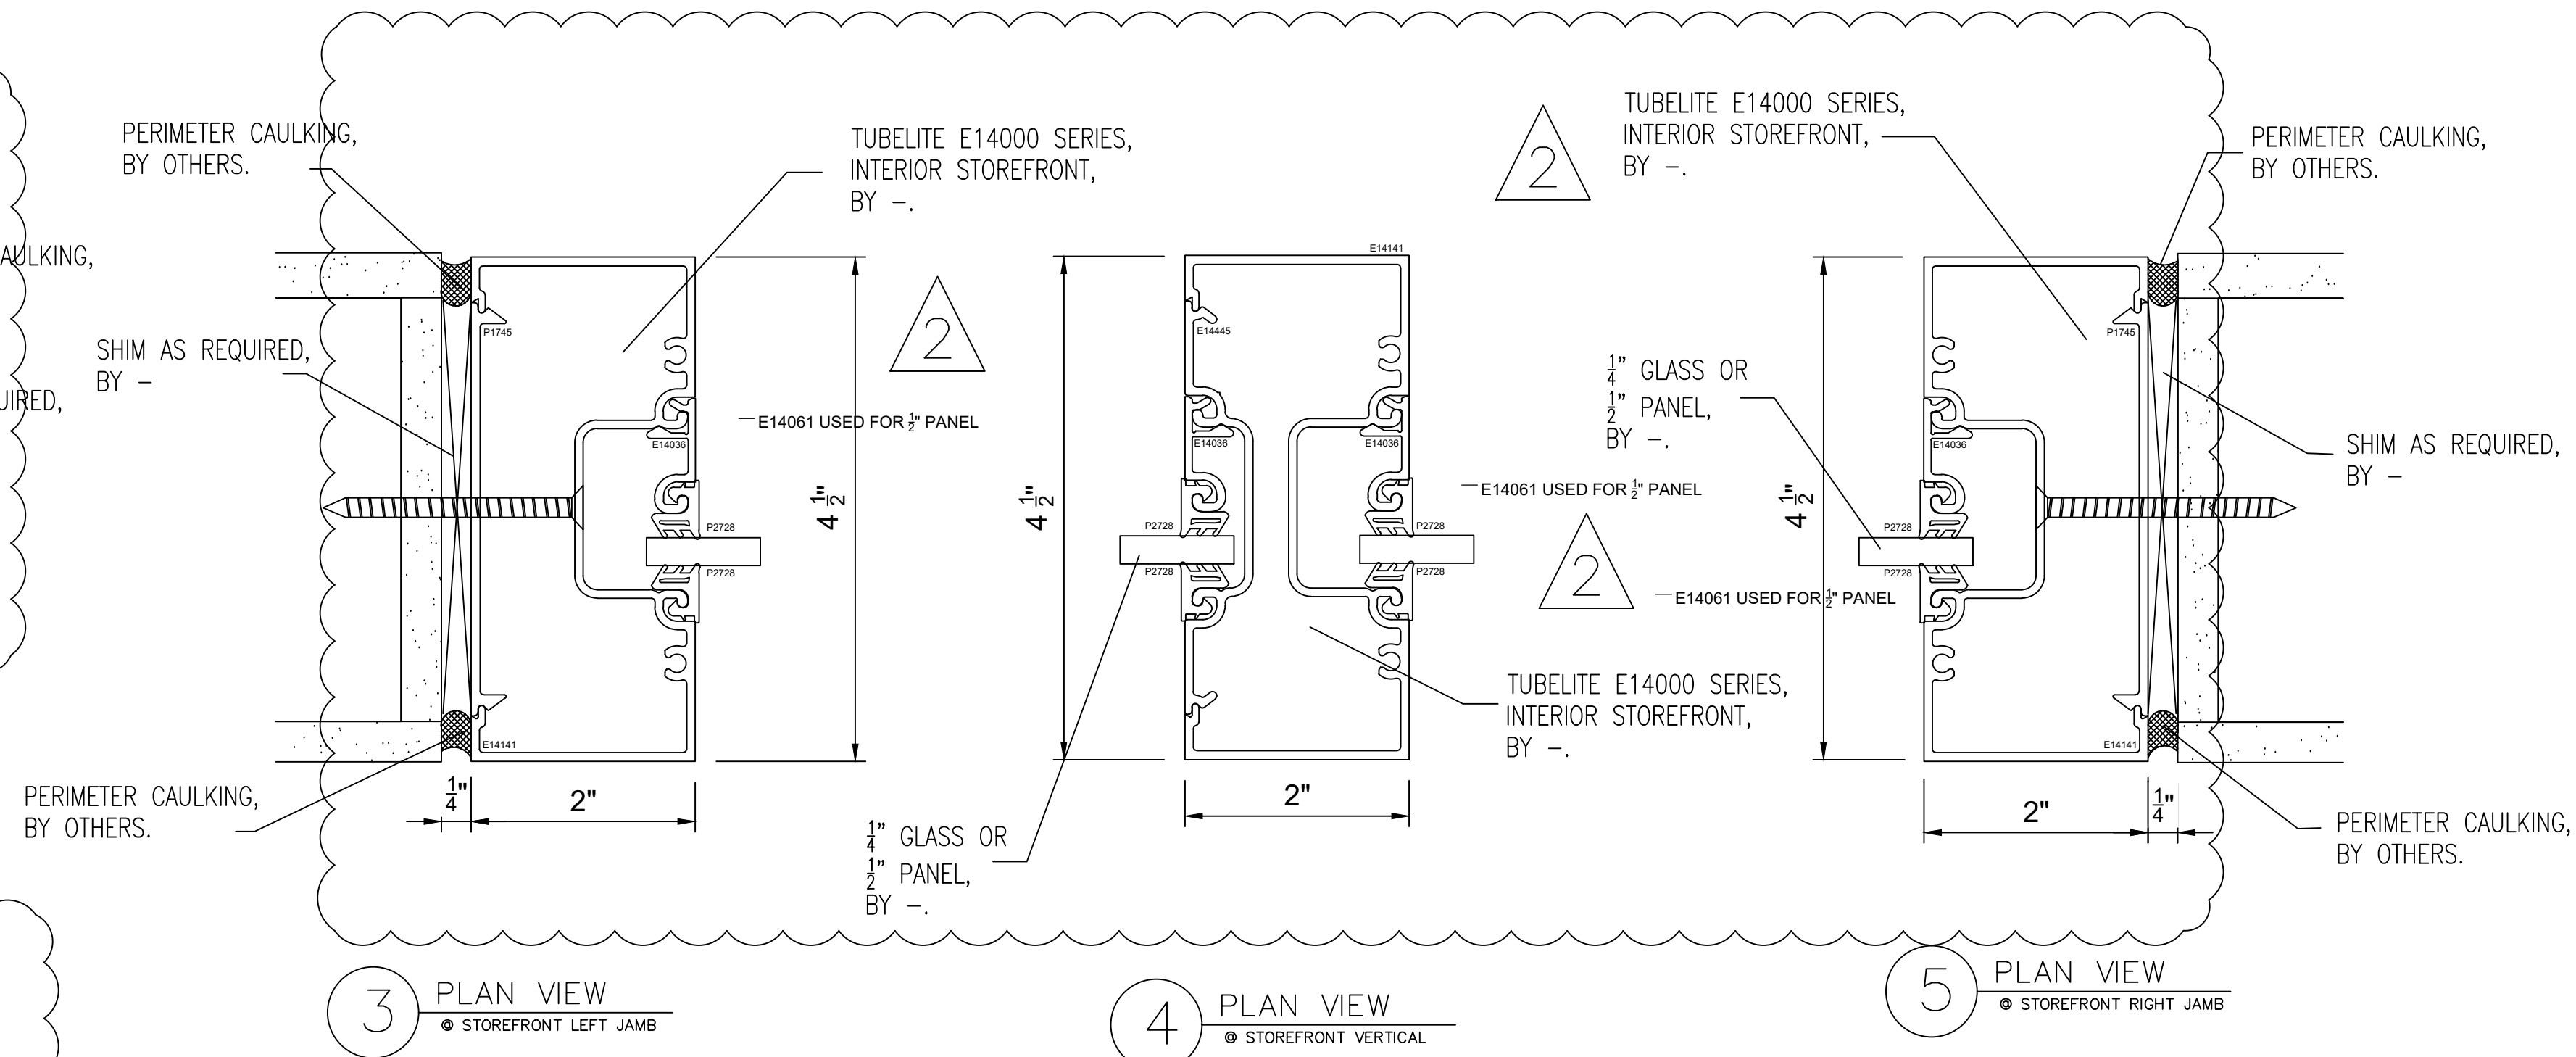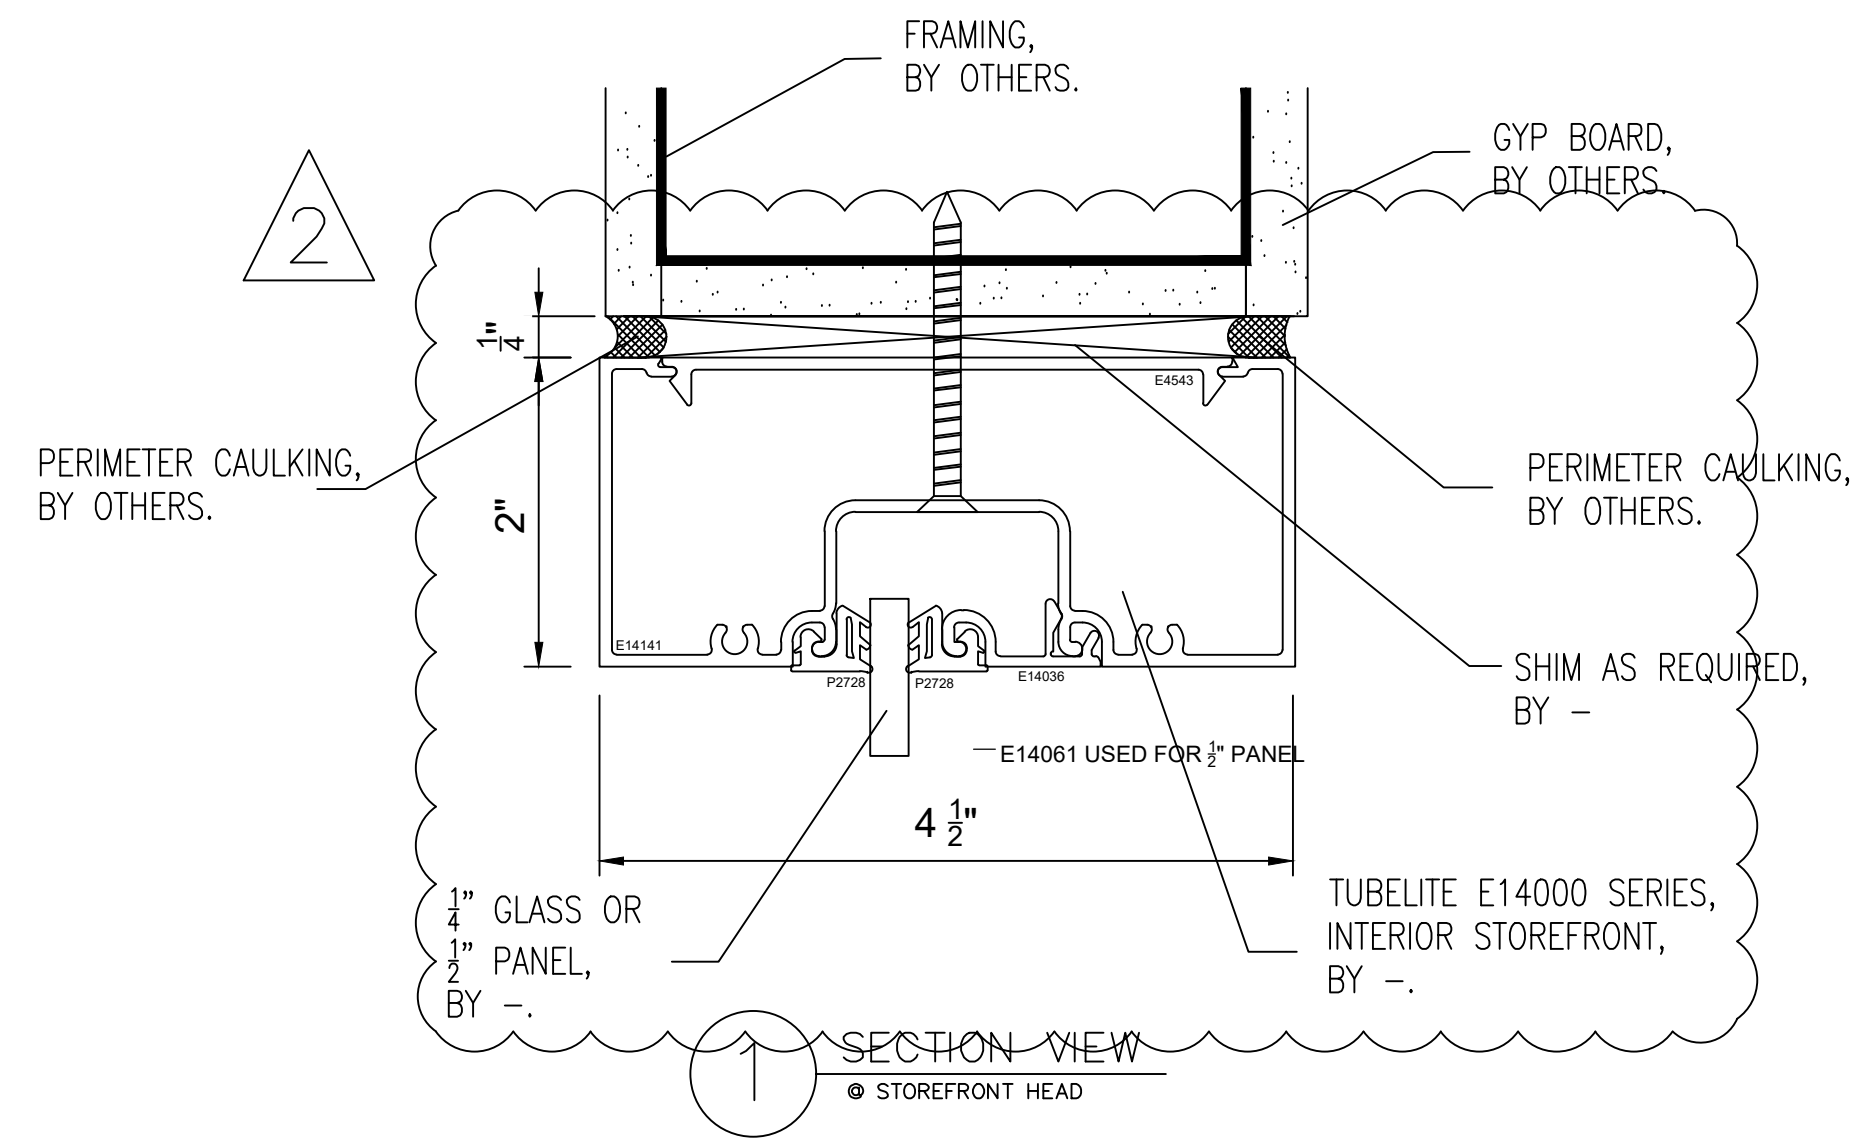


2A SECTION VIEW
● STOREFRONT SILL

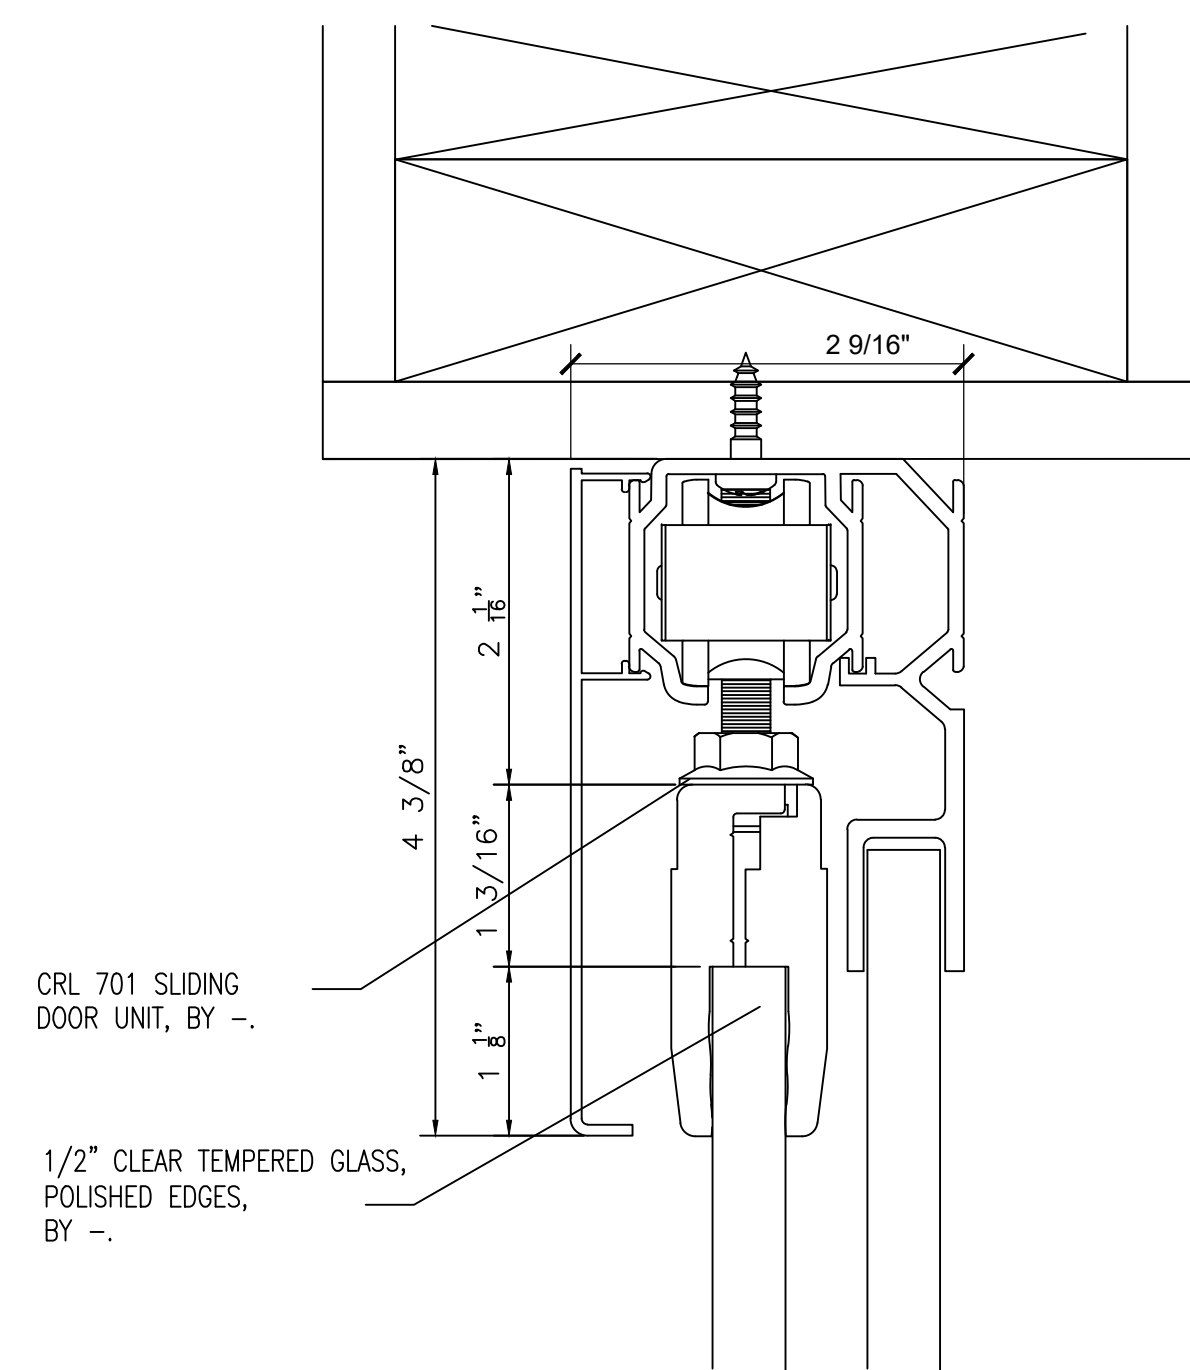


1 SECTION CUT
● SLIDING DOOR

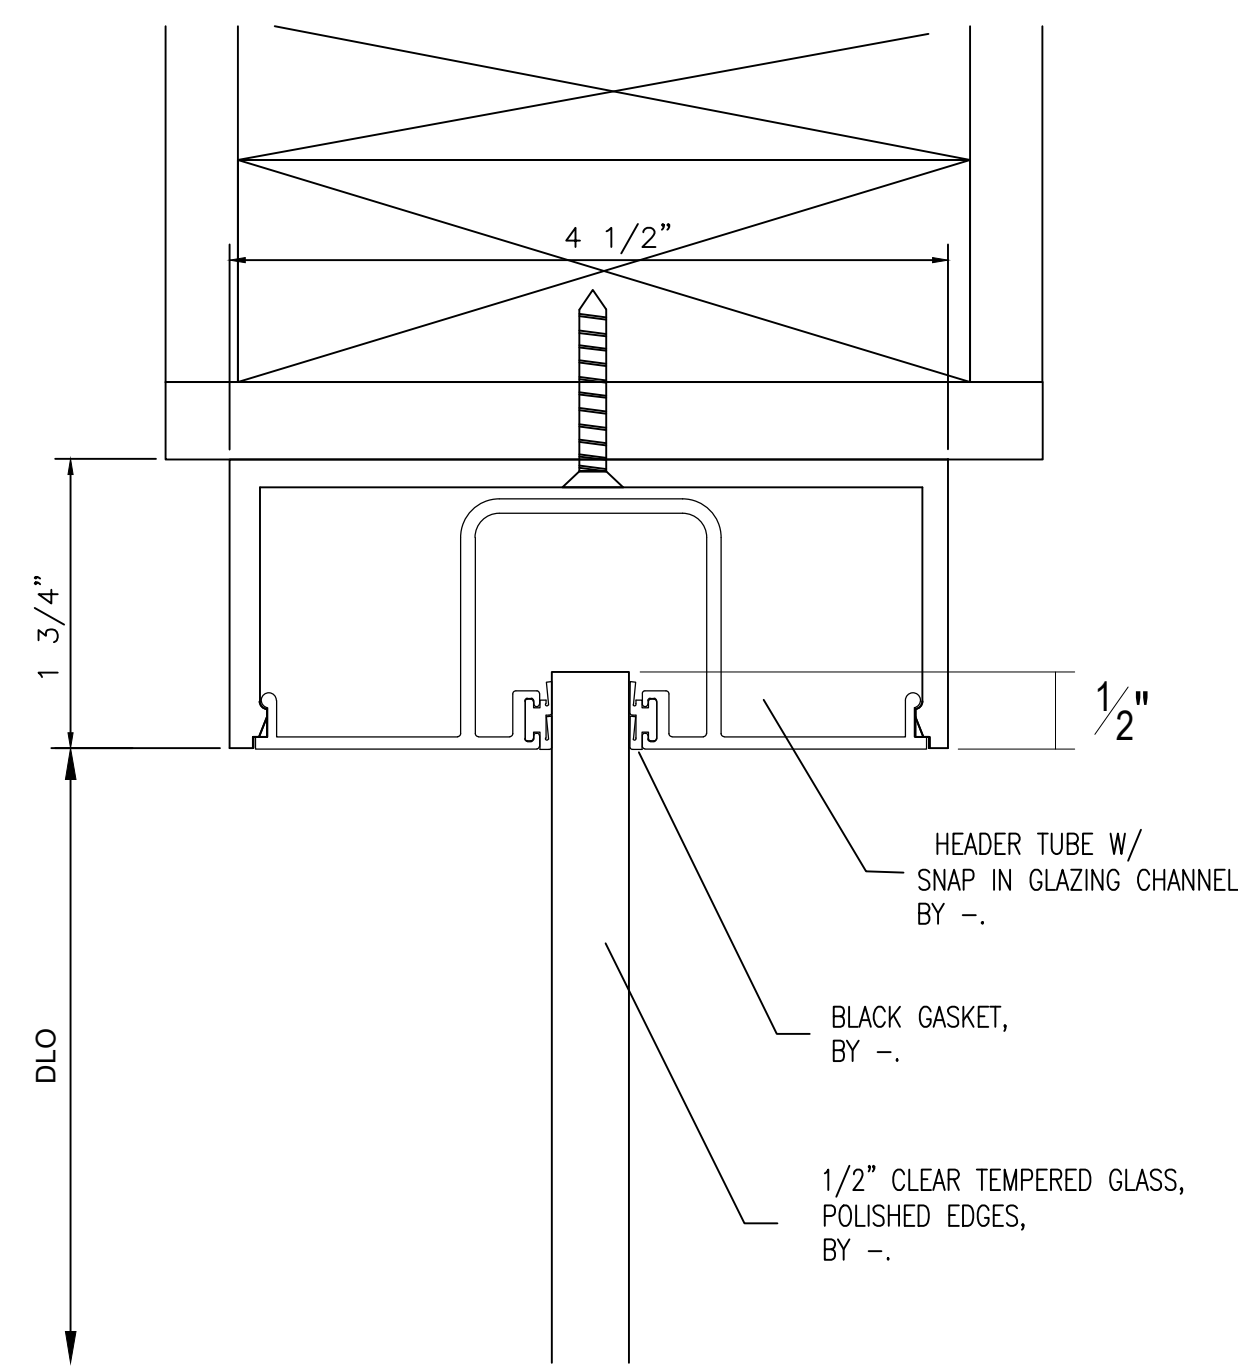


3 SECTION CUT
● SIDELITE HEADER

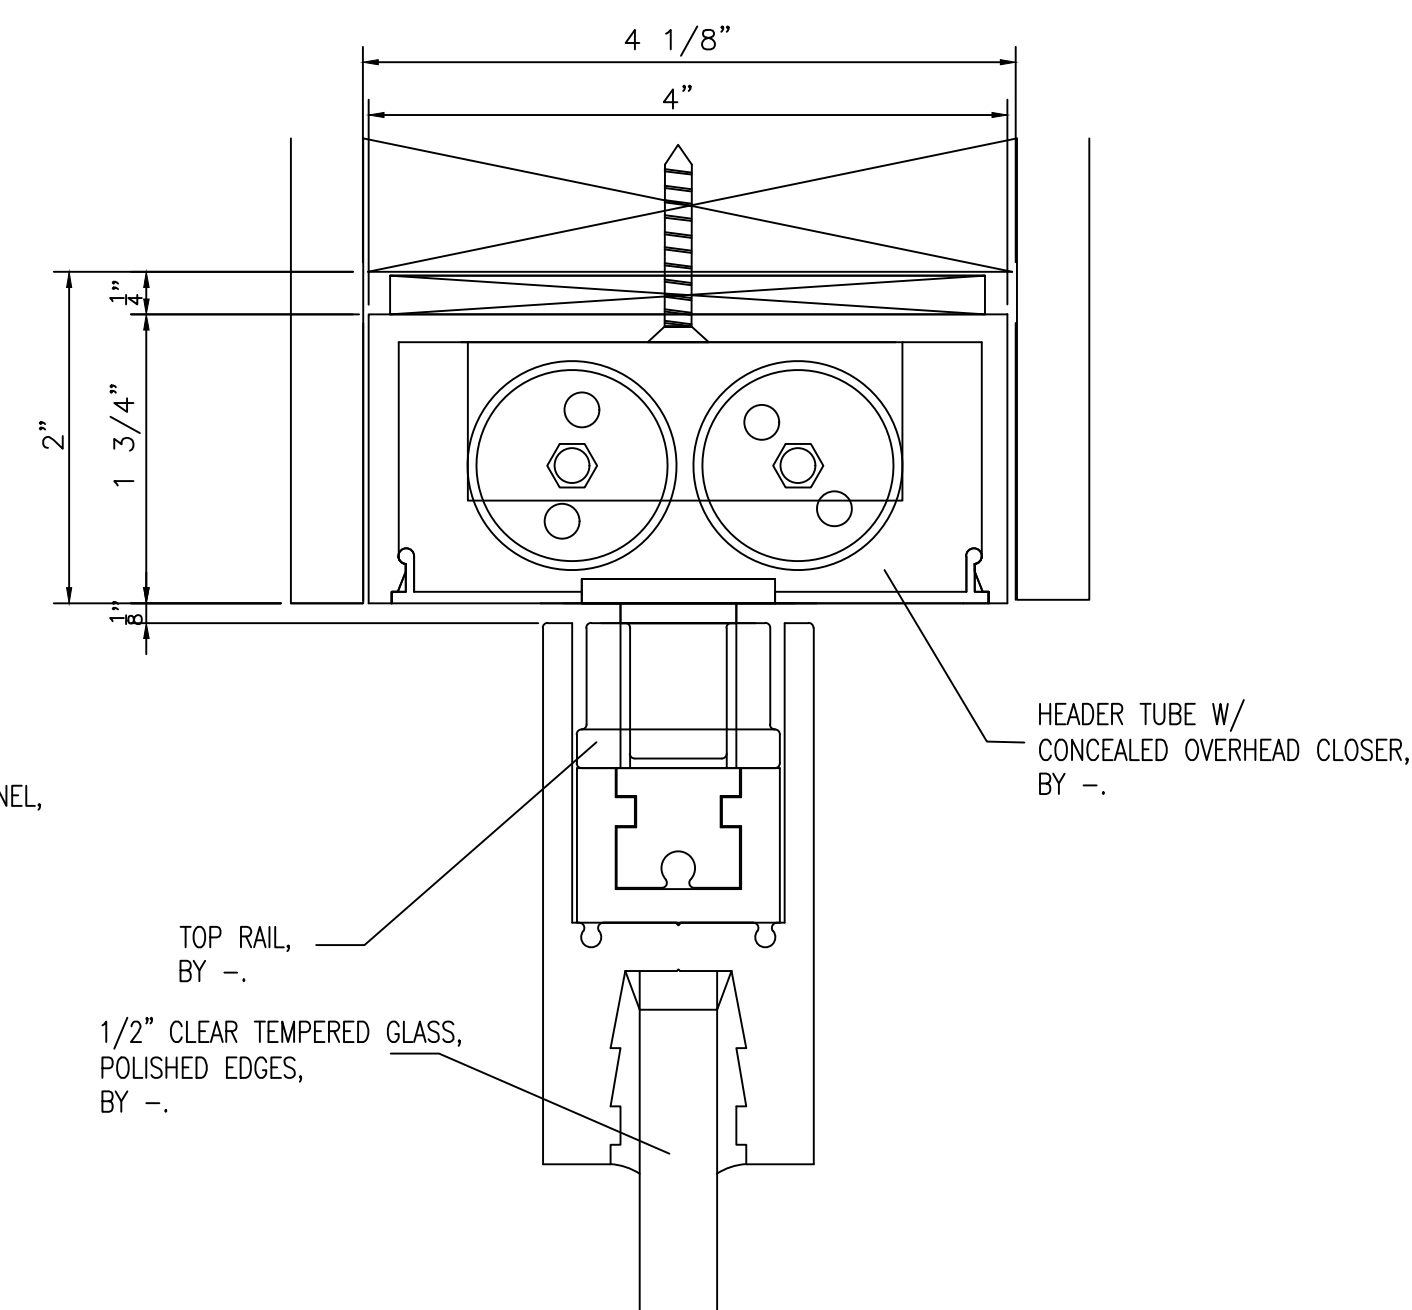


5 SECTION CUT
● SWING DOOR

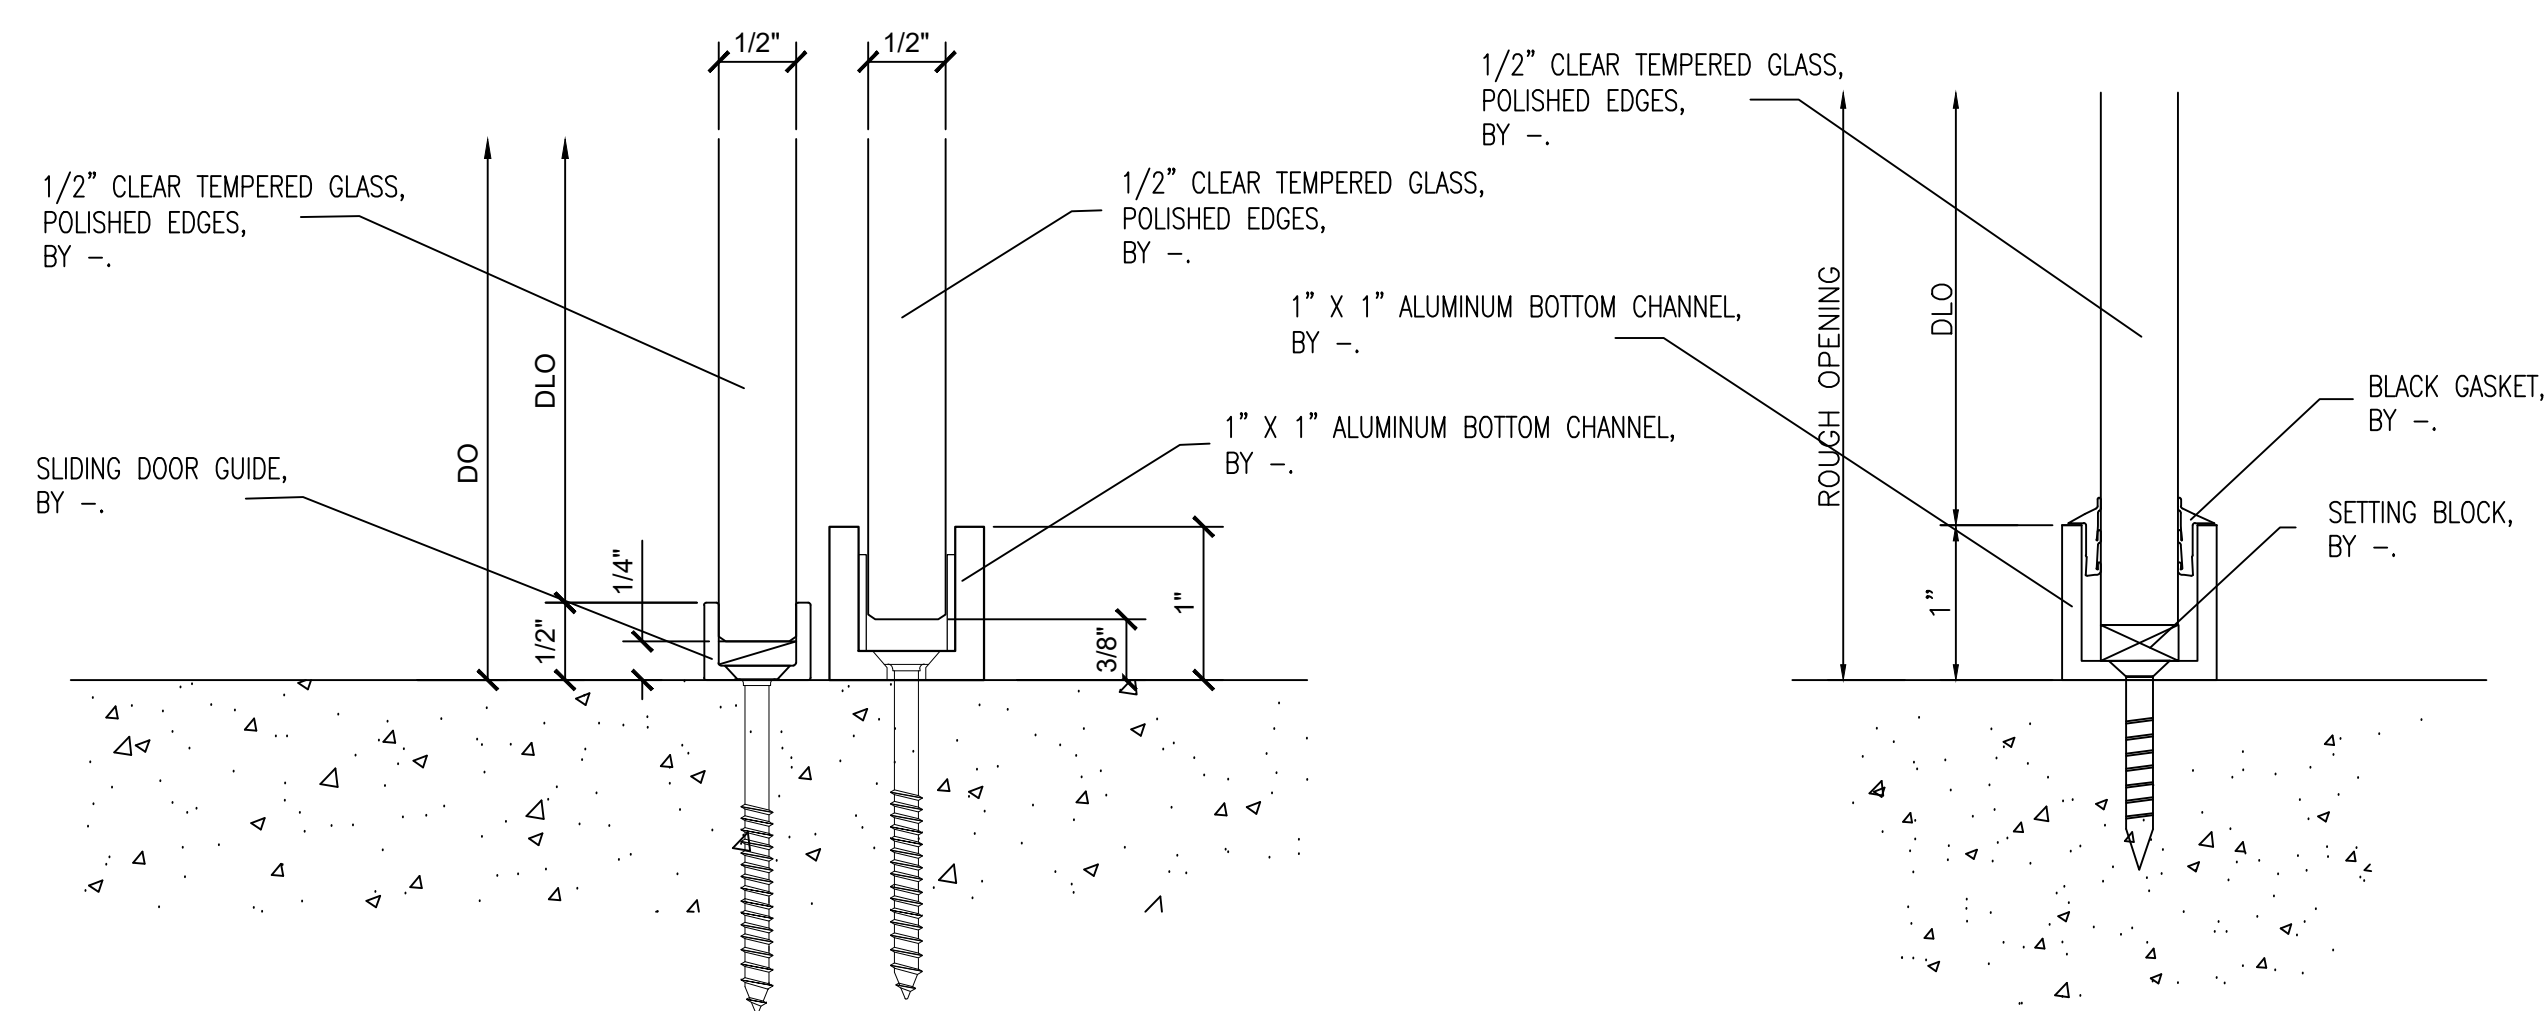

2 SECTION CUT
● SLIDING DOOR GUIDE

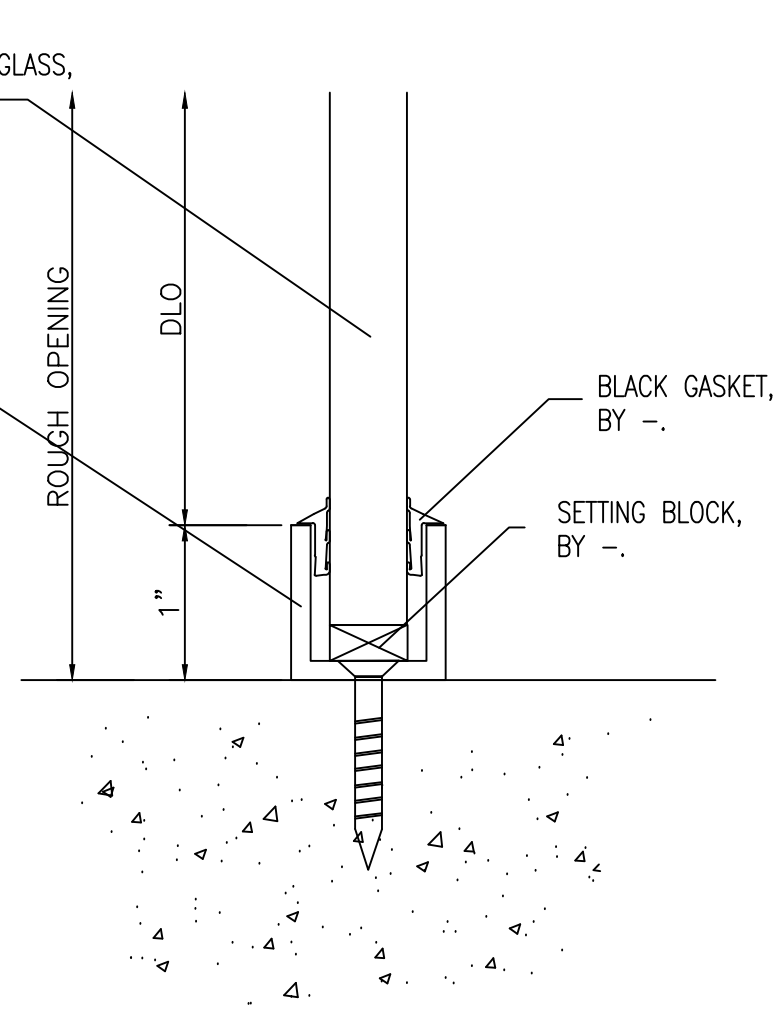

4 SECTION CUT
● SIDELITE BOTTOM CHANNEL

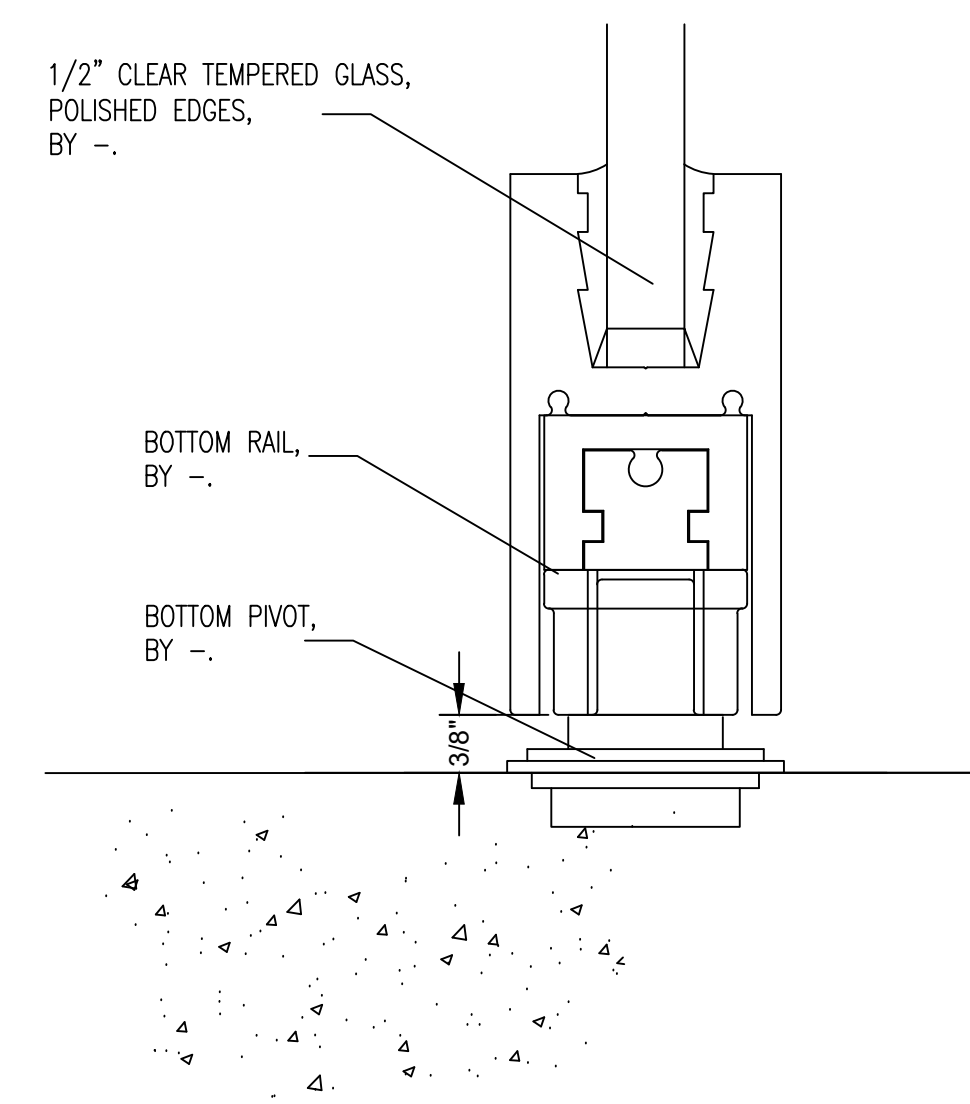

6 SECTION CUT
● SWING DOOR

NO.	REVISION/ISSUED	DATE
1	1ST SUBMITTAL	12/23/19

PROJECT NAME & LOCATION:	FDA
10749 WEST 84TH TERRACE LENEXA, KANSAS 66214	
SHEET TITLE:	DETAILS


DRAFTSMAN:
KS DRAFTING & DESIGN, LLC. KYLE SCHNECK HARRISBURG, PA 17110 KYLE@KSDRAFTINGDESIGNLLC.COM 717-228-7114 KSDRAFTINGDESIGNLLC.COM

ARCHITECT:

GLAZING CONTRACTOR:

DRAWN BY:	KEVIN VERGARA
CHECKED BY:	KYLE SCHNECK

DATE:	12/23/19
SHEET:	401

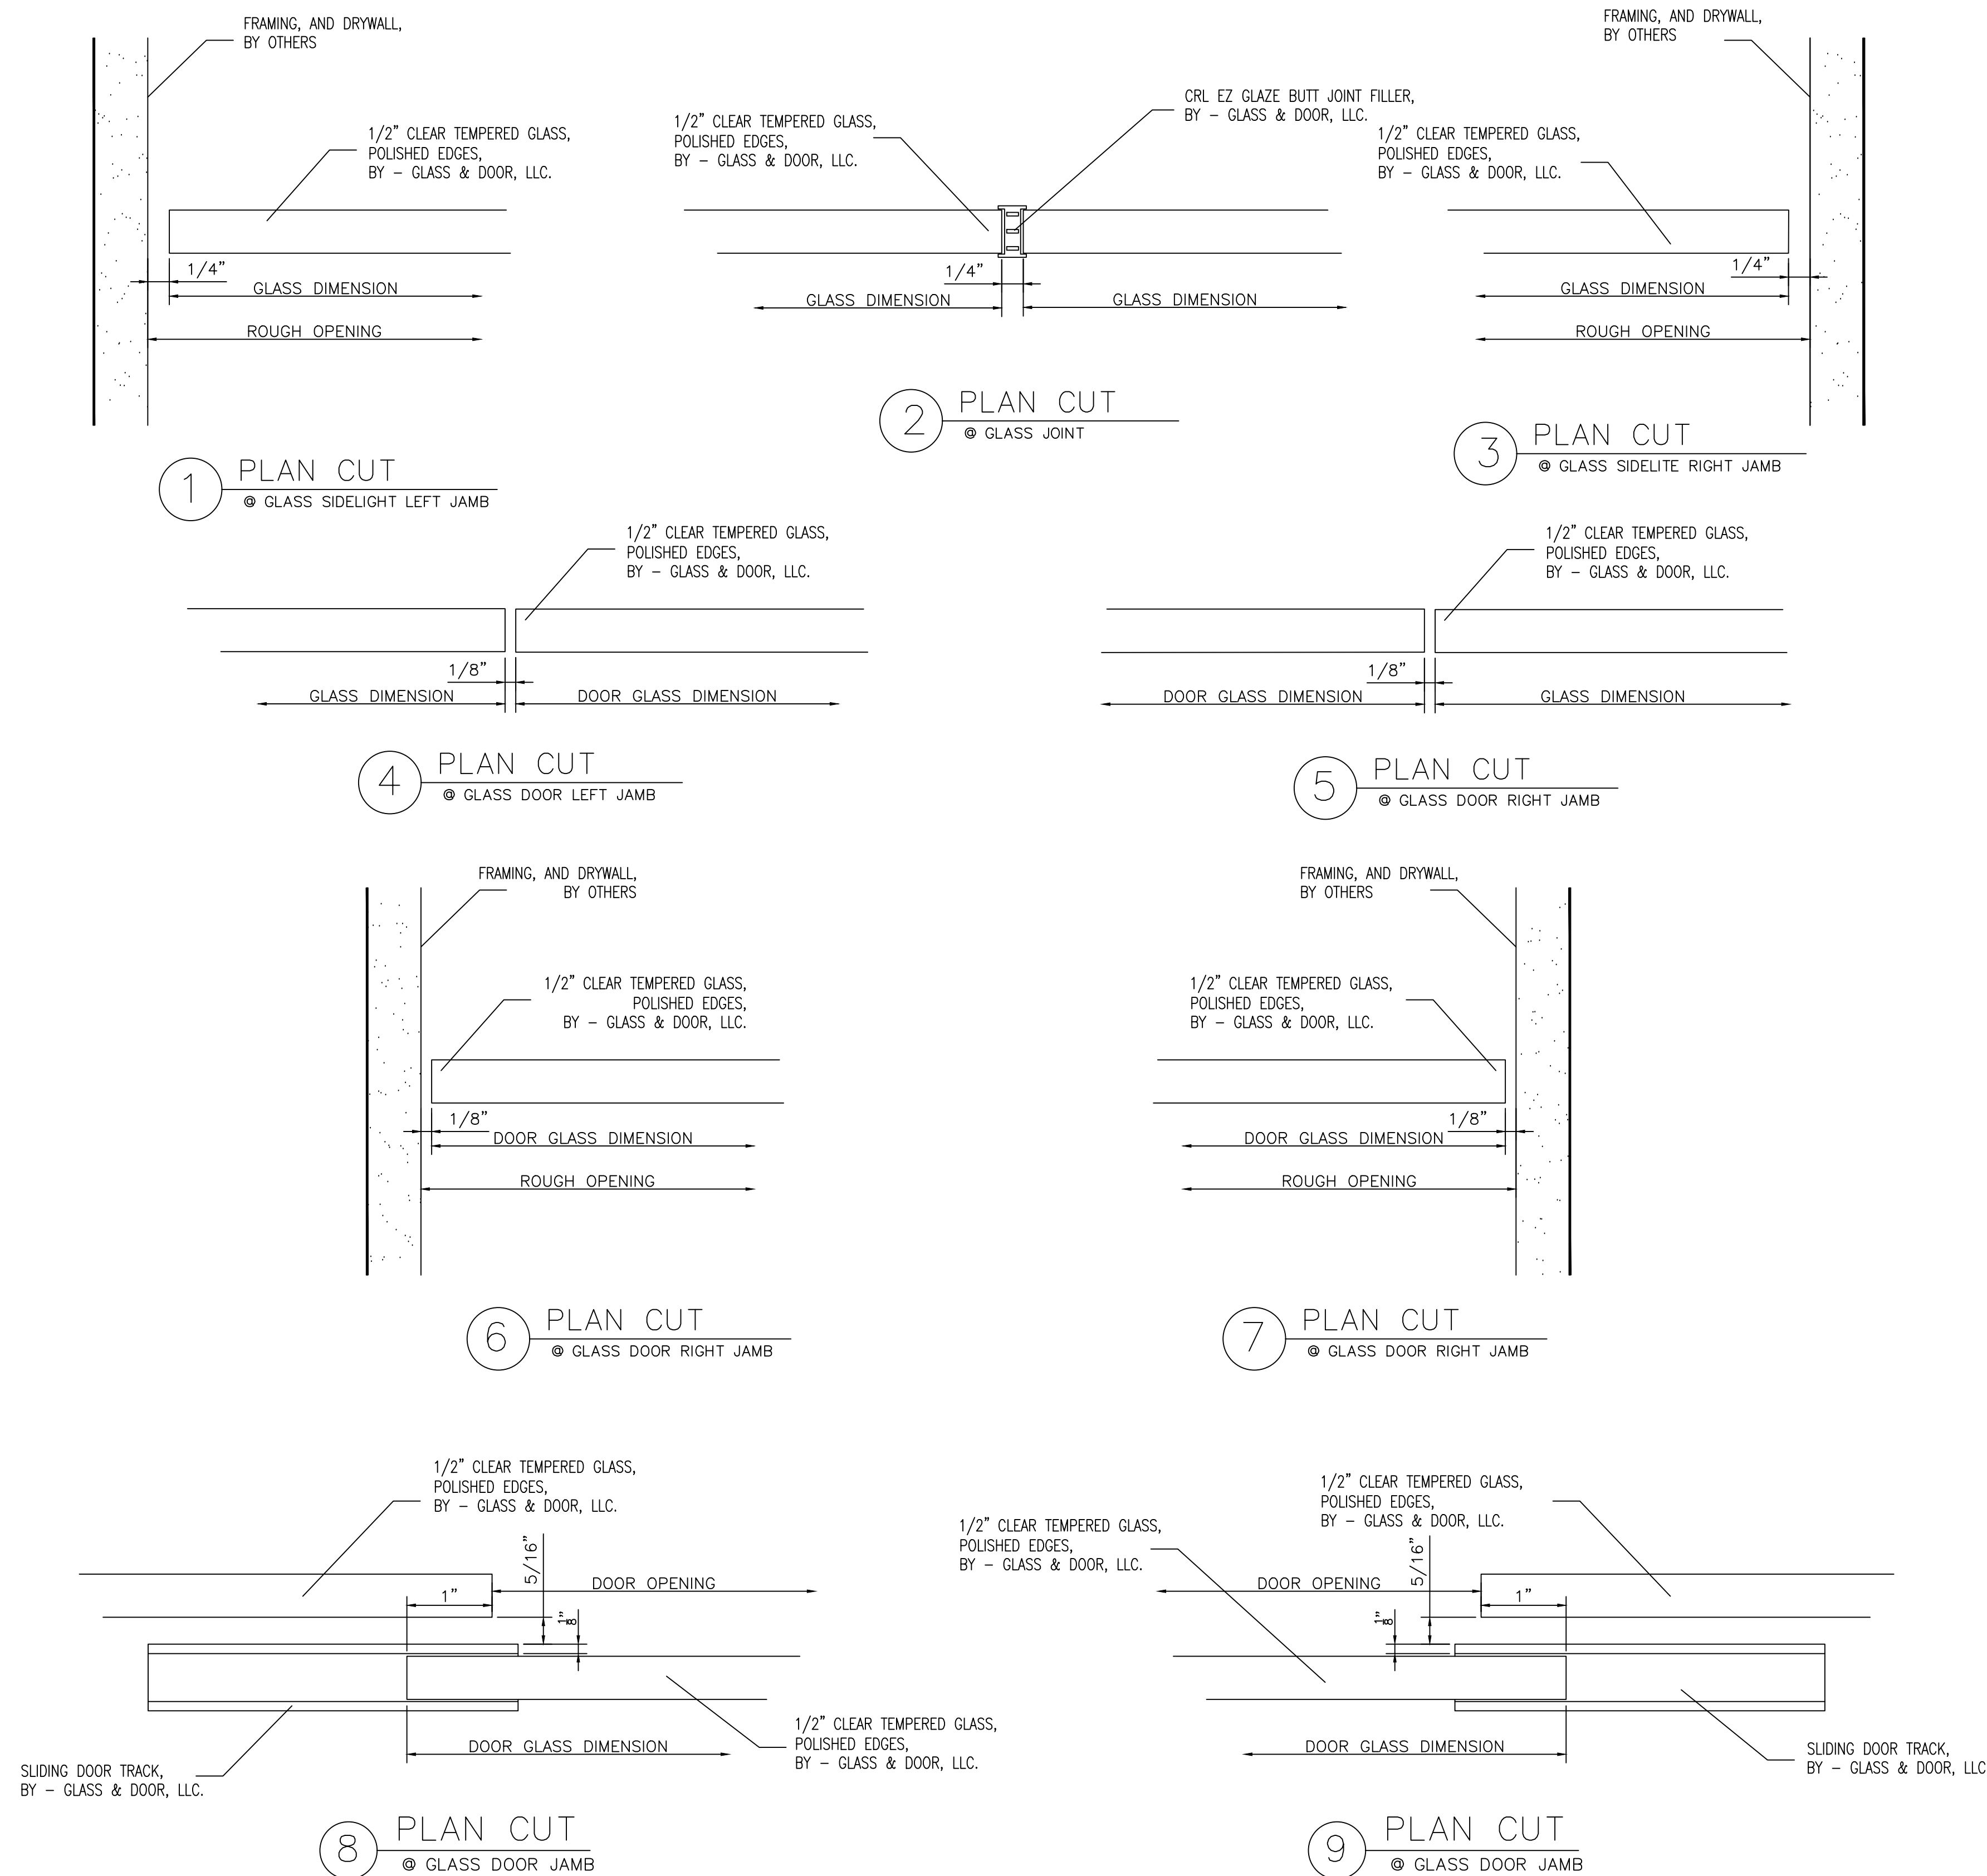


NO.	REVISION/ISSUED	DATE
1	1ST SUBMITTAL	12/23/19

PROJECT NAME & LOCATION:	10749 WEST 84TH TERRACE LENEXA, KANSAS 66214
FDA	
SHEET TITLE:	DETAILS


DRAFTSMAN:	KS DRAFTING & DESIGN, LLC. KYLE SCHNECK HARRISBURG, PA 17110 KYLE@KSDRAFTINGDESIGNLLC.COM 717-228-7114 KSDRAFTINGDESIGNLLC.COM
ARCHITECT:	
GLAZING CONTRACTOR:	
DRAWN BY:	KEVIN VERGARA
CHECKED BY:	KYLE SCHNECK

DATE:	12/23/19


	SHEET:
	402

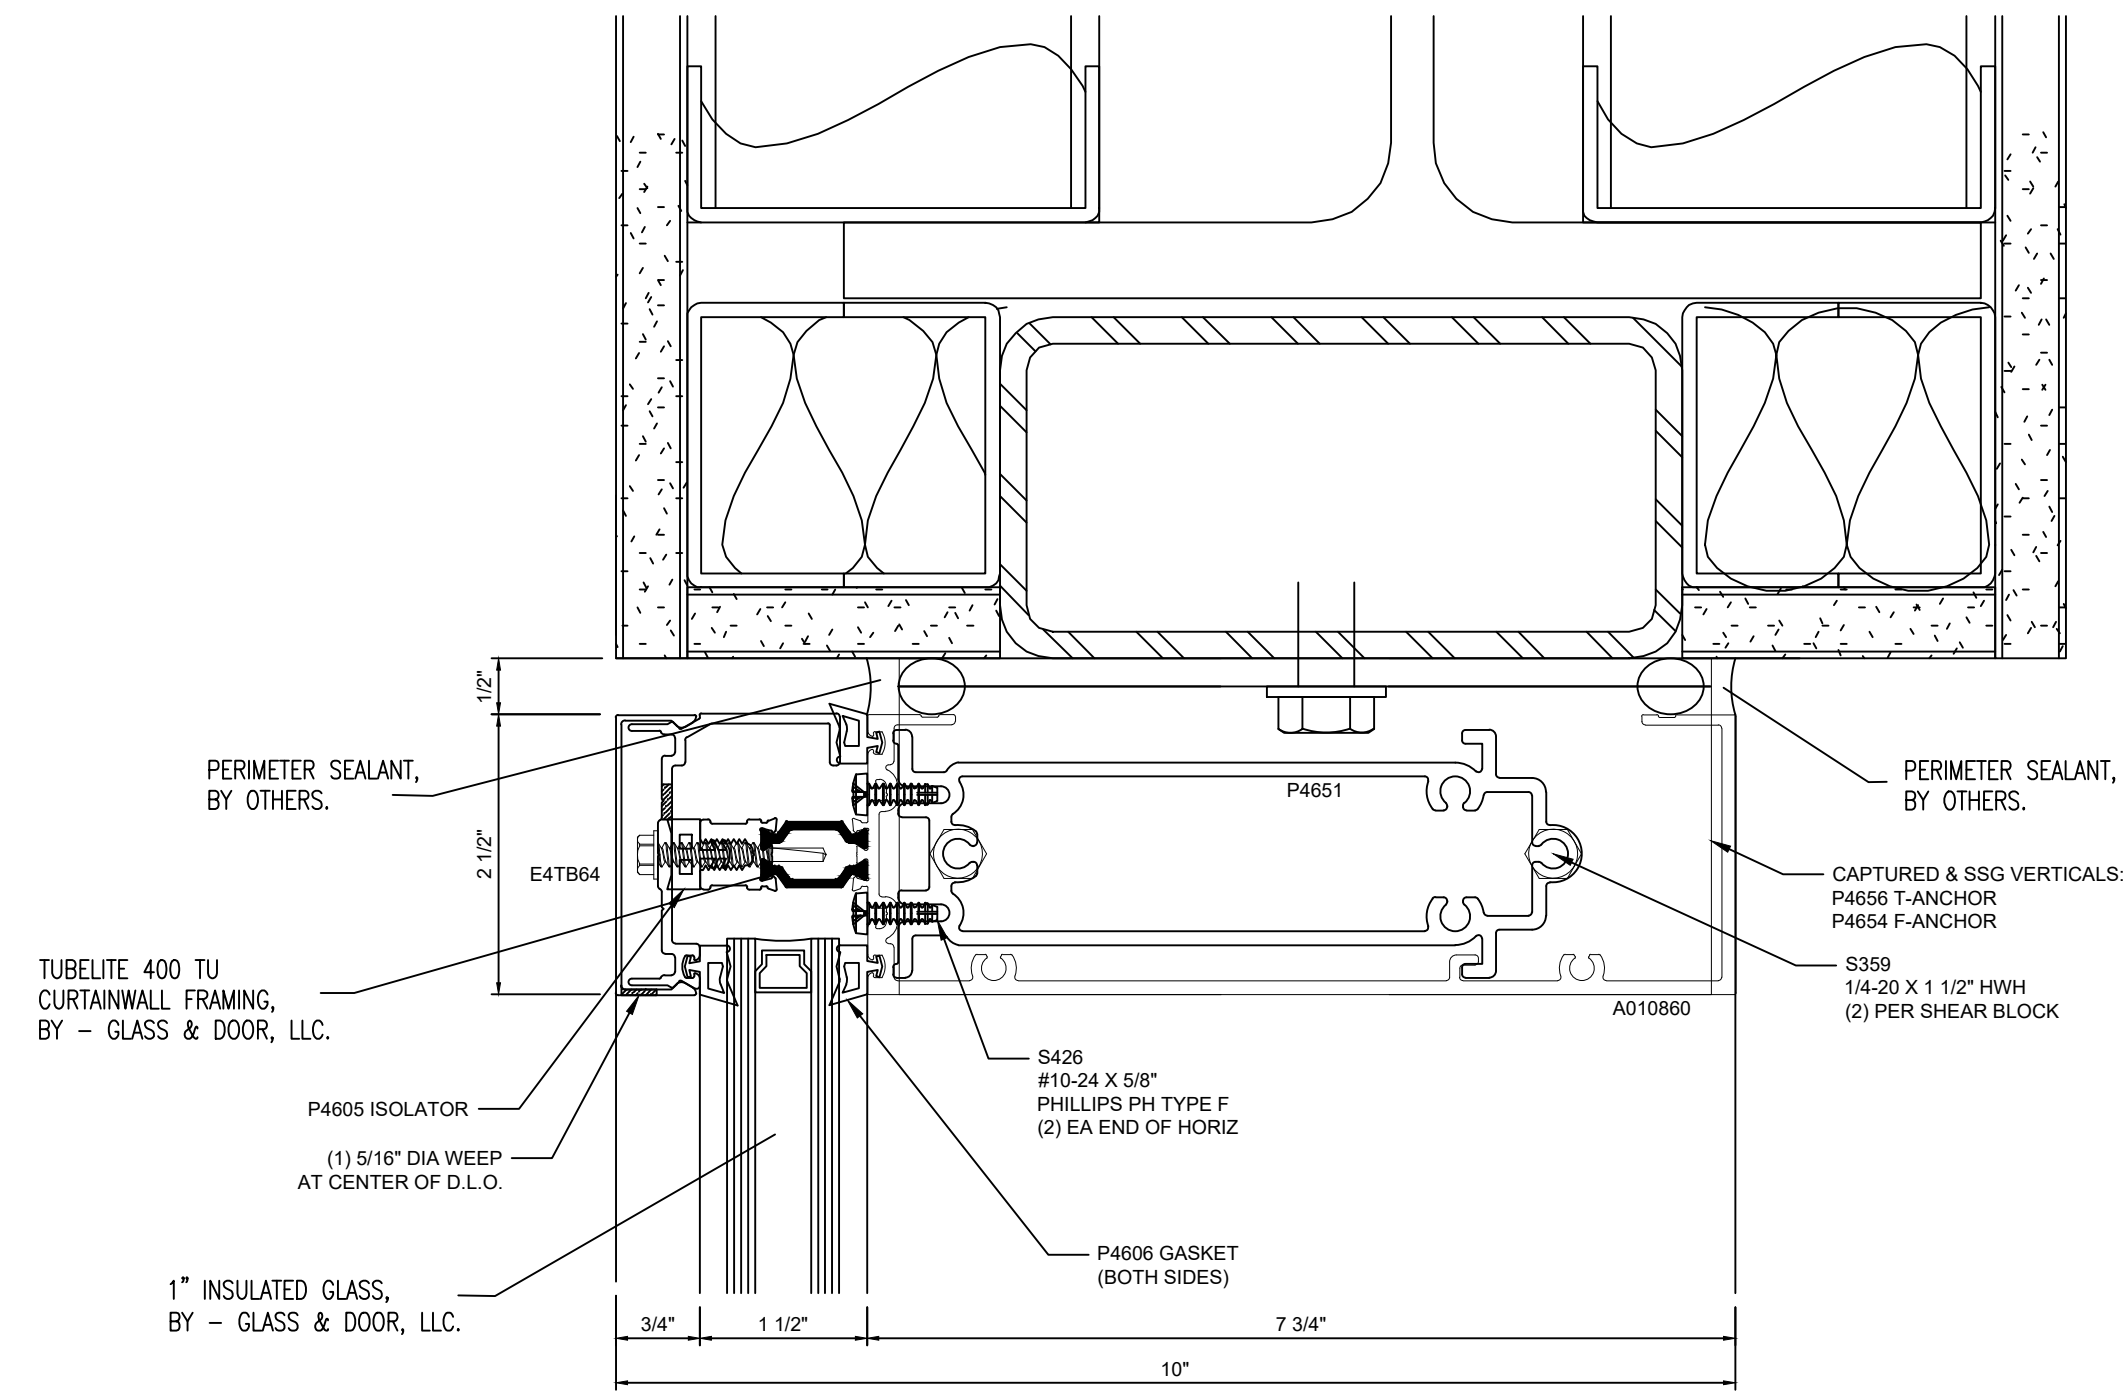


1 SECTION VIEW
● CURTAINWALL HEAD

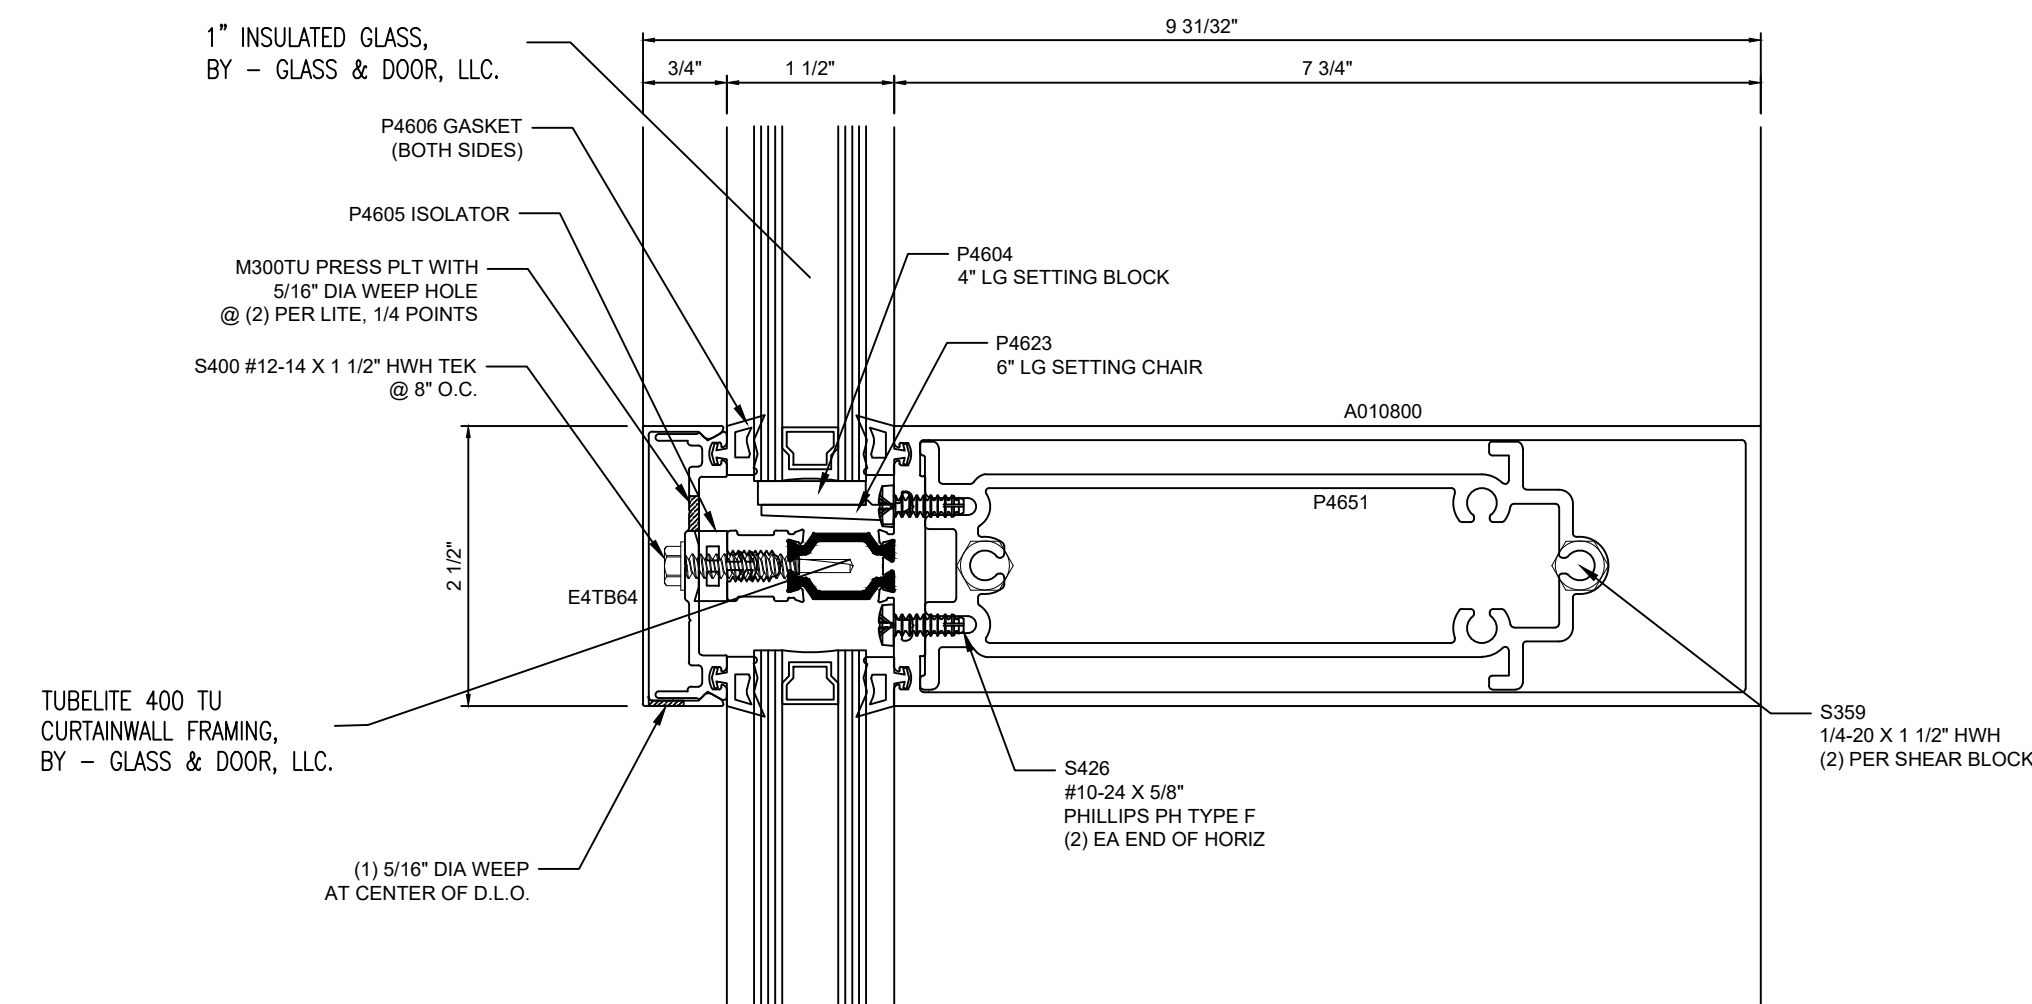

2 SECTION VIEW
● CURTAINWALL HORIZONTAL

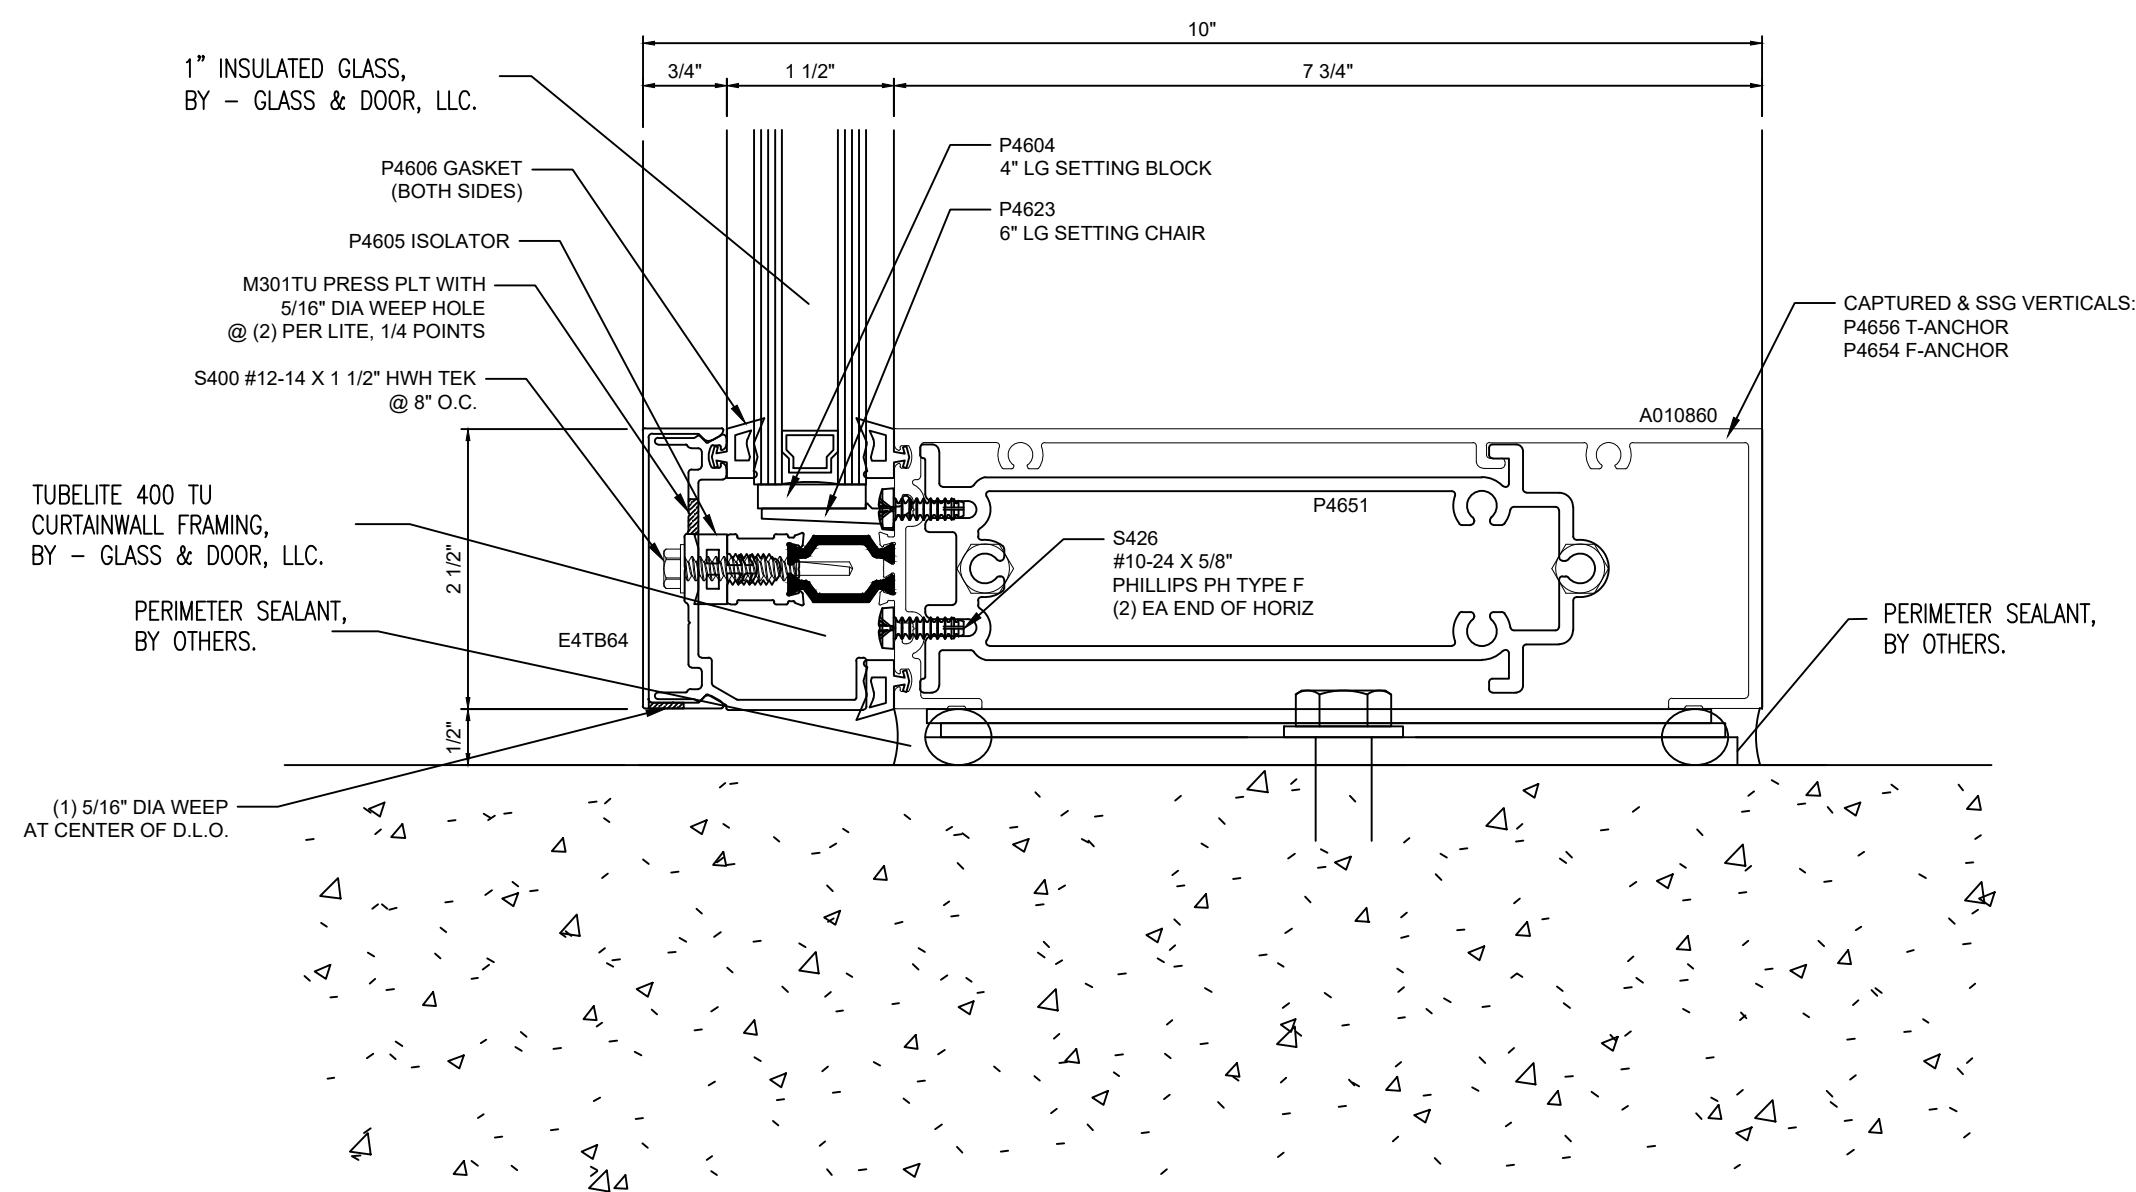

3 SECTION VIEW
● CURTAINWALL SILL

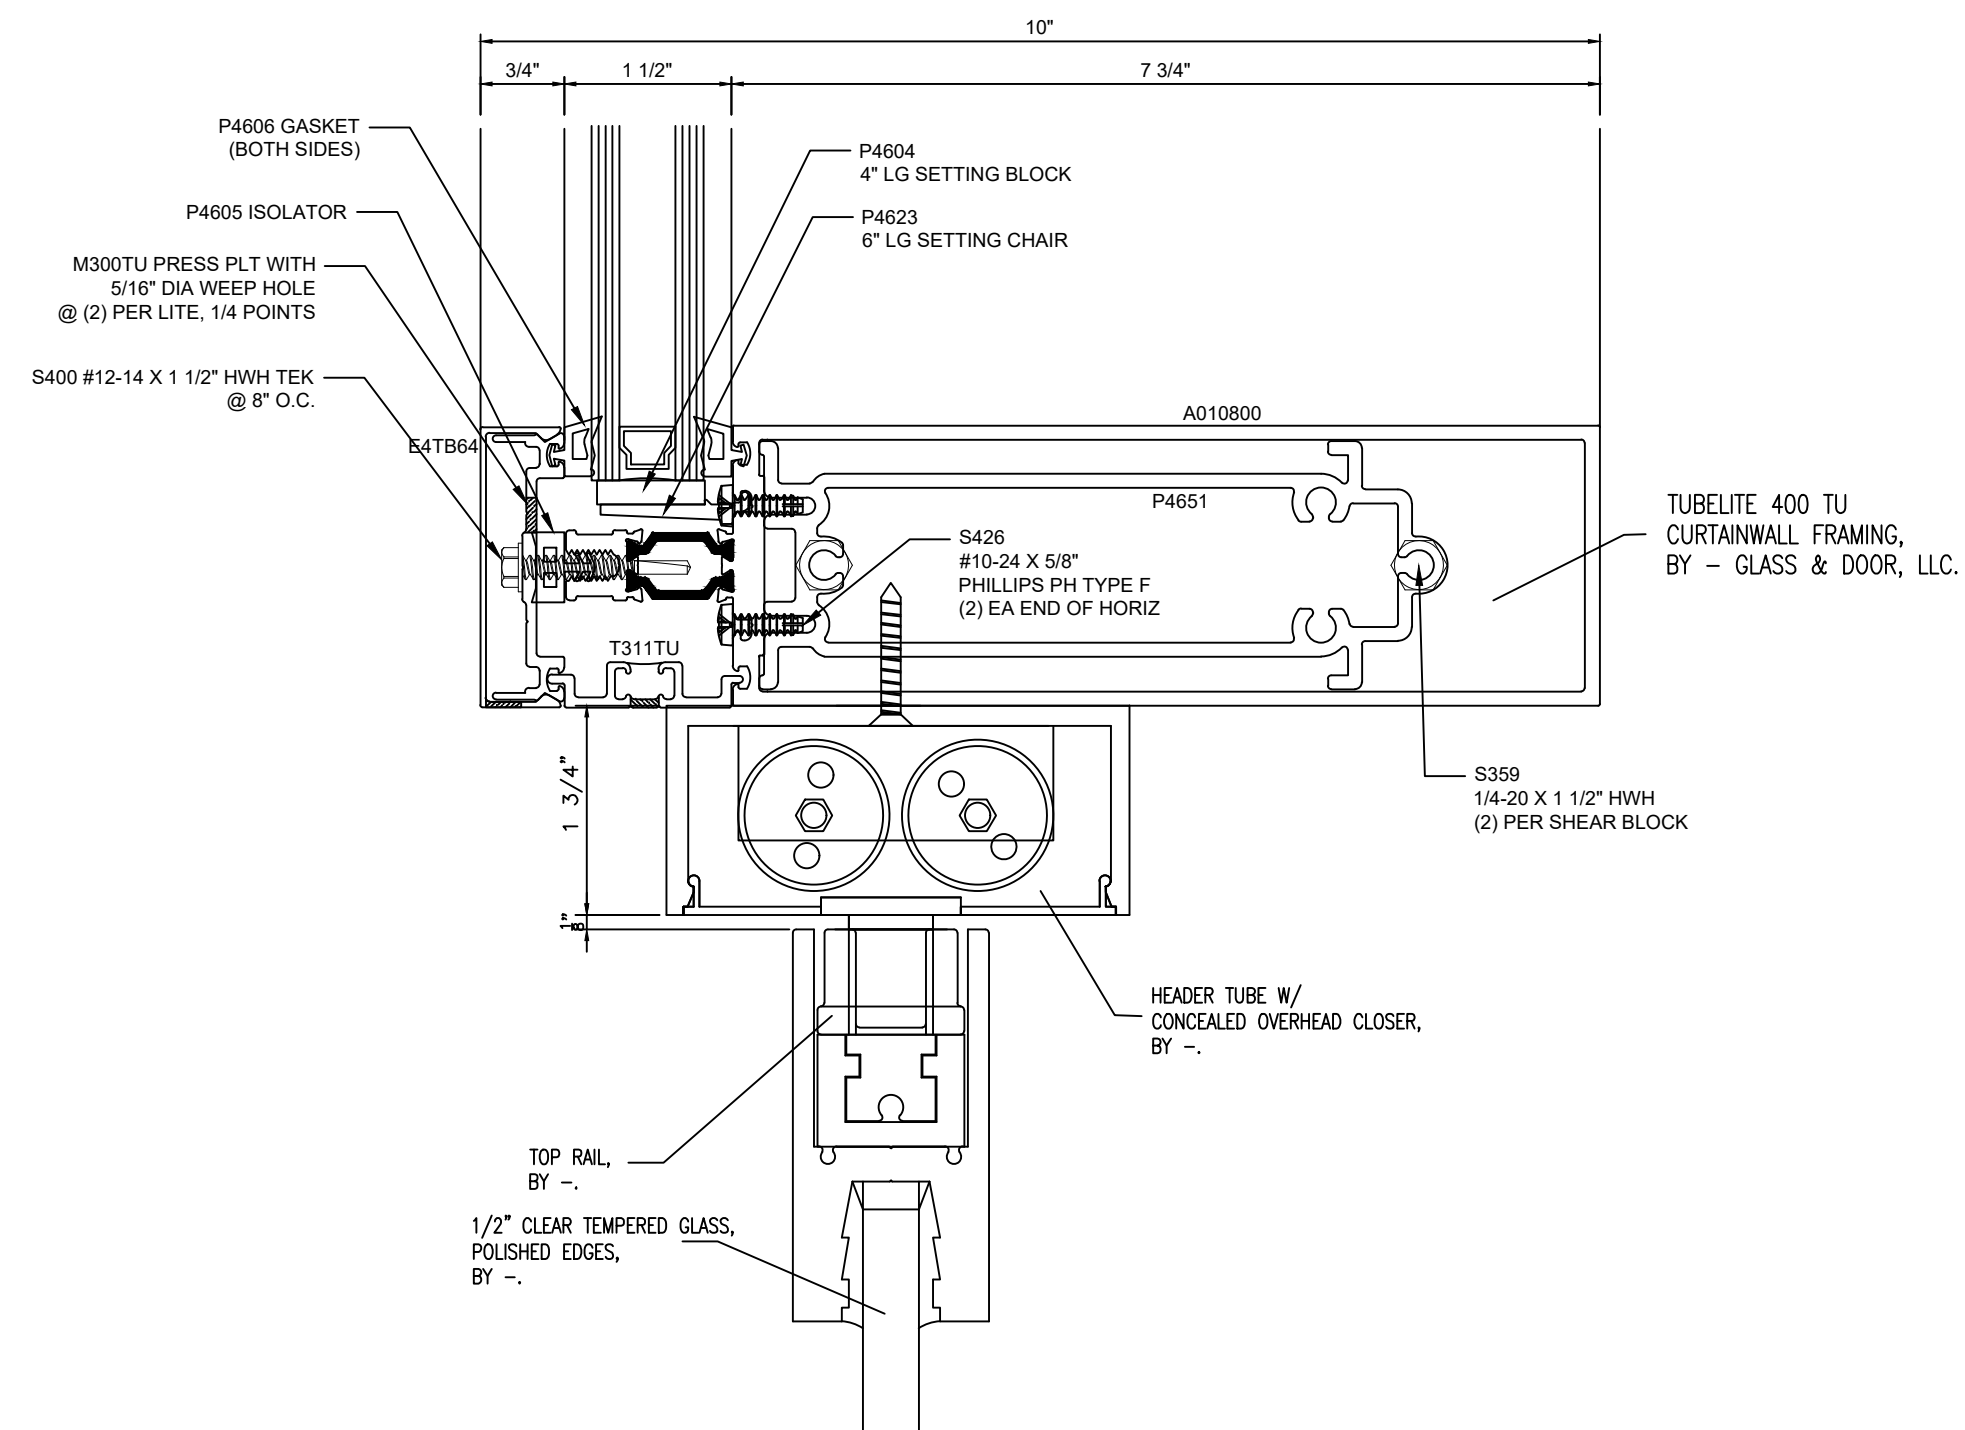

4 SECTION CUT
● GLASS DOOR TOP RAIL

NO.	REVISION/ISSUED	DATE
1	1ST SUBMITTAL	12/23/19

PROJECT NAME & LOCATION: FDA	10749 WEST 84TH TERRACE LENEXA, KANSAS 66214	
	SHEET TITLE:	DETAILS


DRAFTSMAN:
KS DRAFTING & DESIGN, LLC. KYLE SCHNECK HARRISBURG, PA 17110 KYLE@KSDRAFTINGDESIGNLLC.COM 717-228-7114 KSDRAFTINGDESIGNLLC.COM

ARCHITECT:

GLAZING CONTRACTOR:

DRAWN BY:	KEVIN VERGARA
CHECKED BY:	KYLE SCHNECK

DATE:	12/23/19	SHEET: 403

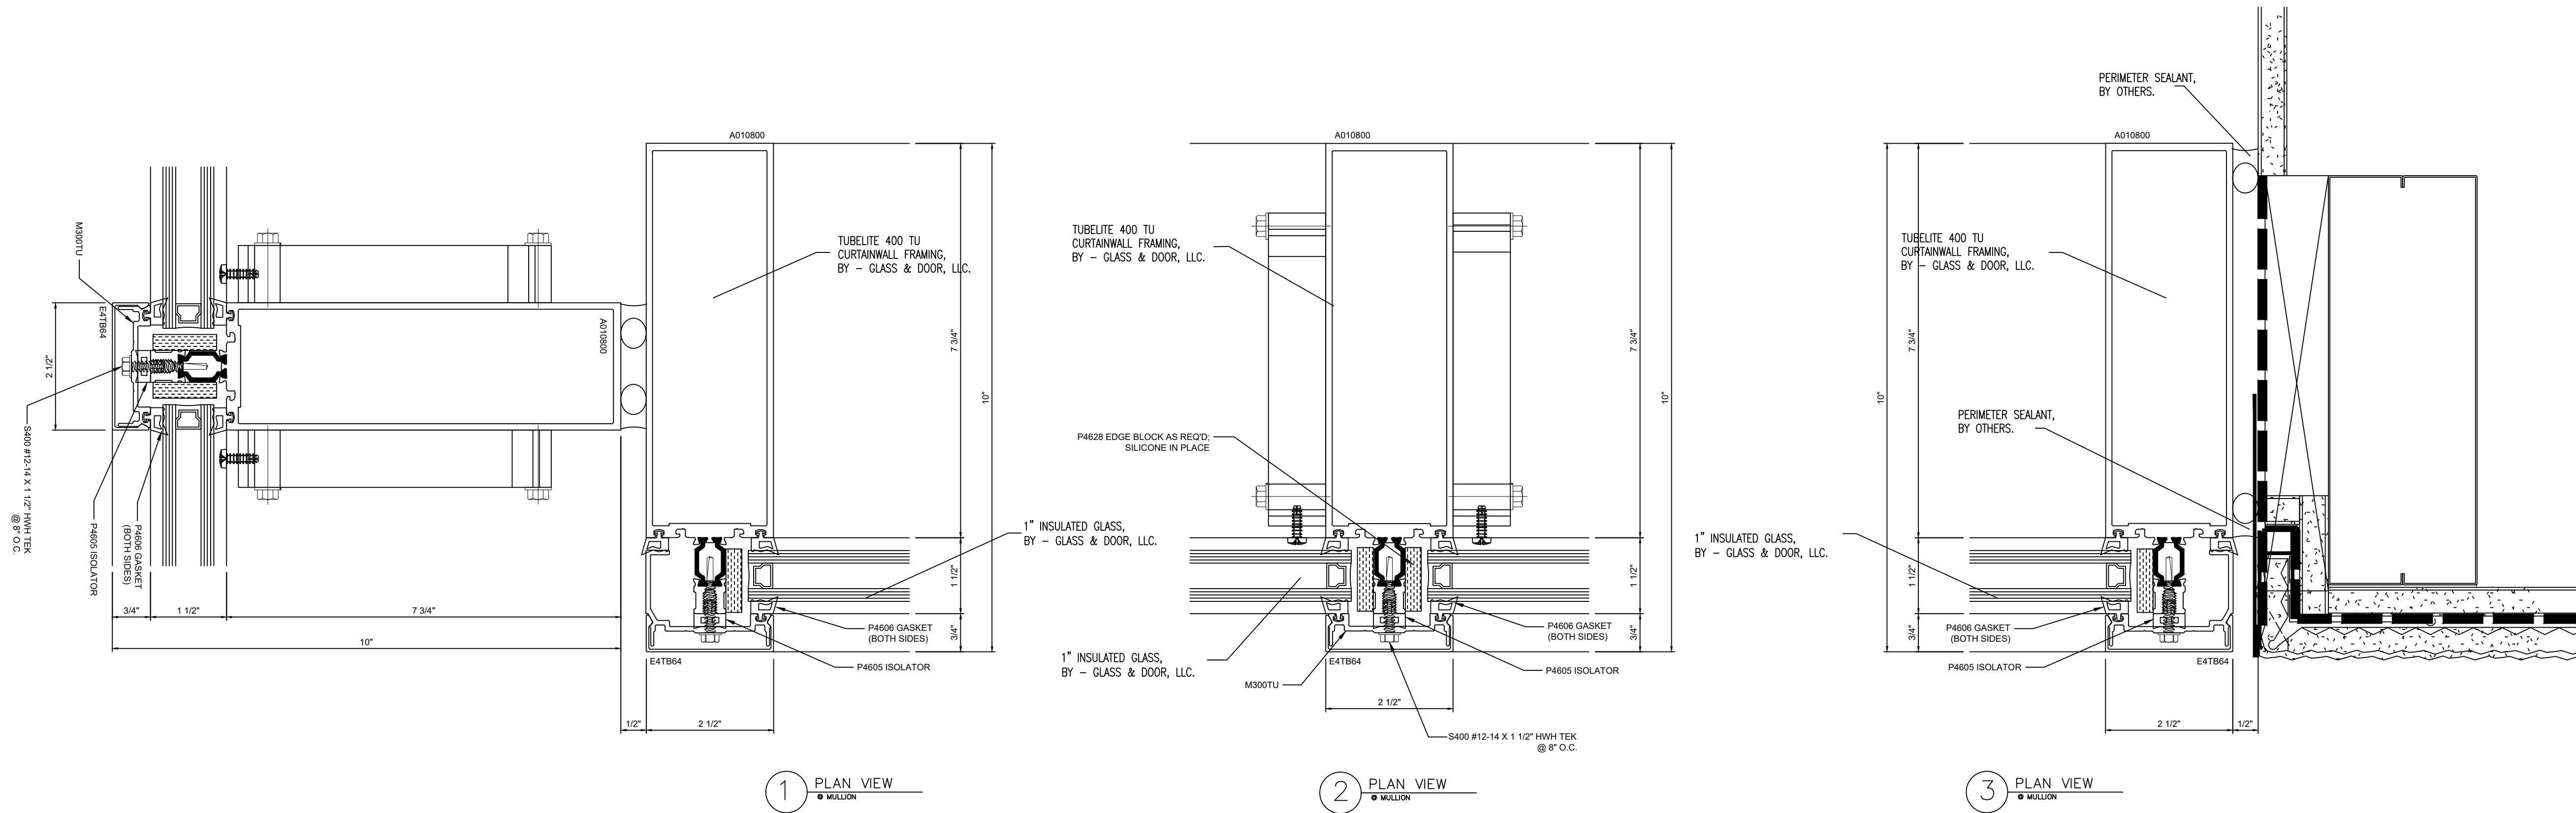

NO.	REVISION/ISSUED	DATE
1	1ST SUBMITTAL	12/23/19

PROJECT NAME & LOCATION: FDA	10749 WEST 84TH TERRACE LENEXA, KANSAS 66214	
	SHEET TITLE: DETAILS	

DRAFTSMAN:
KS DRAFTING & DESIGN, LLC. KYLE SCHNECK HARRISBURG, PA 17110 KYLE@KSDRAFTINGDESIGNLLC.COM 717-228-7114 KSDRAFTINGDESIGNLLC.COM

ARCHITECT:

GLAZING CONTRACTOR:

DRAWN BY:	KEVIN VERGARA
CHECKED BY:	KYLE SCHNECK

DATE:	12/23/19	SHEET:
		404